
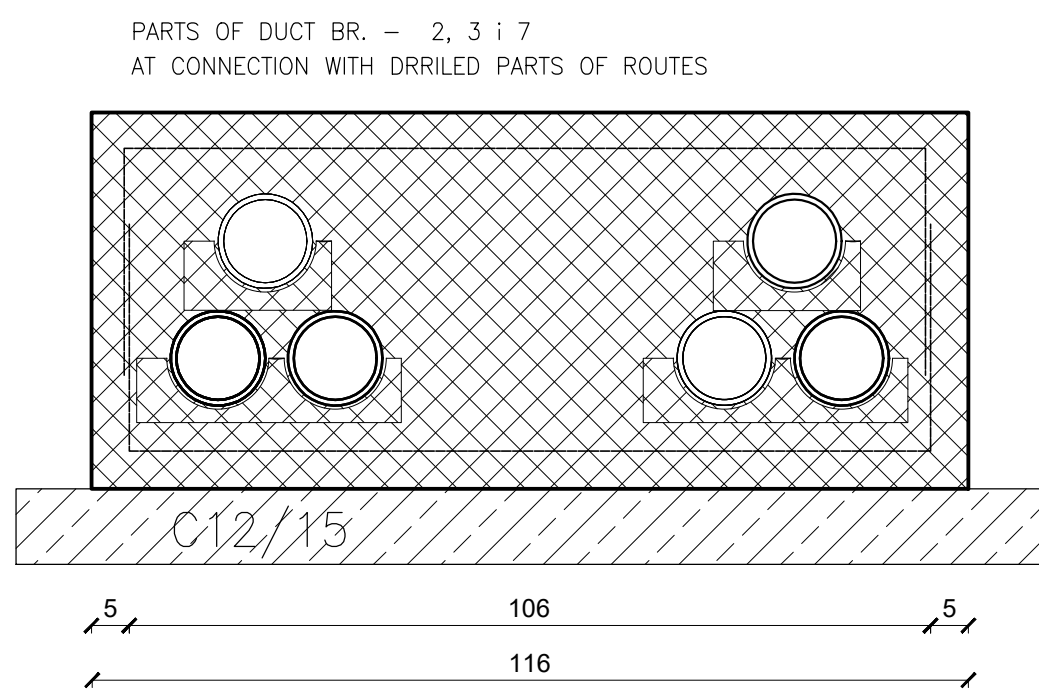
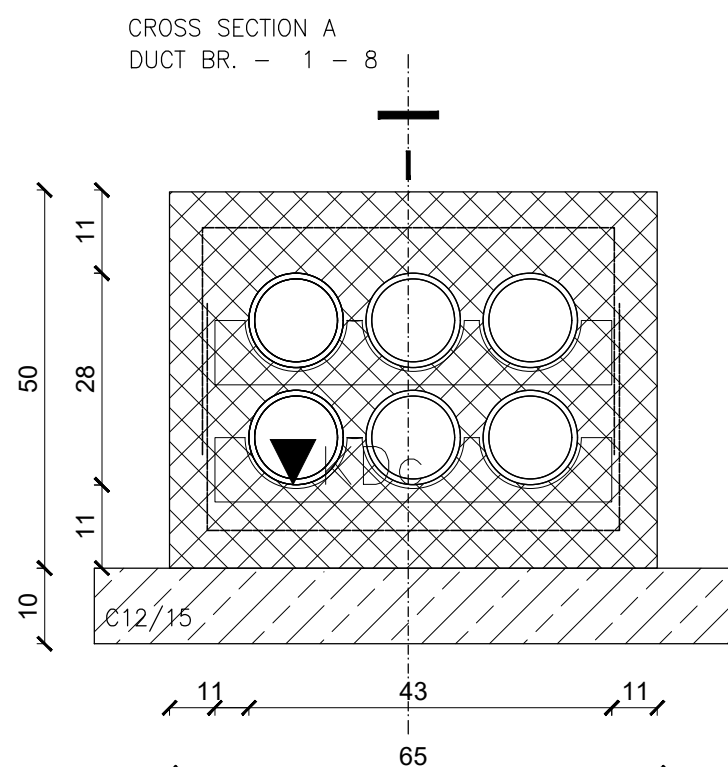
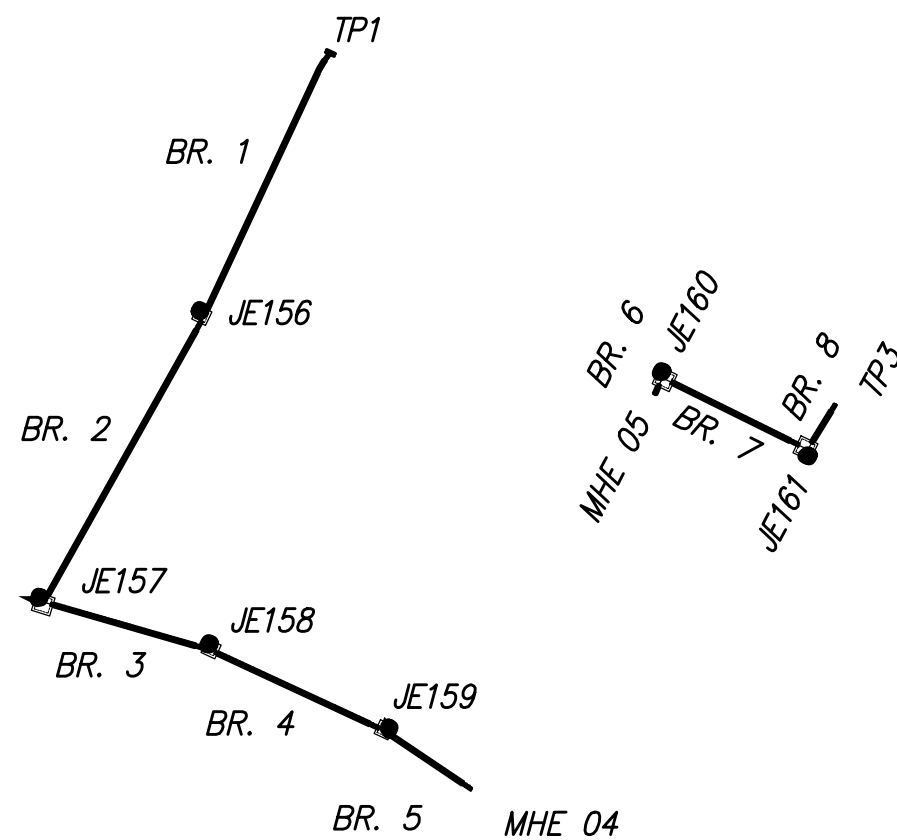


H2.2-10

1. Interim Dwg. No.:	B-436-018-0-IC
Interim Sketch No.:	N/A
2. Design Mod. No.:	1345-EE-L
3. Drawing. Rev. No.:	-
4. New Drawing. No.:	B-436-018
5. Resp. Eng.: R. ŠPIONJAK	Date: 05. 2025.
6. Cheker: B.LALATOVIĆ	Date: 05. 2025.

NUKLEARNA ELEKTRARNA KRSKO
NUCLEAR POWER PLANT KRSKO

Manhole and concrete duct protection block layout

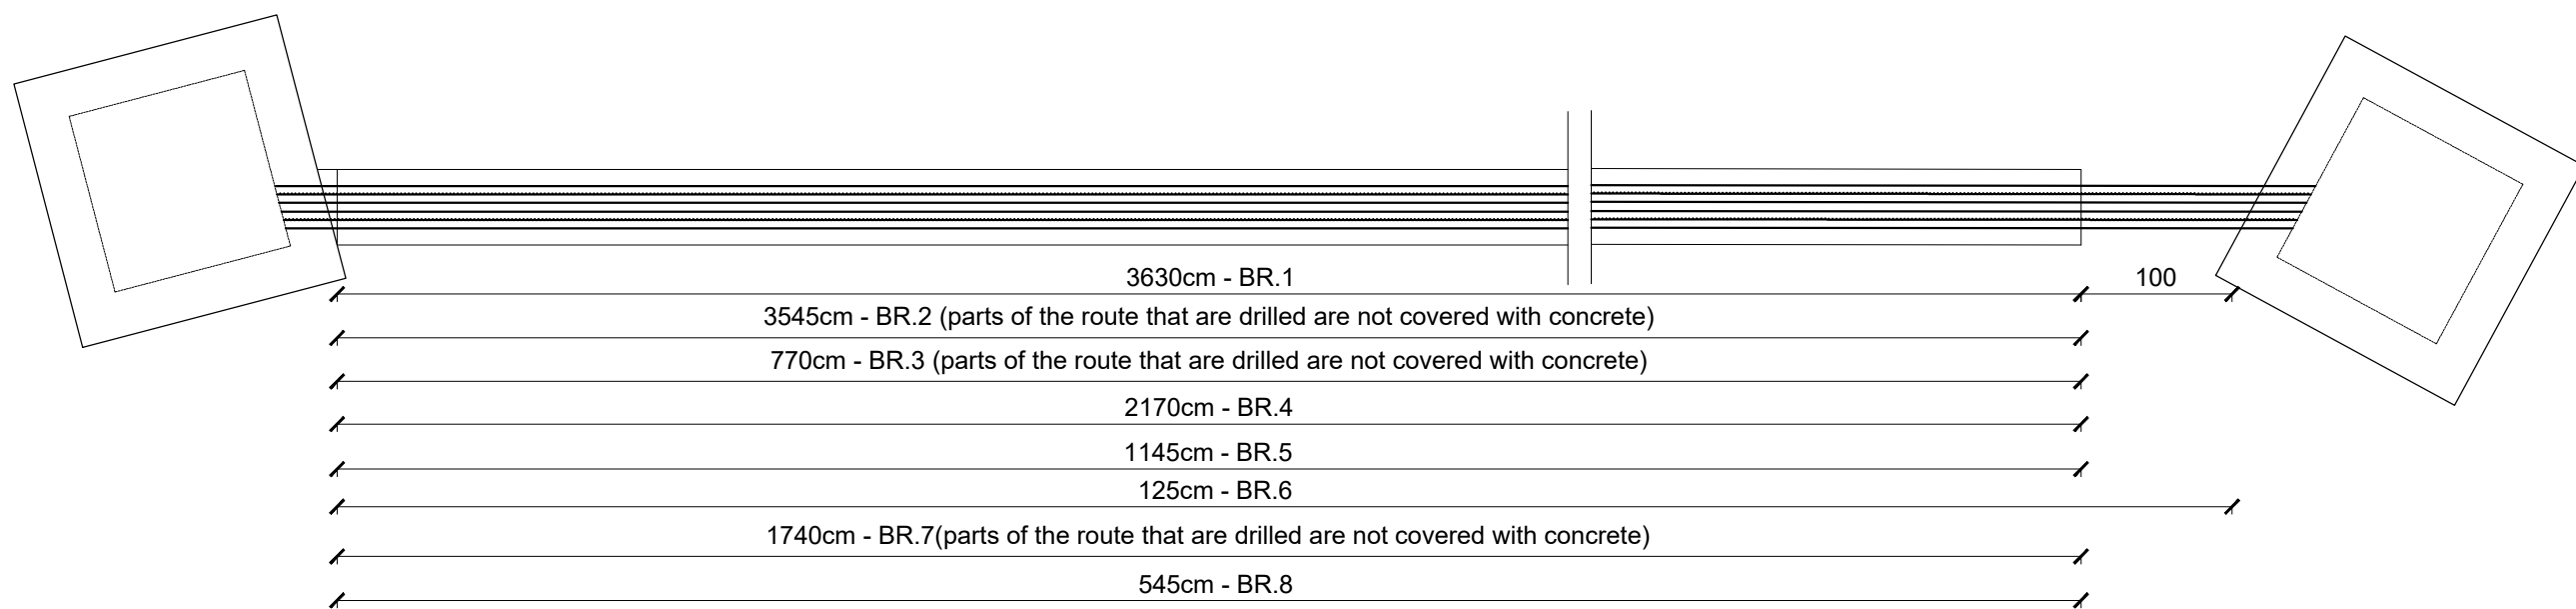

DESIGN ENGINEERING

NUCLEAR POWER PLANT KRSKO KRSKO, SLOVENIA

MADE	CHECKED	LE APPROVAL
1. R.ŠPIONJAK	2. D. VUKAS	3. J. KERIN

REFERENCE
DRAWINGS:

SCALE
1: 50

B-436-018

0 IC

DRAWING NUMBER SYSTEM SH.NO. REV

Original Design Firm: EKONERG
Replaced Manual Drawing: N/A
Last Revision And Date: 0. 07.2025.

THIS IS A CAD DRAWING AND SHOULD NOT BE REVISED OR MODIFIED MANUALLY

0	07.2025	EKO	ISSUED PER MOD 1345-EE-L	D.V.	J.K.
NO.	DATE	BY	REVISION	CKD. BY	LE APPR.