





65x50 cm- Normal cross section of trench- for pipes (3*2)

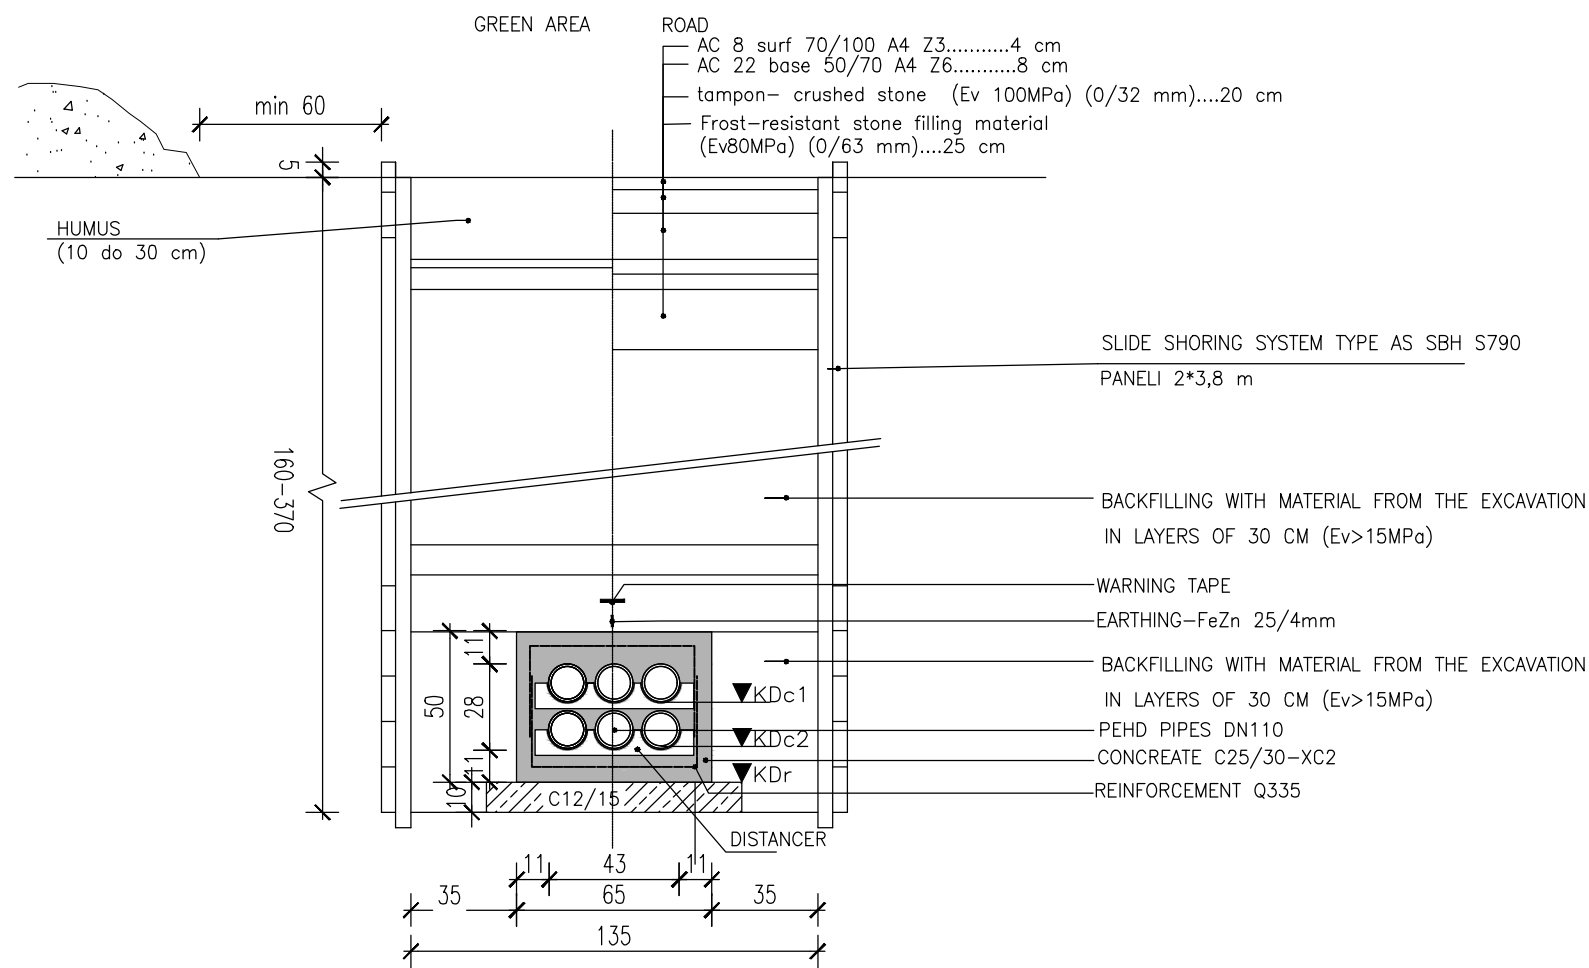

cross section of entrance and exit launching pit

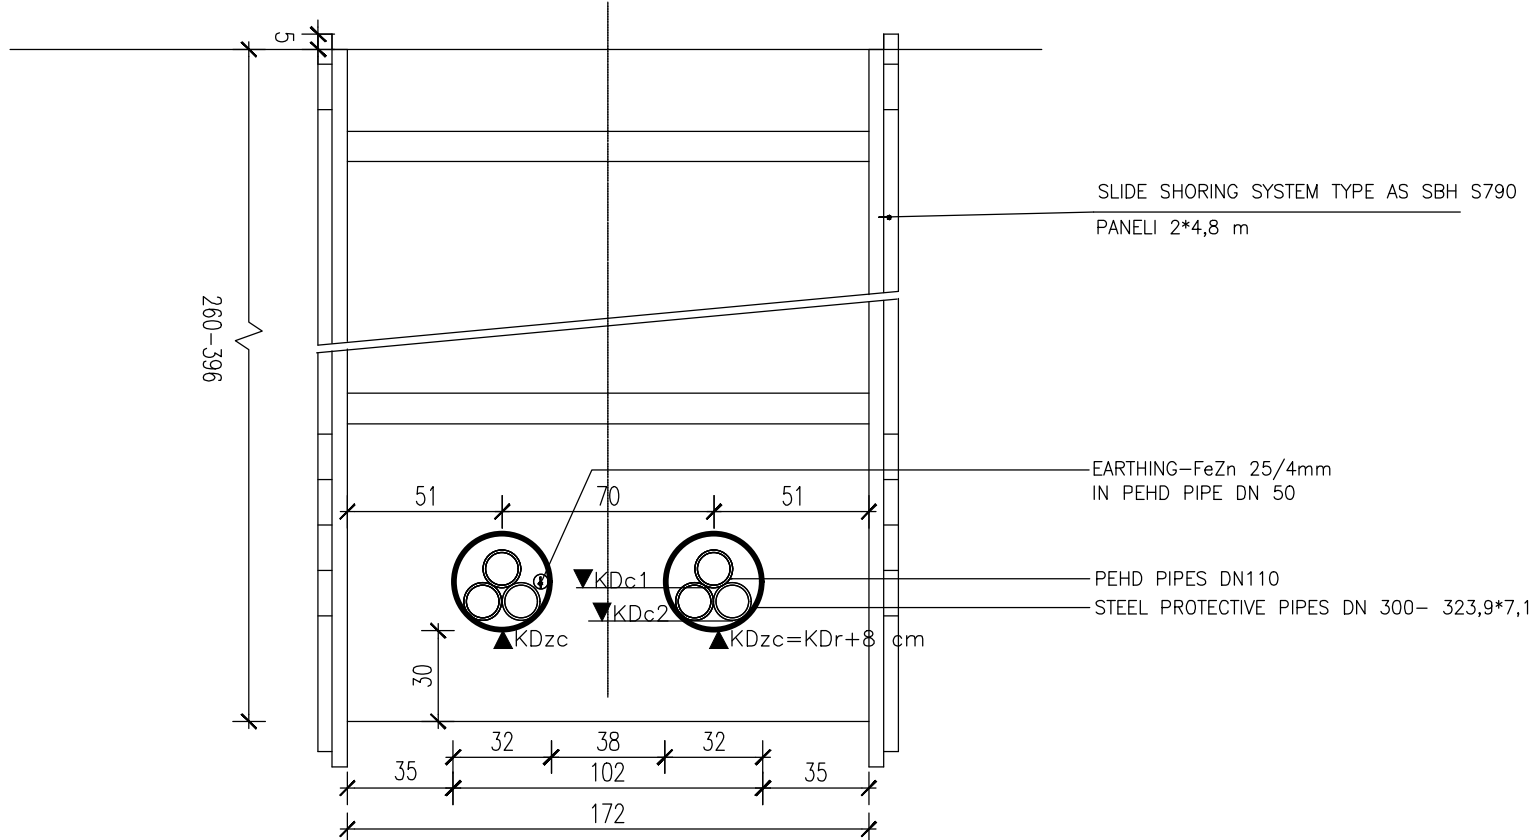

116x50 cm-characteristic cross-section of trench- for pipes (3*2)- at the transition to the protective pipes

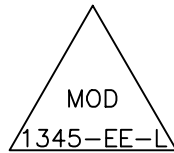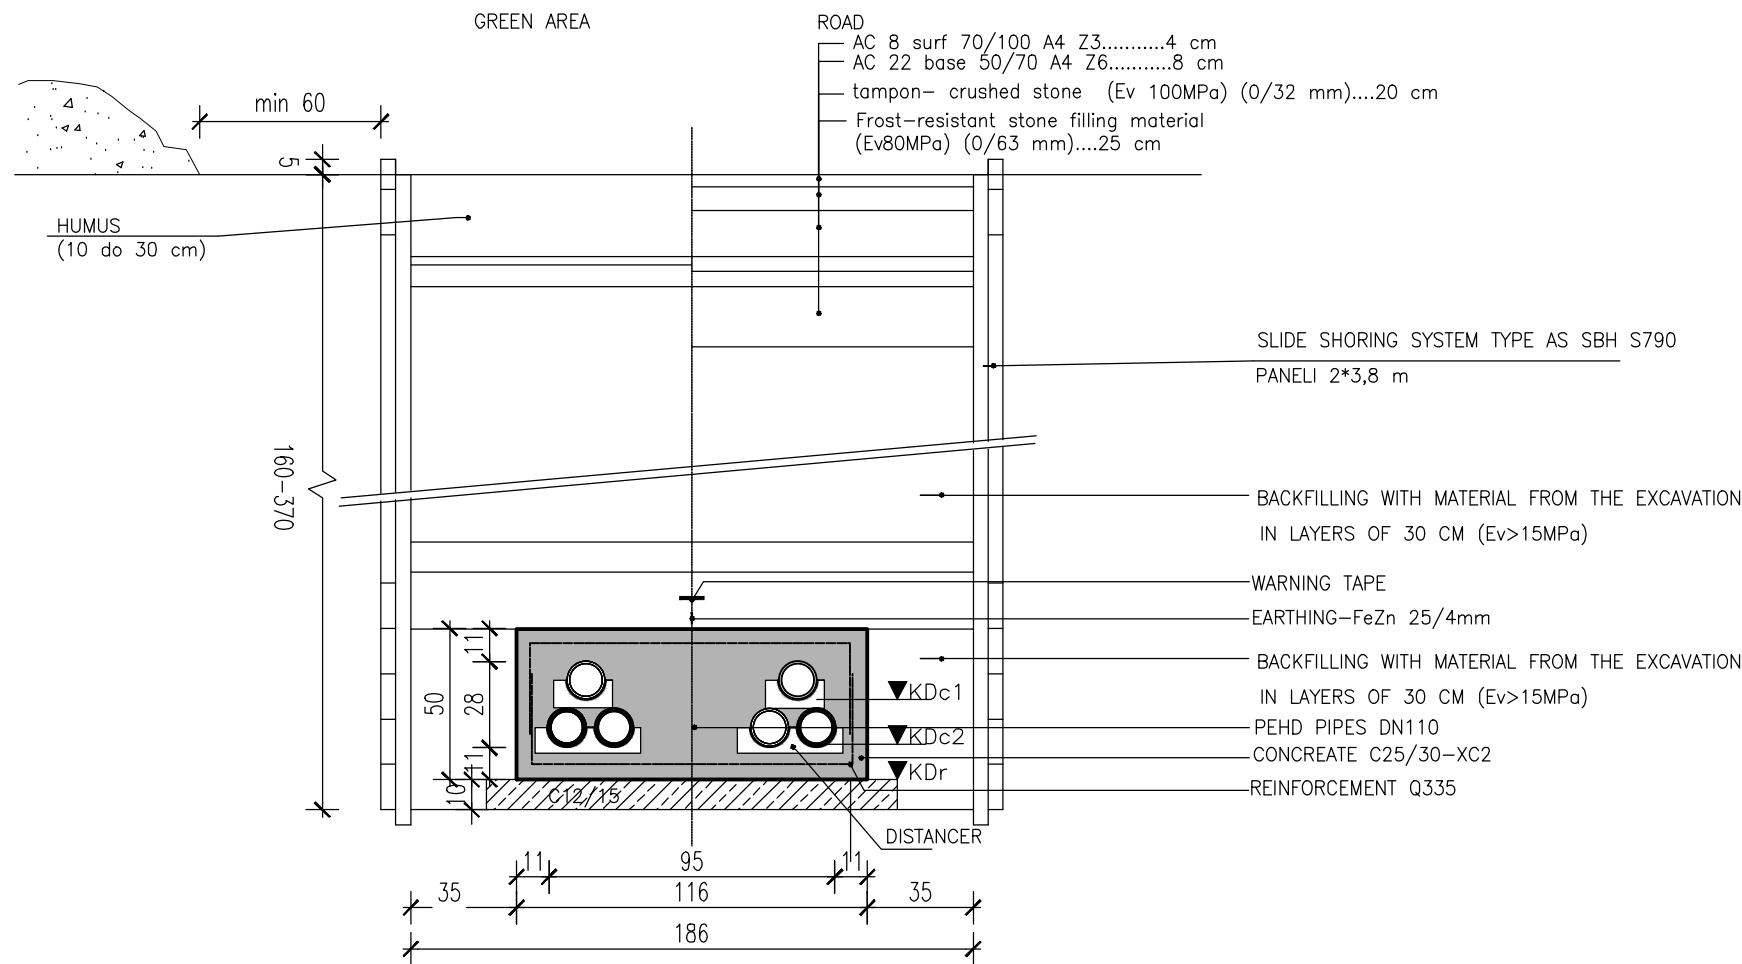

H2.2-18

1. Interim Dwg. No.:	B-436-026-0-IA
Interim Sketch No.:	N/A
2. Design Mod. No.:	1345-EE-L
3. Drawing. Rev. No.:	-
4. New Drawing. No.:	B-436-026
5. Resp. Eng.: R. ŠPIONJAK	Date: 05. 2025.
6. Cheker: B.LALATOVIĆ	Date: 05. 2025.

Original Design Firm: EKONERG
Replaced Manual Drawing: N/A
Last Revision And Date: 0, 07.2025.

THIS IS A CAD DRAWING AND SHOULD NOT BE REVISED OR MODIFIED MANUALLY

0	07.2025	EKO	ISSUED PER MOD 1345-EE-L	D.V.	J.K.
NO.	DATE	BY	REVISION	CKD. BY	LE APPR.

NUKLEARNA ELEKTRARNA KRSKO NUCLEAR POWER PLANT KRSKO					
Cross section of the trench for electrical installations					
DESIGN ENGINEERING					
MADE			CHECKED		LE APPROVAL
1.	R.ŠPIONJAK	2.	D. VUKAS	3.	J. KERIN
REFERENCE DRAWINGS:					
SCALE 1:50					
B-436-026					
DRAWING NUMBER			SYSTEM	SH.NO.	REV