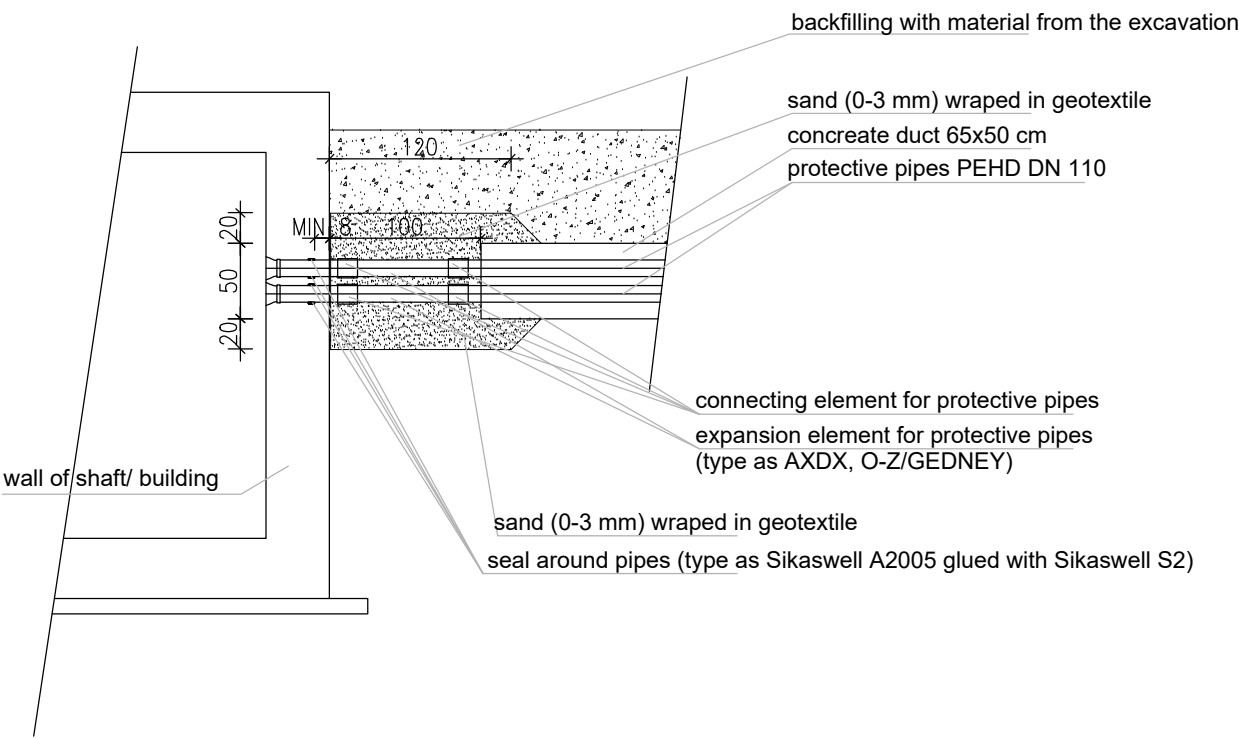
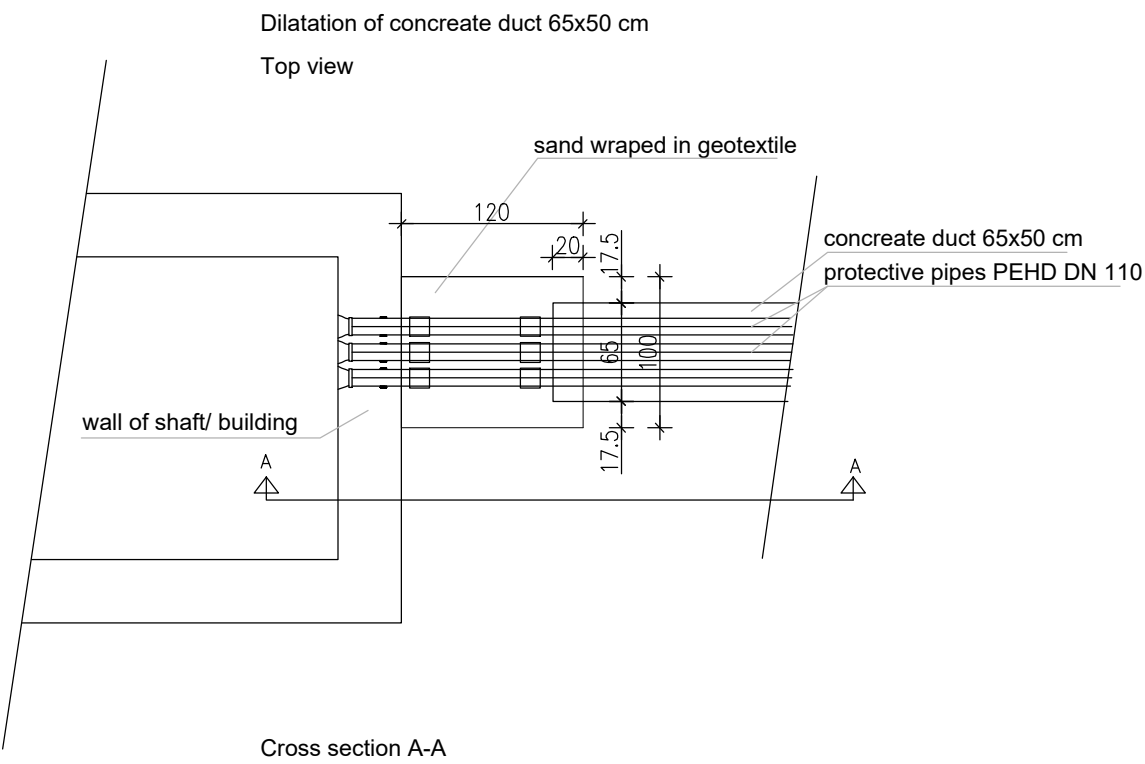


H2.2-19

1. Interim Dwg. No.:	B-436-027-0-IA
Interim Sketch No.:	N/A
2. Design Mod. No.:	1345-EE-L
3. Drawing. Rev. No.:	-
4. New Drawing. No.:	B-436-027
5. Resp. Eng.: R. ŠPIONJAK	Date: 05. 2025.
6. Cheker: B.LALATOVIČ	Date: 05. 2025.

- MARK:
1. PERFORM DILATION ONLY ON ONE SIDE OF CONCRETE DUCT
 2. CONCRETE DUCT NR 6 IS WITHOUT DILATATION

Original Design Firm: EKONERG
Replaced Manual Drawing: N/A
Last Revision And Date: 0, 07.2025.

THIS IS A CAD DRAWING AND SHOULD NOT BE REVISED OR MODIFIED MANUALLY

0	07.2025	EKO	ISSUED PER MOD 1345-EE-L	D.V.	J.K.
NO.	DATE	BY	REVISION	CKD. BY	LE APPR.

NUKLEARNA ELEKTRARNA KRSKO NUCLEAR POWER PLANT KRSKO				
Expansion joint of concrete cable block				
	DESIGN ENGINEERING			
NUCLEAR POWER PLANT KRSKO			KRSKO, SLOVENIA	
MADE		CHECKED	LE APPROVAL	
1. R.ŠPIONJAK	2. D. VUKAS	3. J. KERIN		
REFERENCE DRAWINGS:				
SCALE 1:50	B-436-027			0
DRAWING NUMBER		SYSTEM	SH.NO.	REV.