



A
B
C
D
E
F
G
H


TLORIS – PREREZ d–d

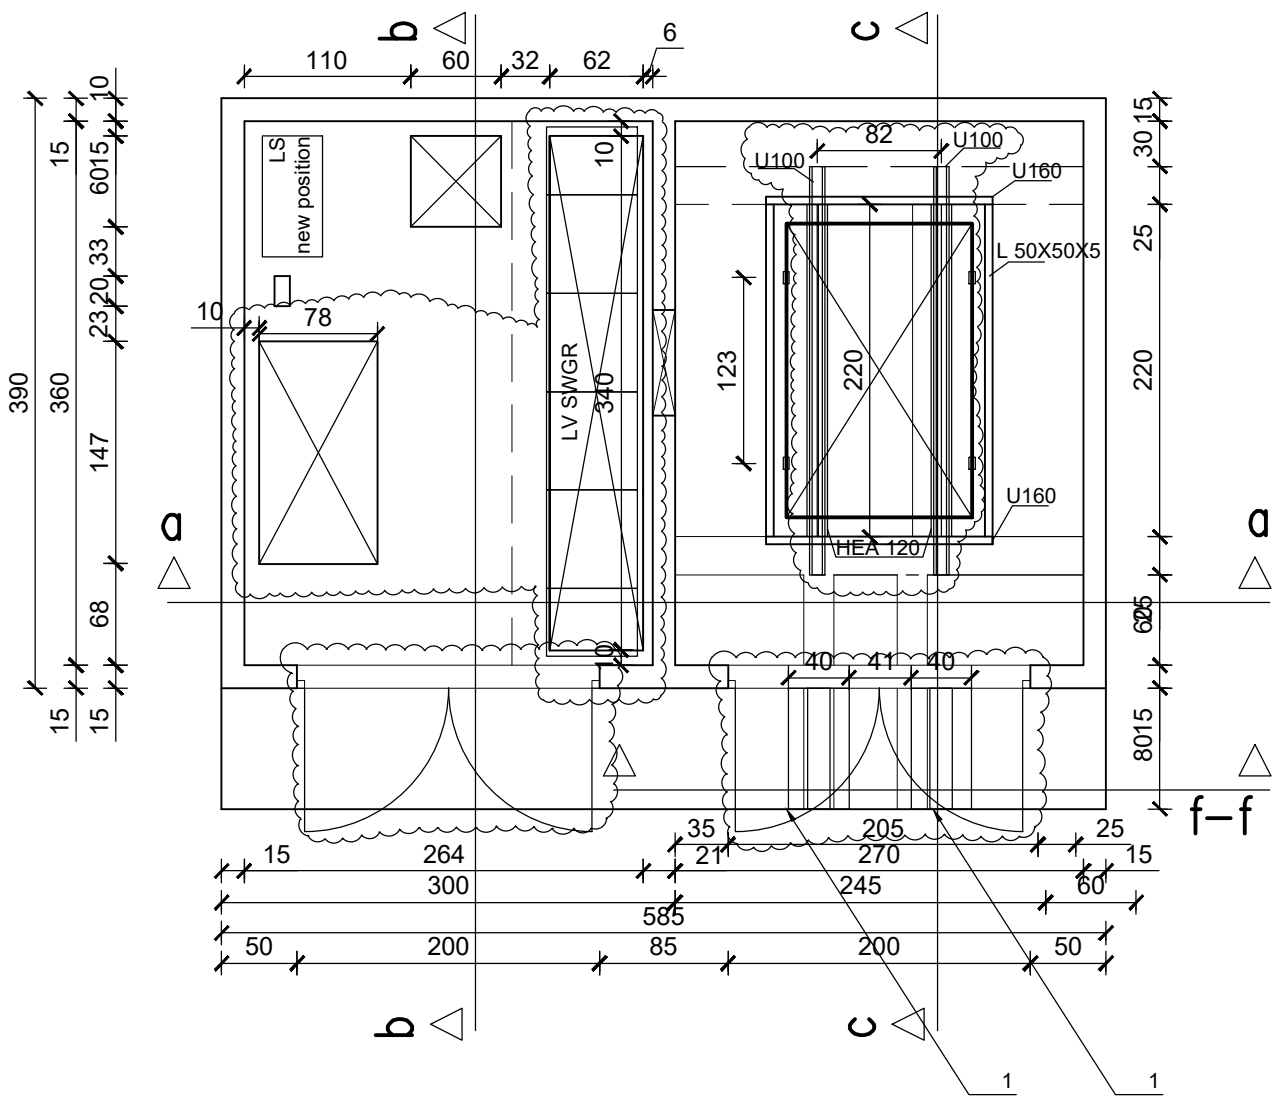


TLORIS – PREREZ e–e

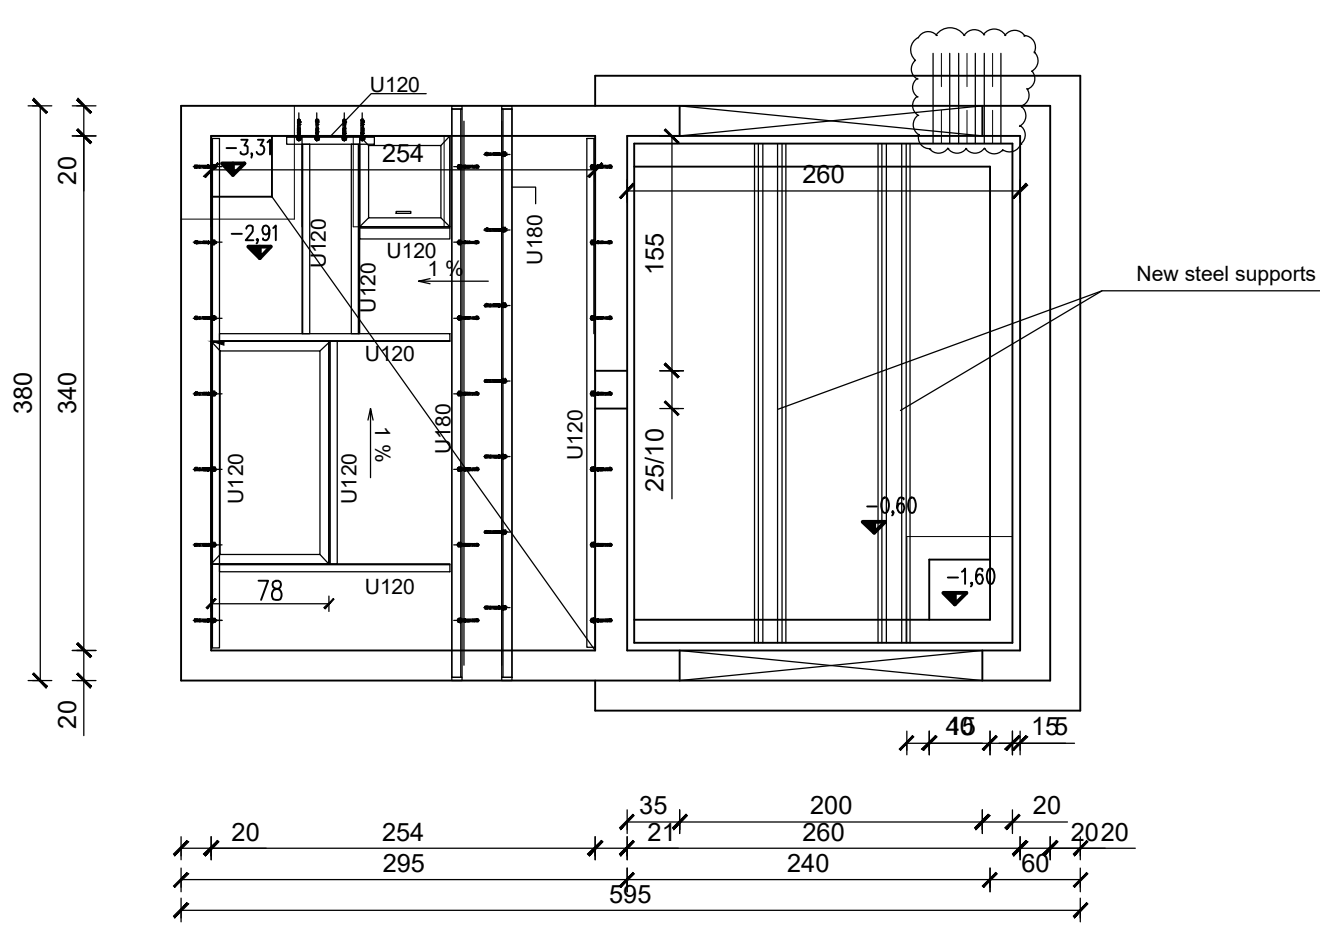


TLORIS STREHE

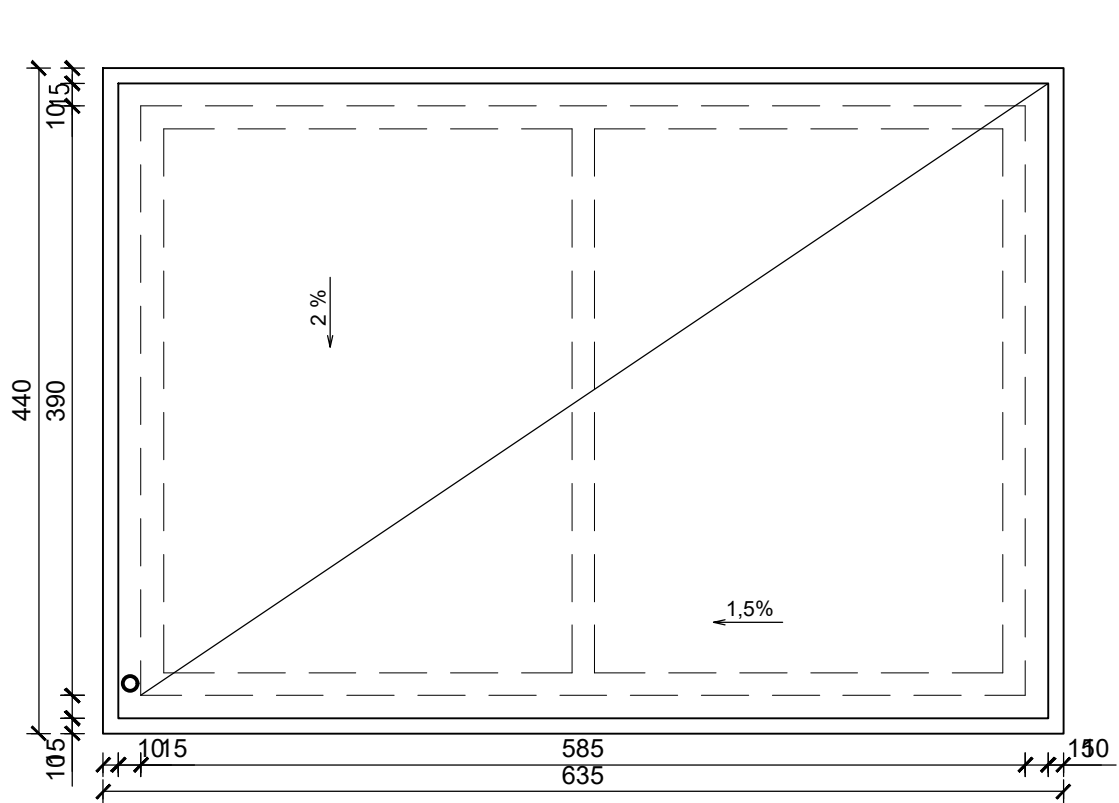


PREREZ a–a

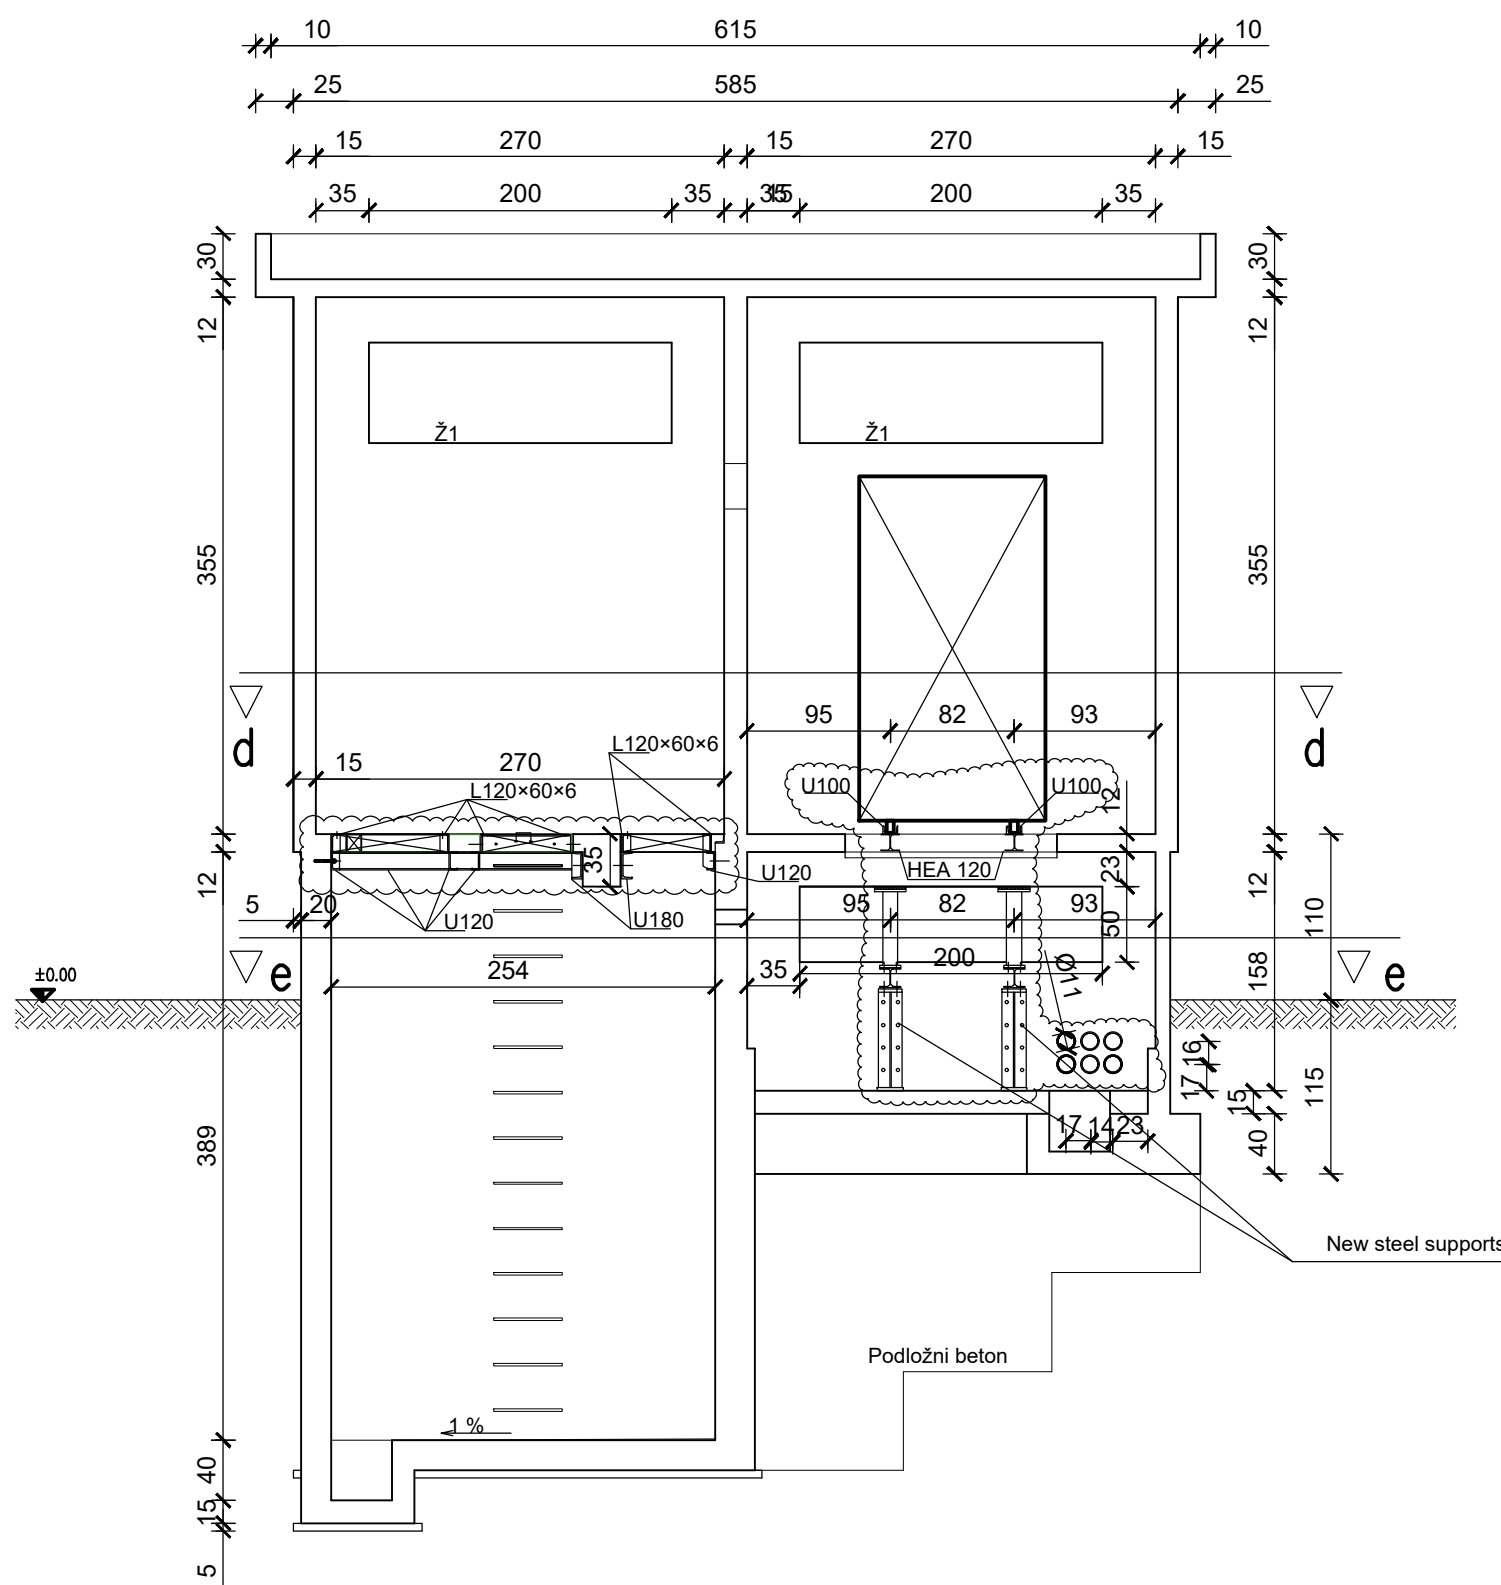

PREREZ b–b

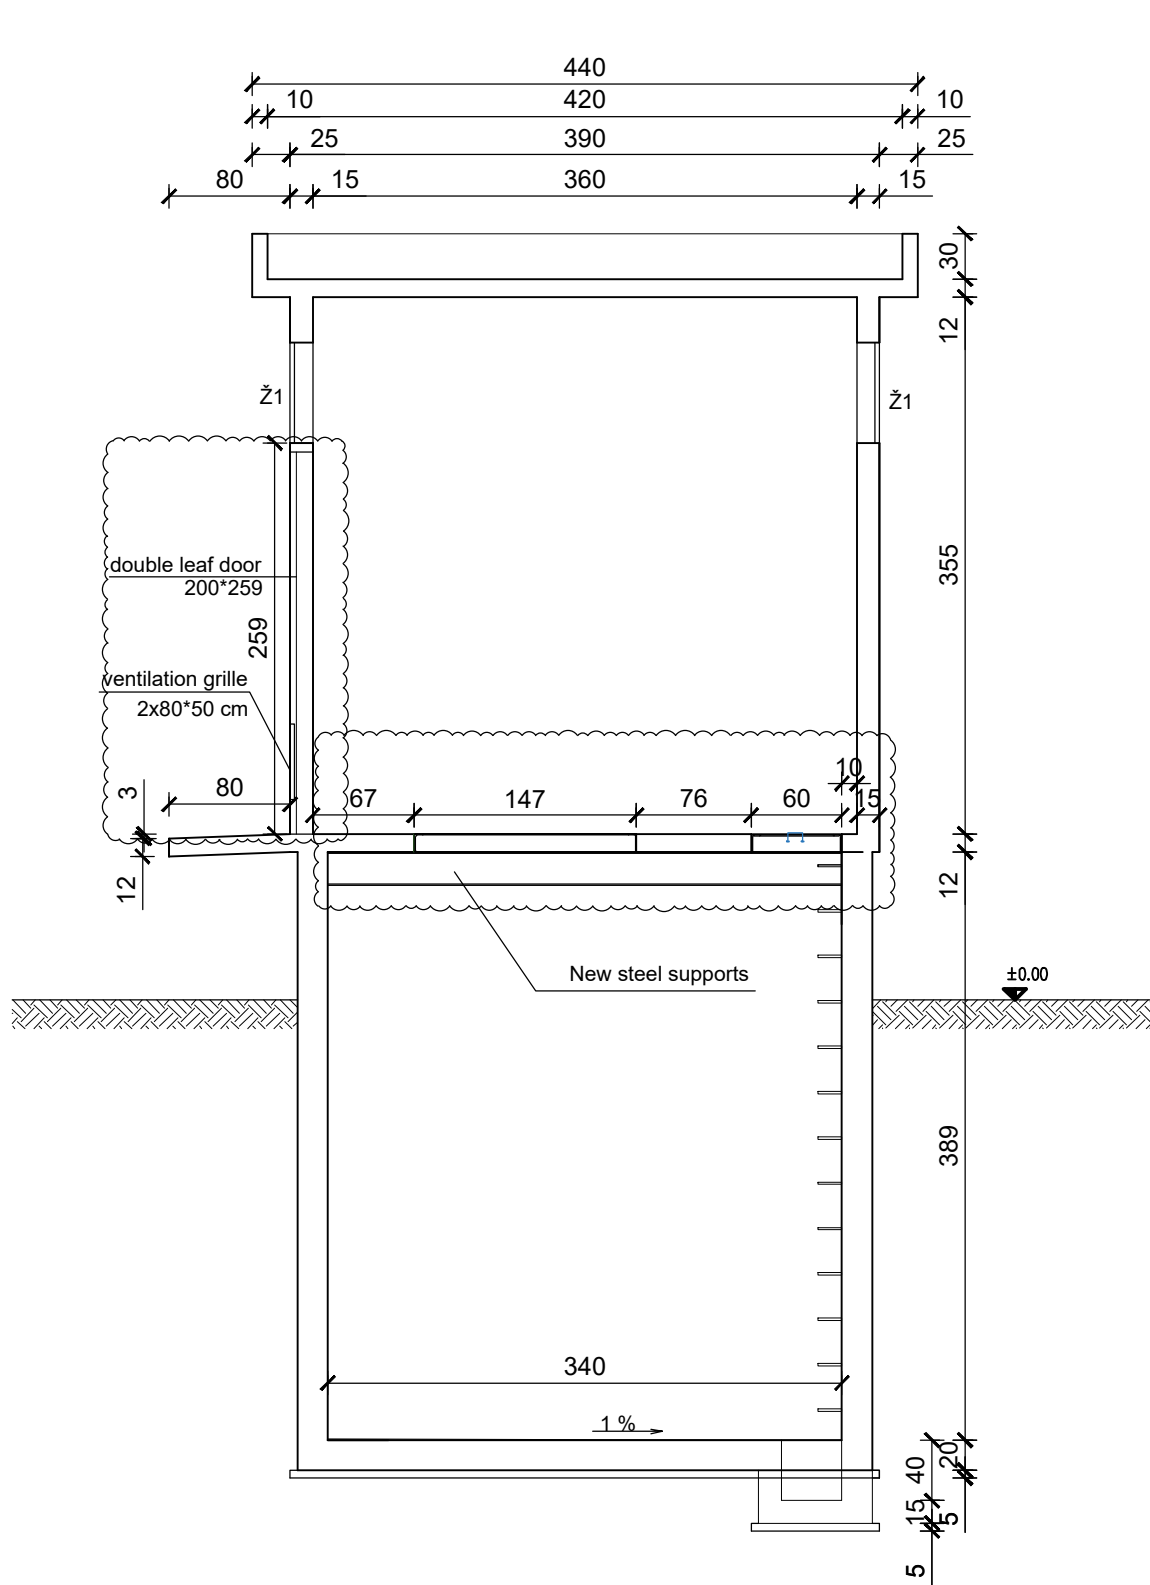

PREREZ c–c

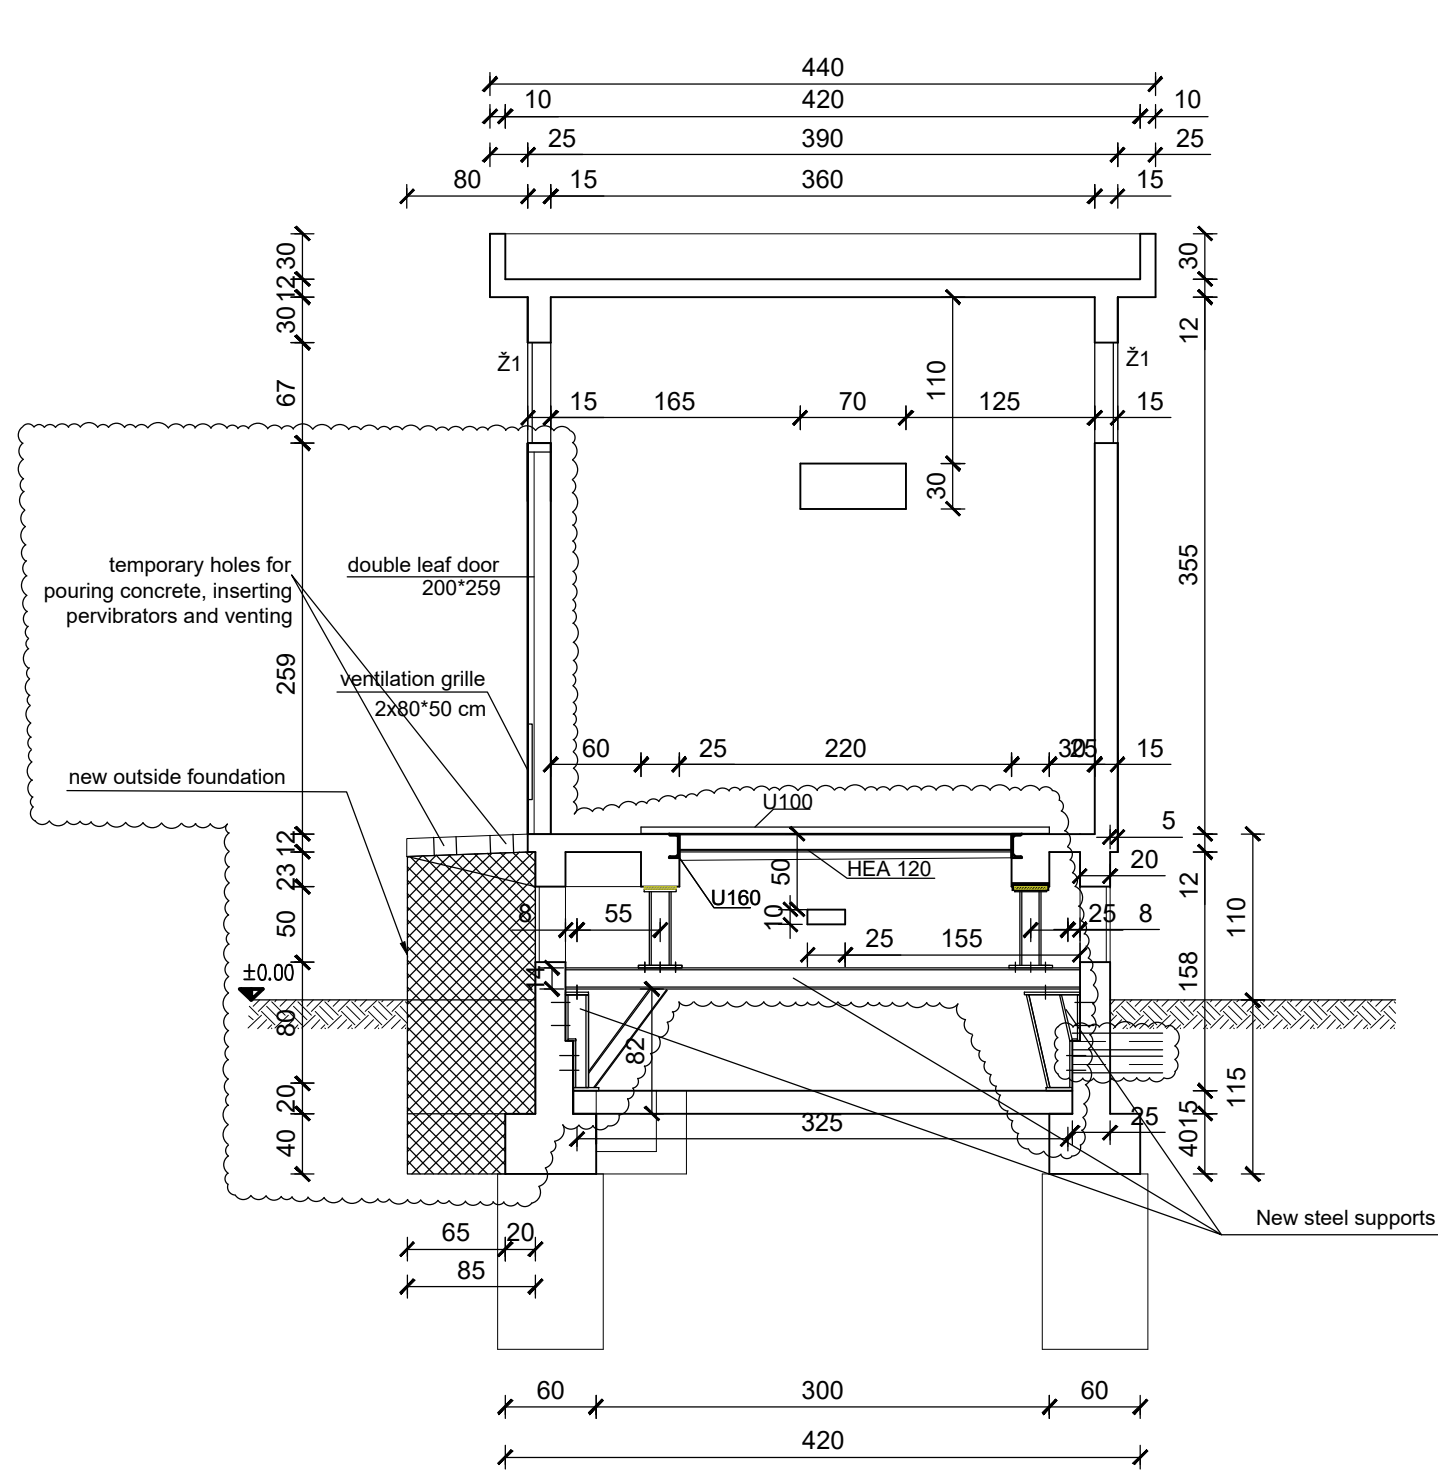

MOD: 1345-EE-L NEW DRAWING H2.2-20

1. Interim Dwg. No.:	C-436-028-0-IA
Interim Sketch No.:	N/A
2. Design Mod. No.:	1345-EE-L
3. Drawing Rev. No.:	-
4. New Drawing No.:	C-436-028
5. Resp. Eng.:	R. SPIONJAK Date: 05. 2025.
6. Checker:	B. LALATOVIĆ Date: 05. 2025.

Original Design Firm: EKONERG
Replaced Manual Drawing: N/A
Last Revision And Date: 0. 07. 2025.

THIS IS A CAD DRAWING AND SHOULD NOT BE REVISED OR MODIFIED MANUALLY				REFERENCE DRAWINGS			
1.	2.	3.	4.	1.	2.	3.	4.
R. SPIONJAK	D. VUKAS	J. KERIN					
SCALE 1:50				DRAWING NUMBER			
0	07.2025	EKO	ISSUED PER MOD 1345-EE-L	D.V.	J.K.		
NO.	DATE	BY	REVISION	CHKD. BY	LE APPR.		

NUKLEARNA ELEKTRARNA KRSKO NUCLEAR POWER PLANT KRSKO	
Transformer station	
TP1	
Floor plans and cross-sections	
DESIGN ENGINEERING	
MADE	CHECKED
1. R. SPIONJAK	2. D. VUKAS
3. J. KERIN	
C-436-028	
DRAWING NUMBER	
SYSTEM	
SH.NO.	
REV.	