

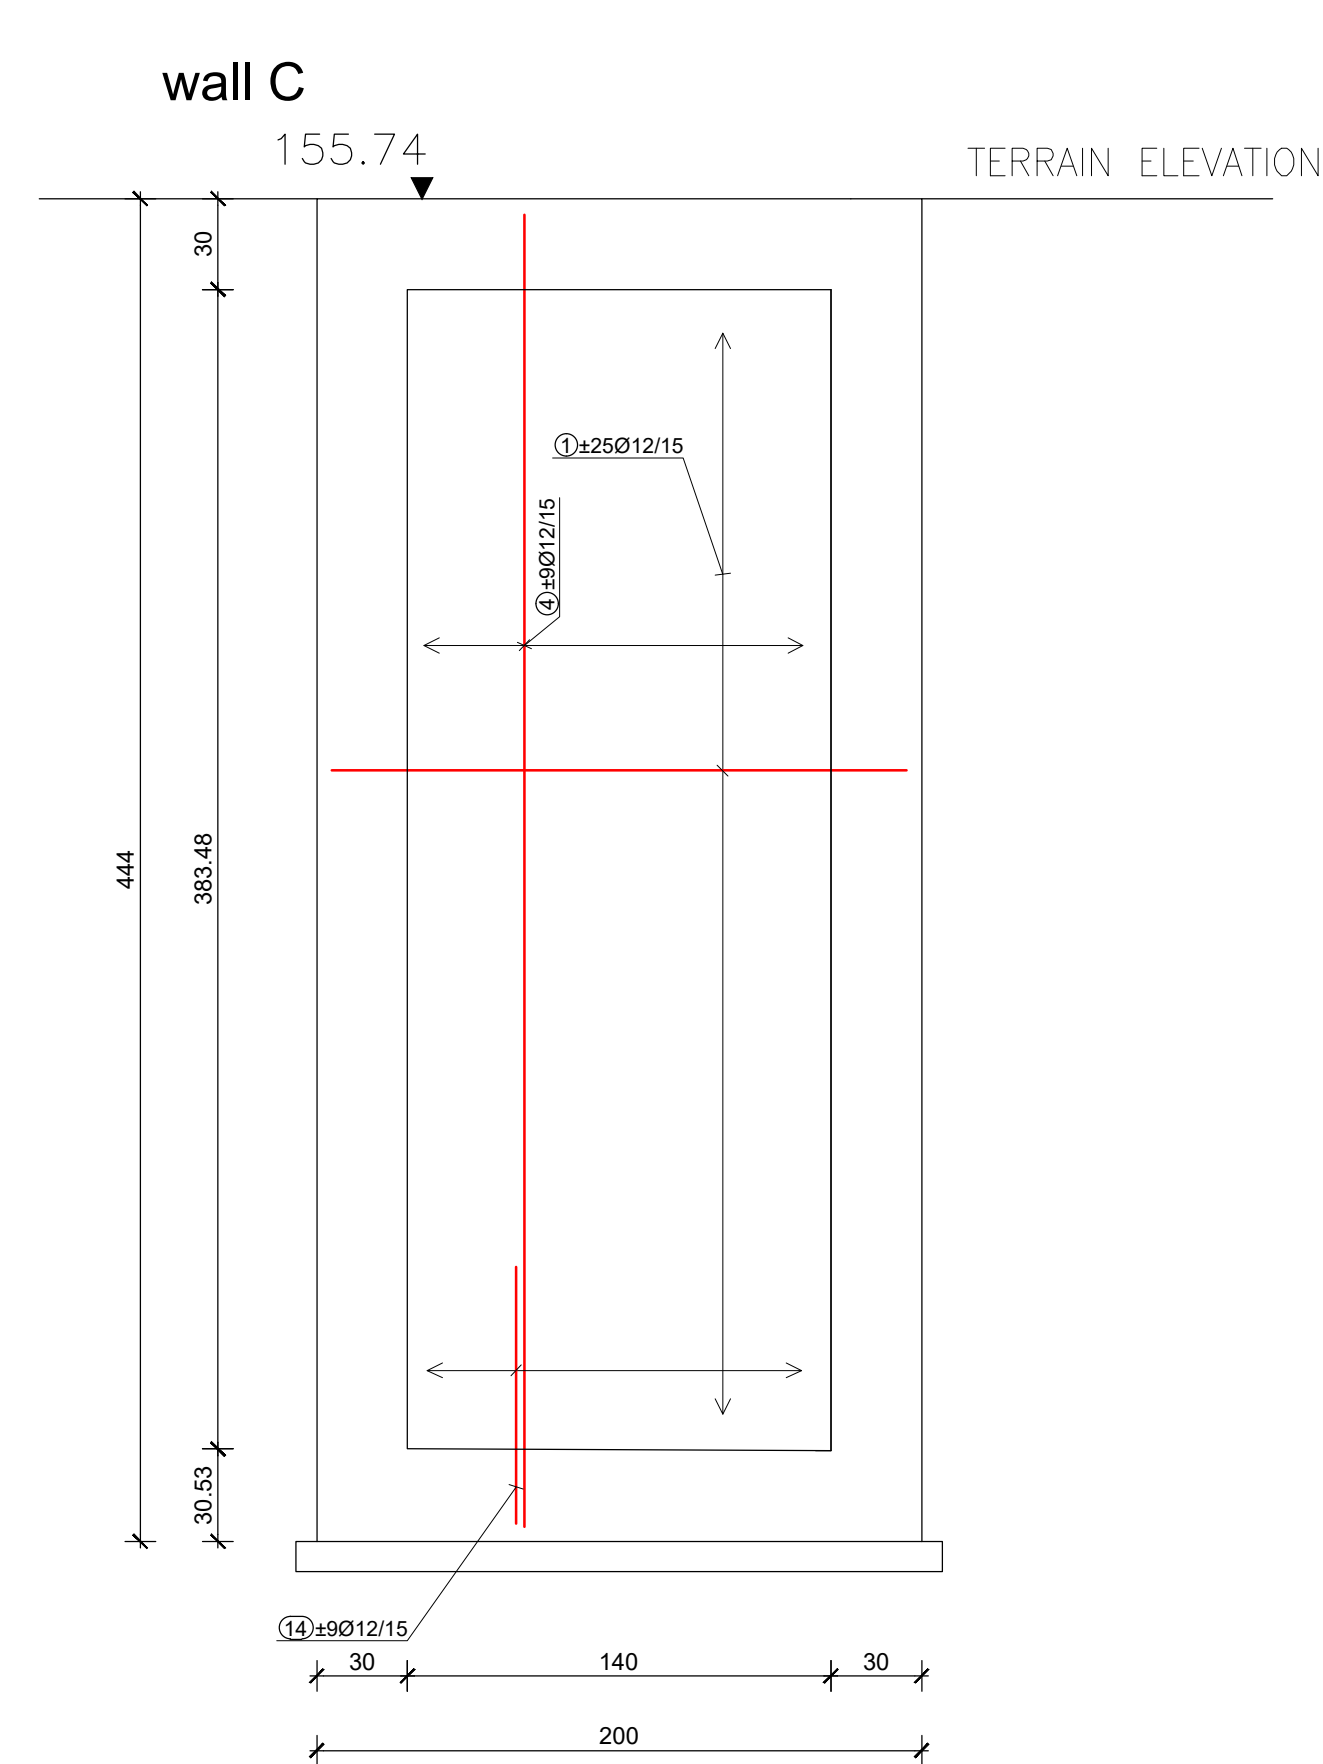
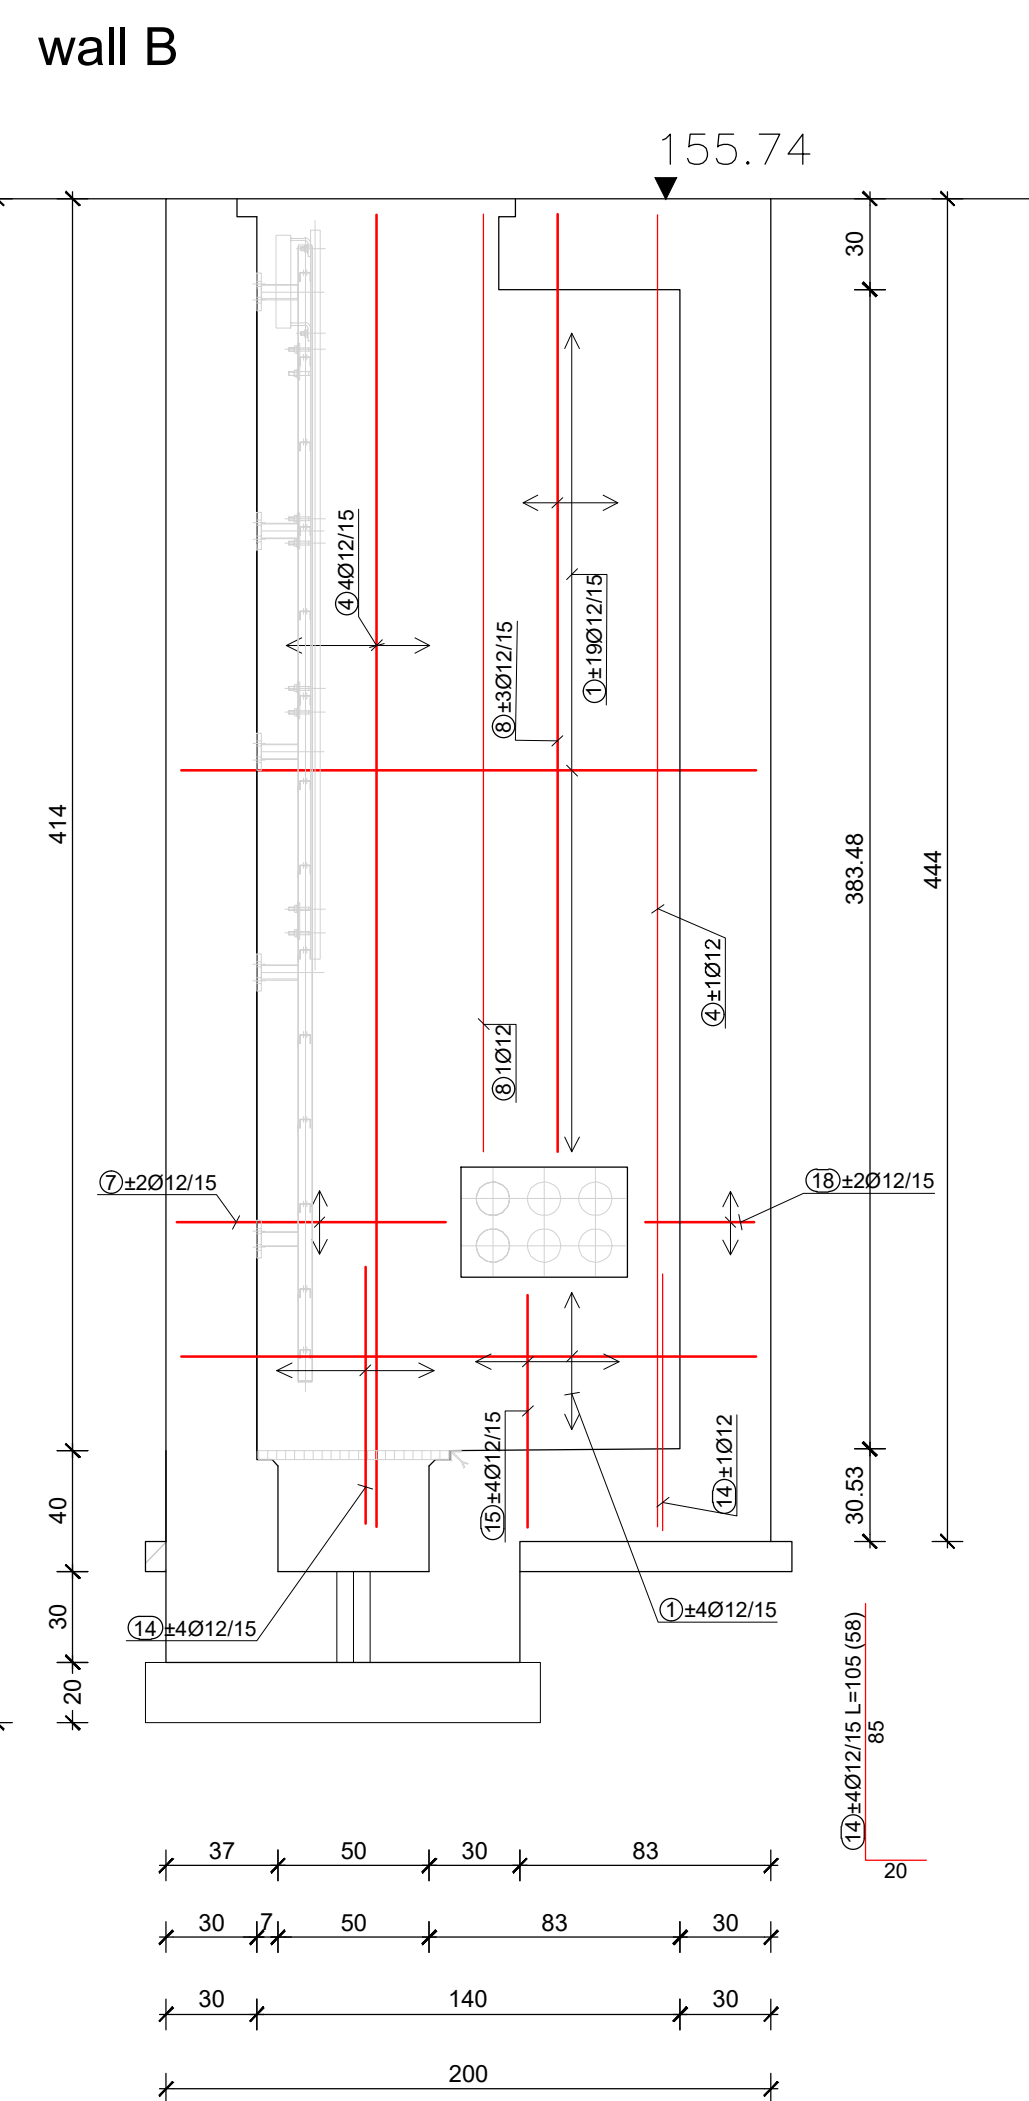
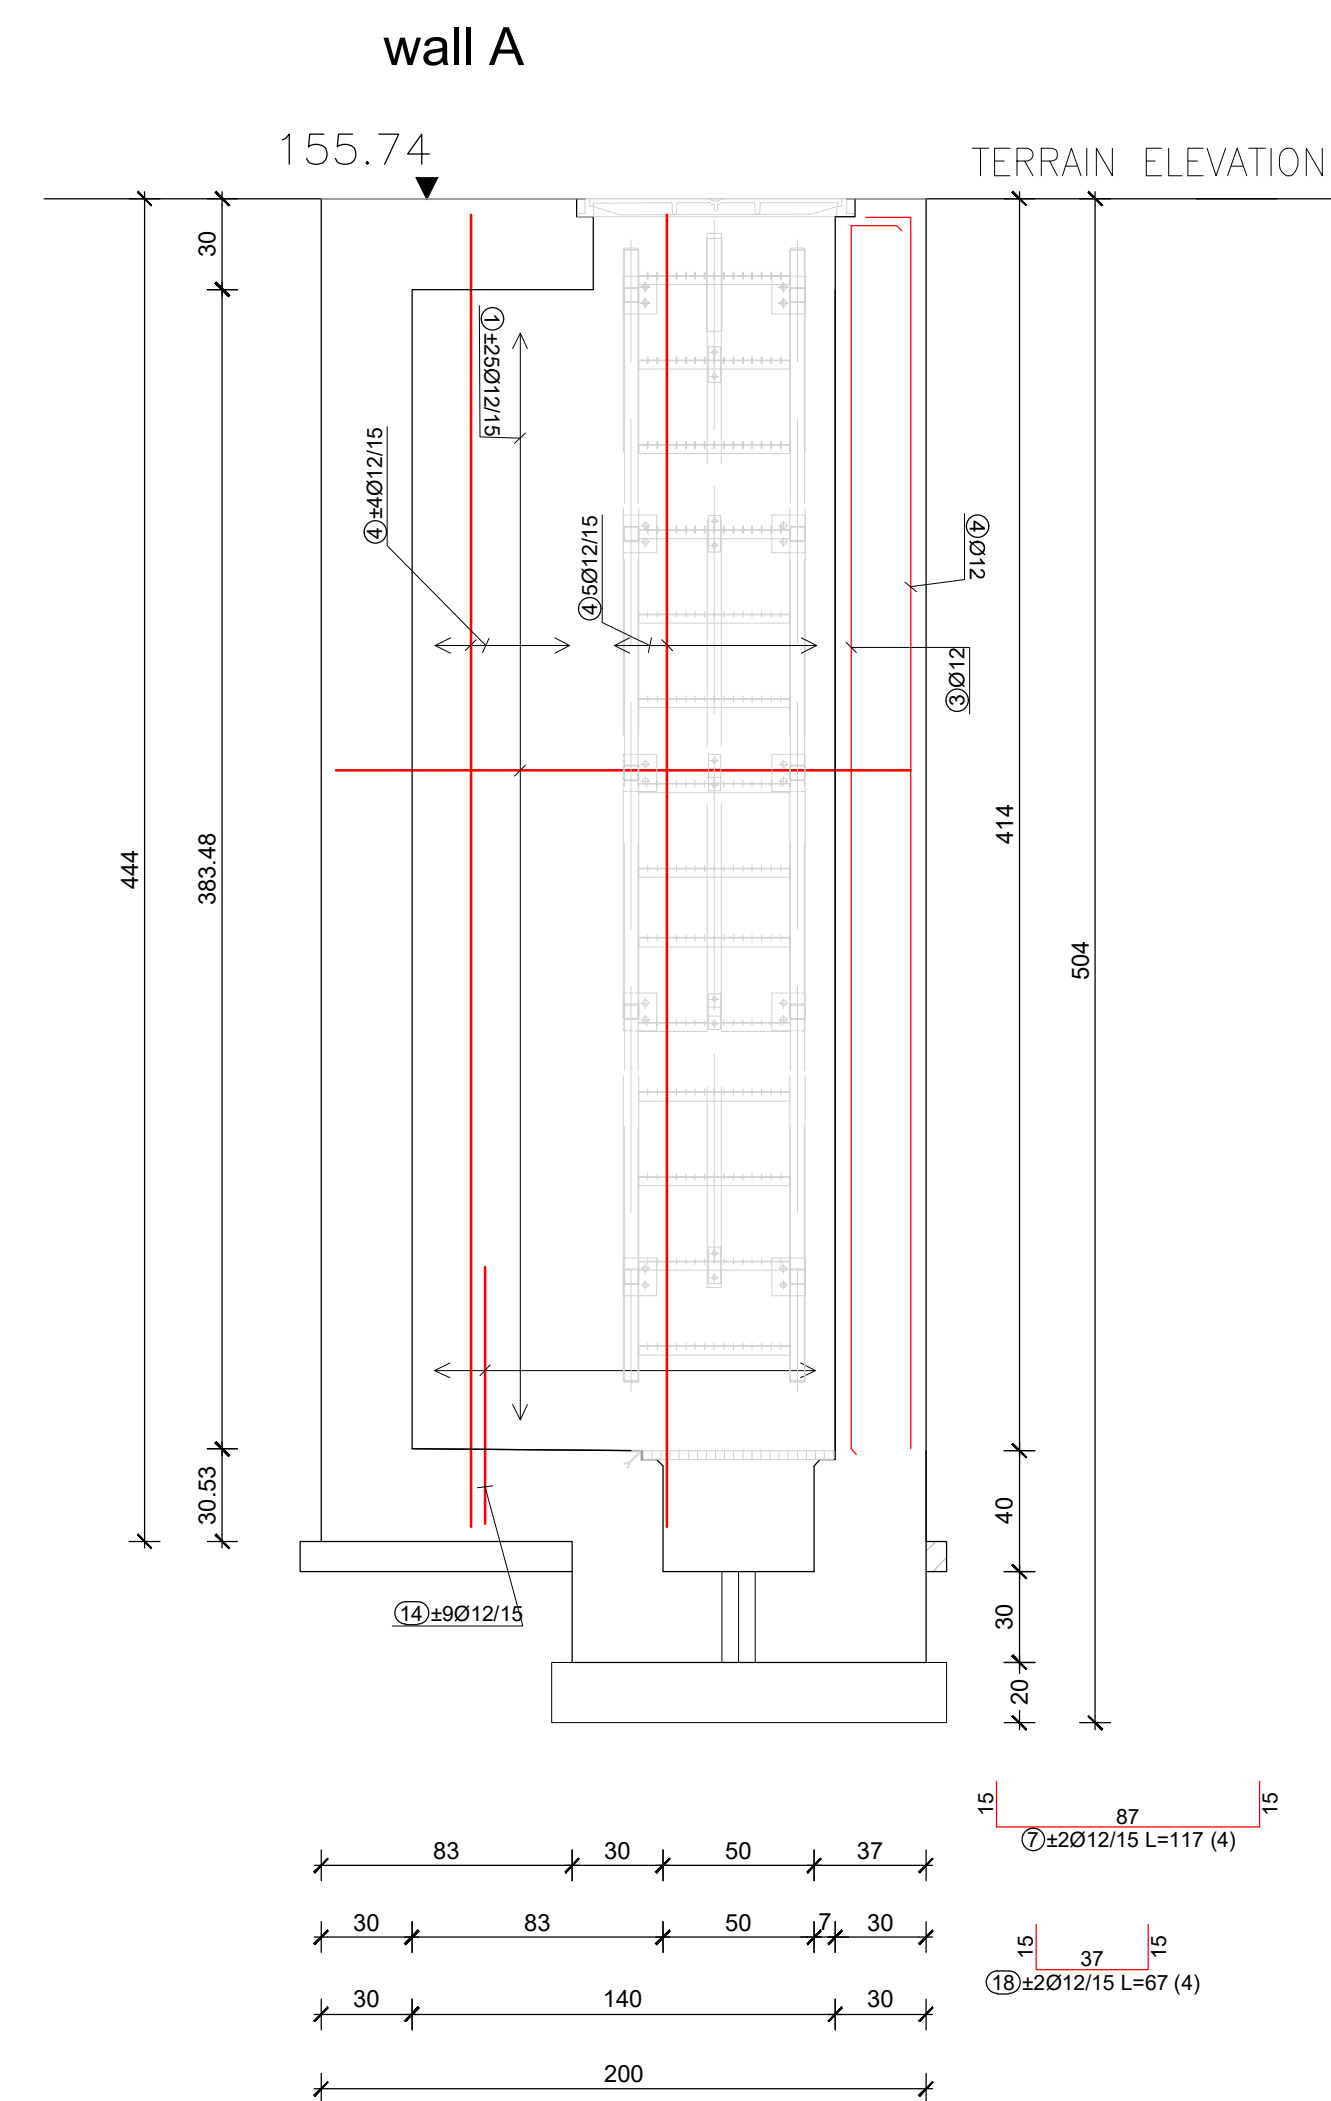
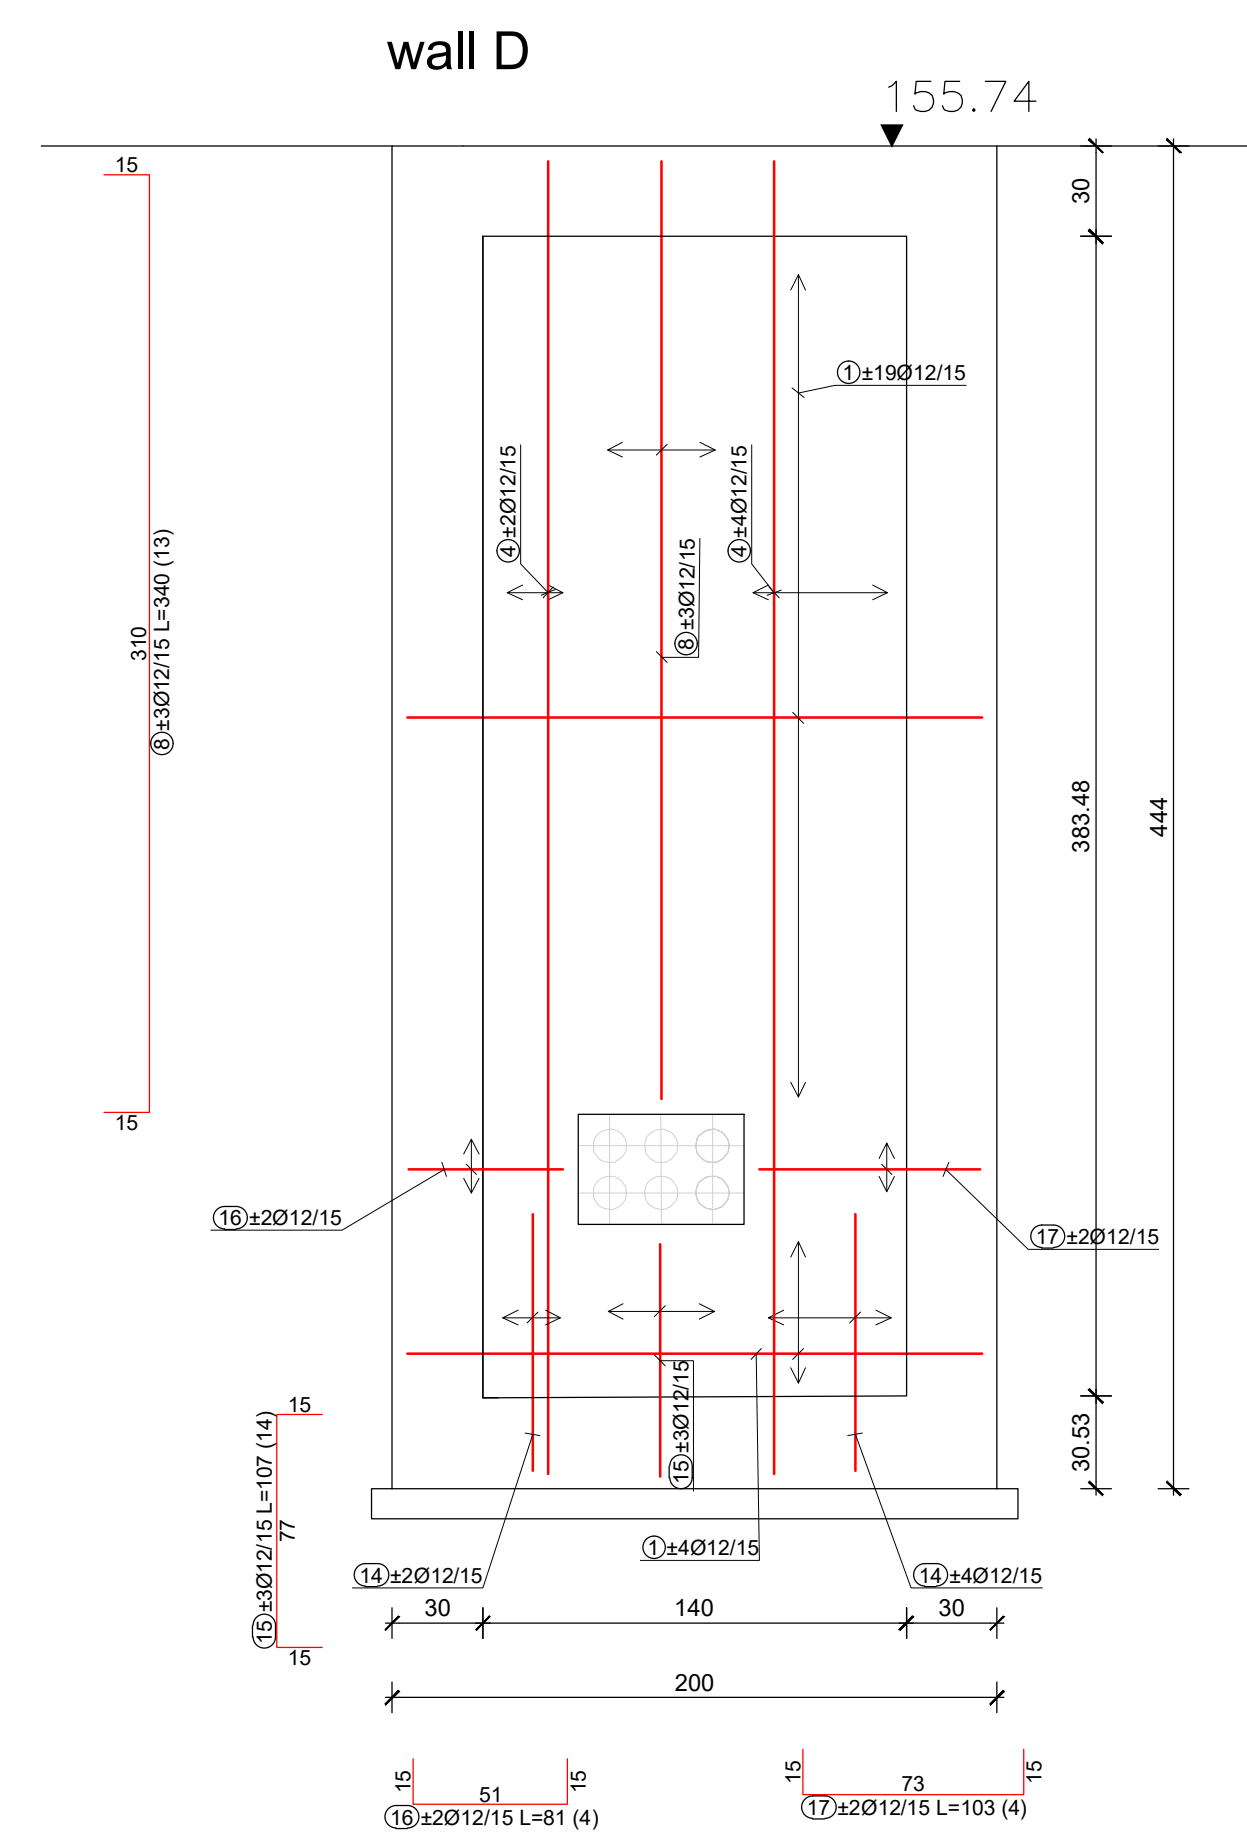
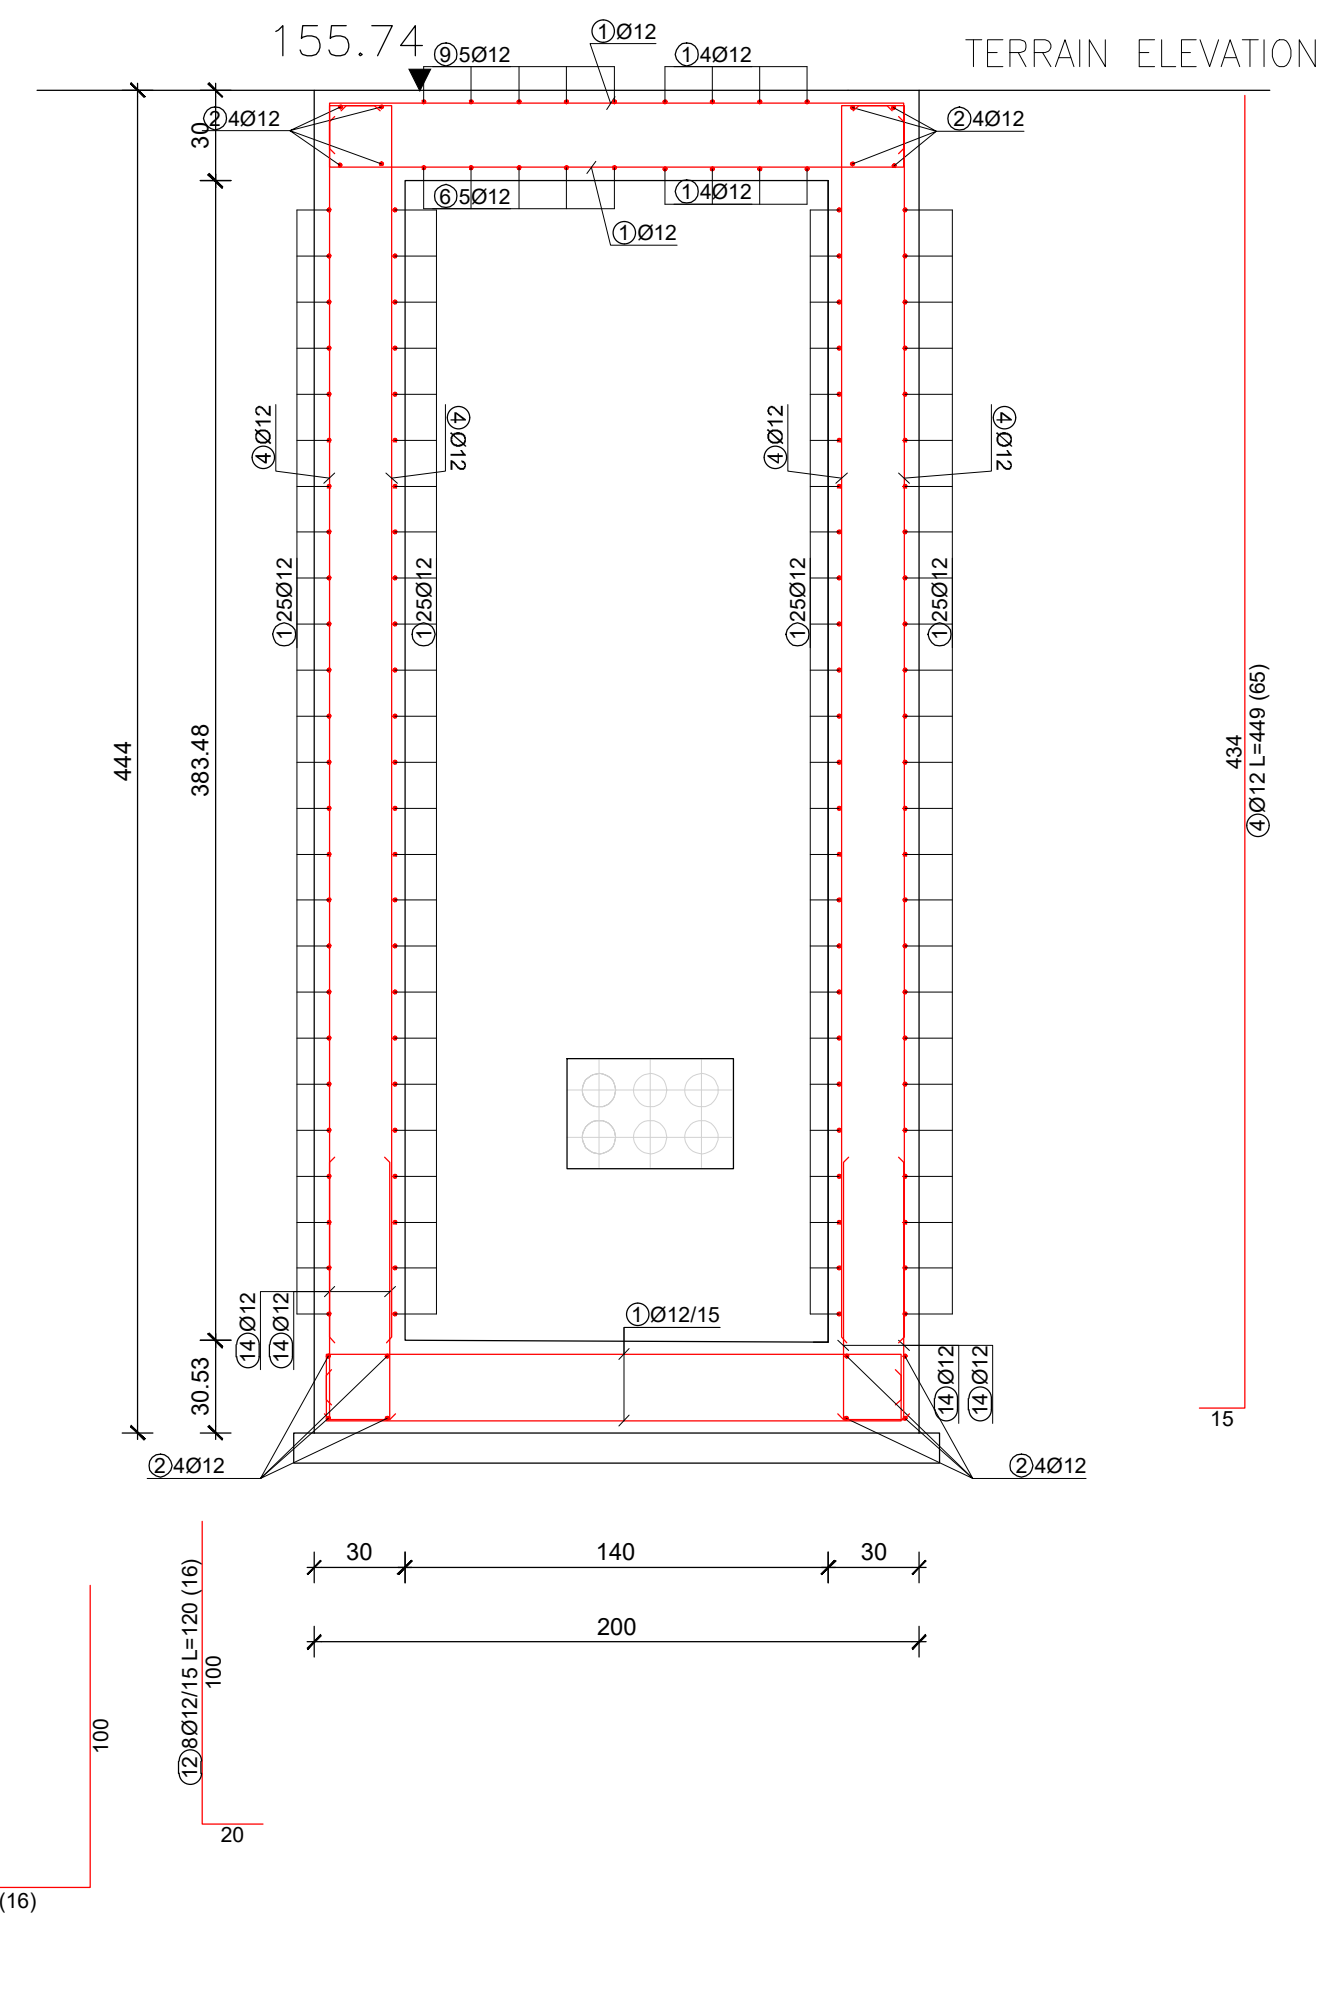
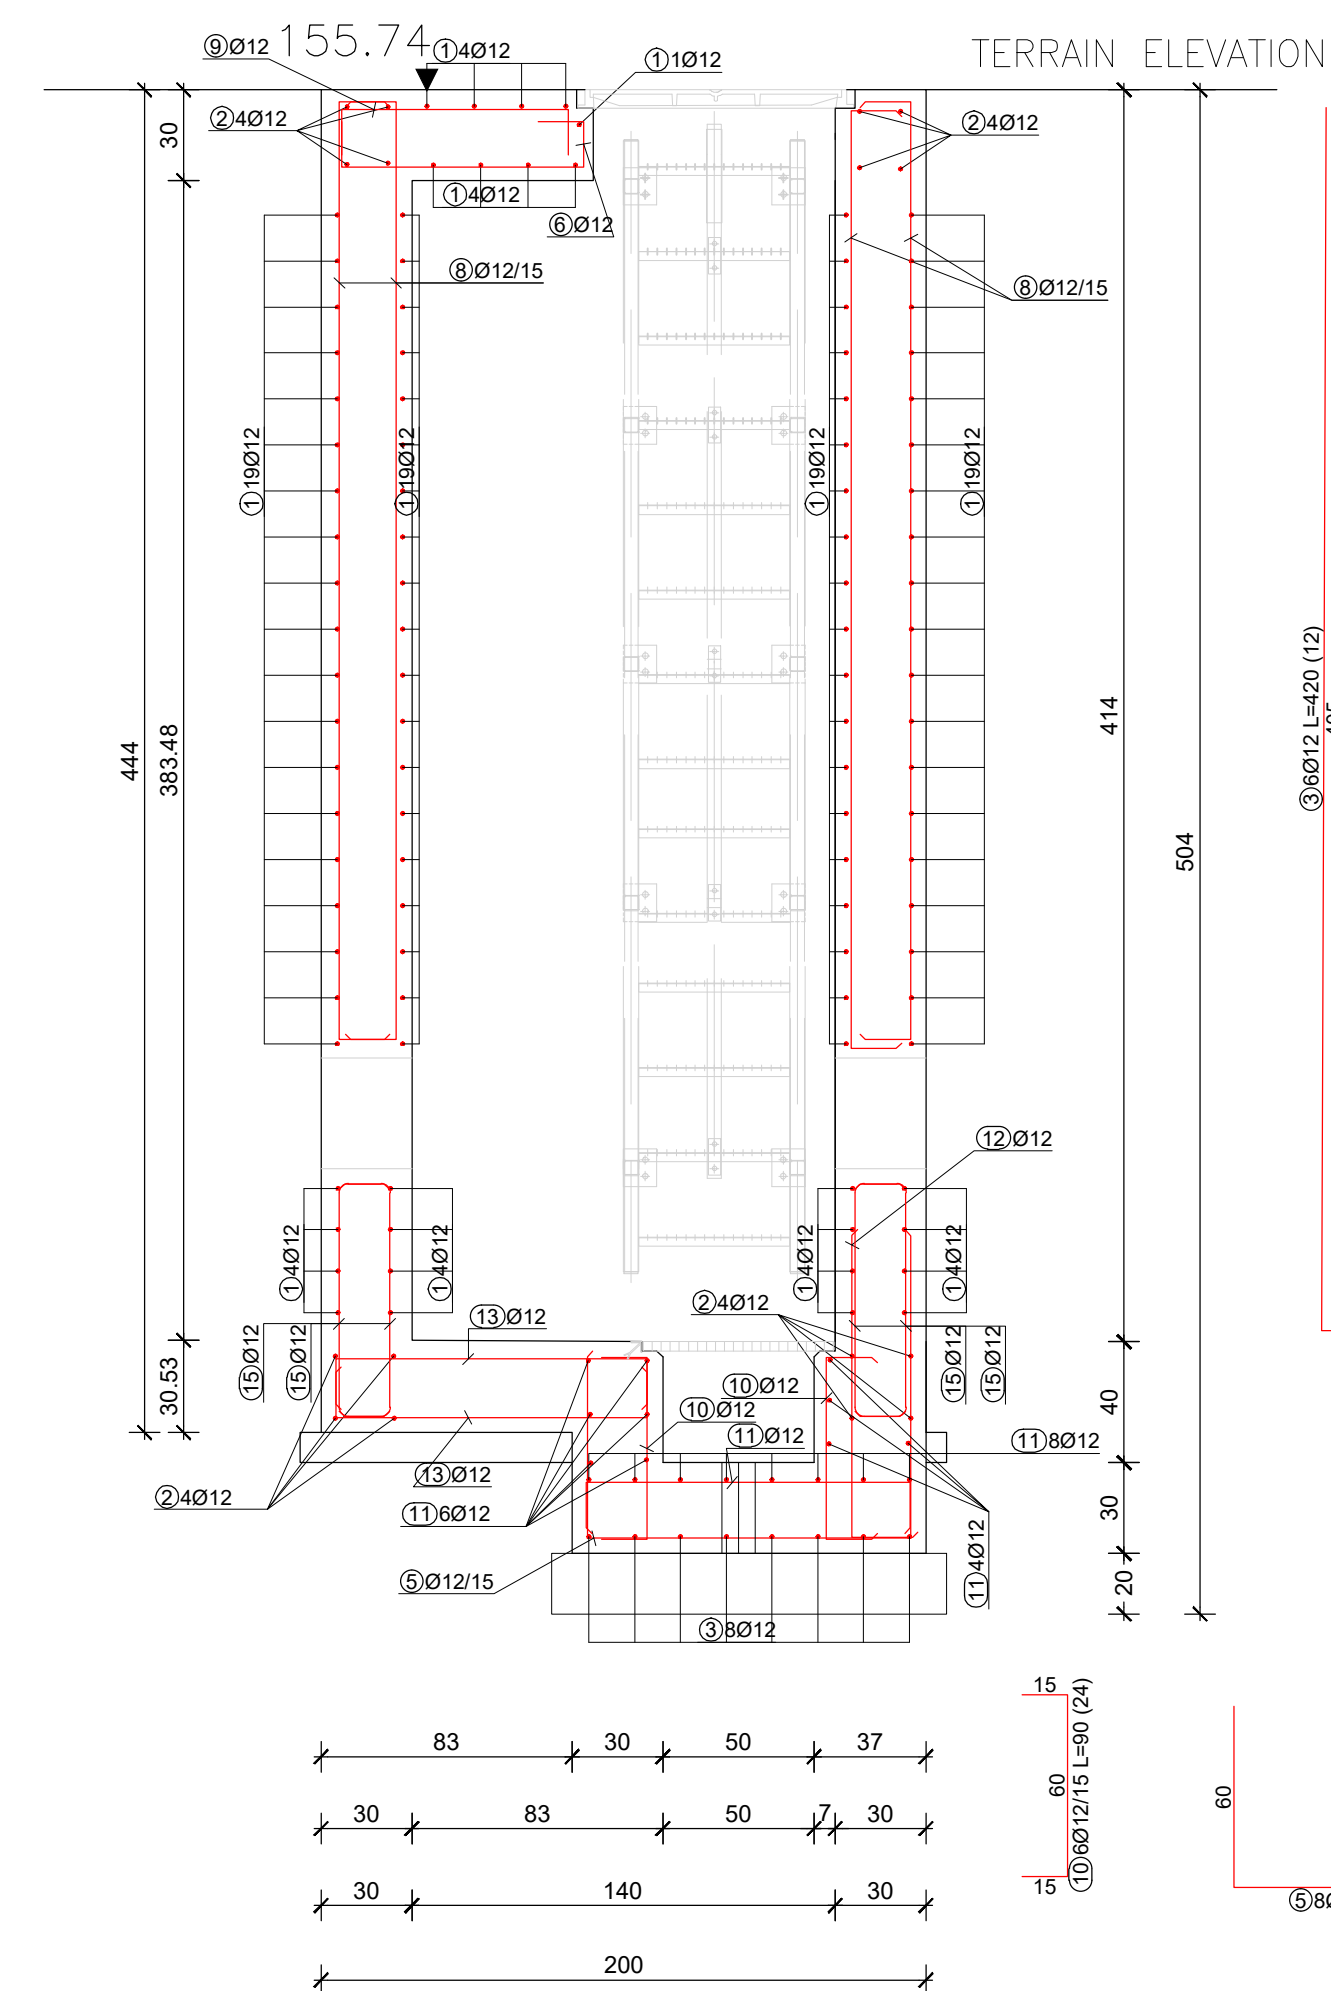
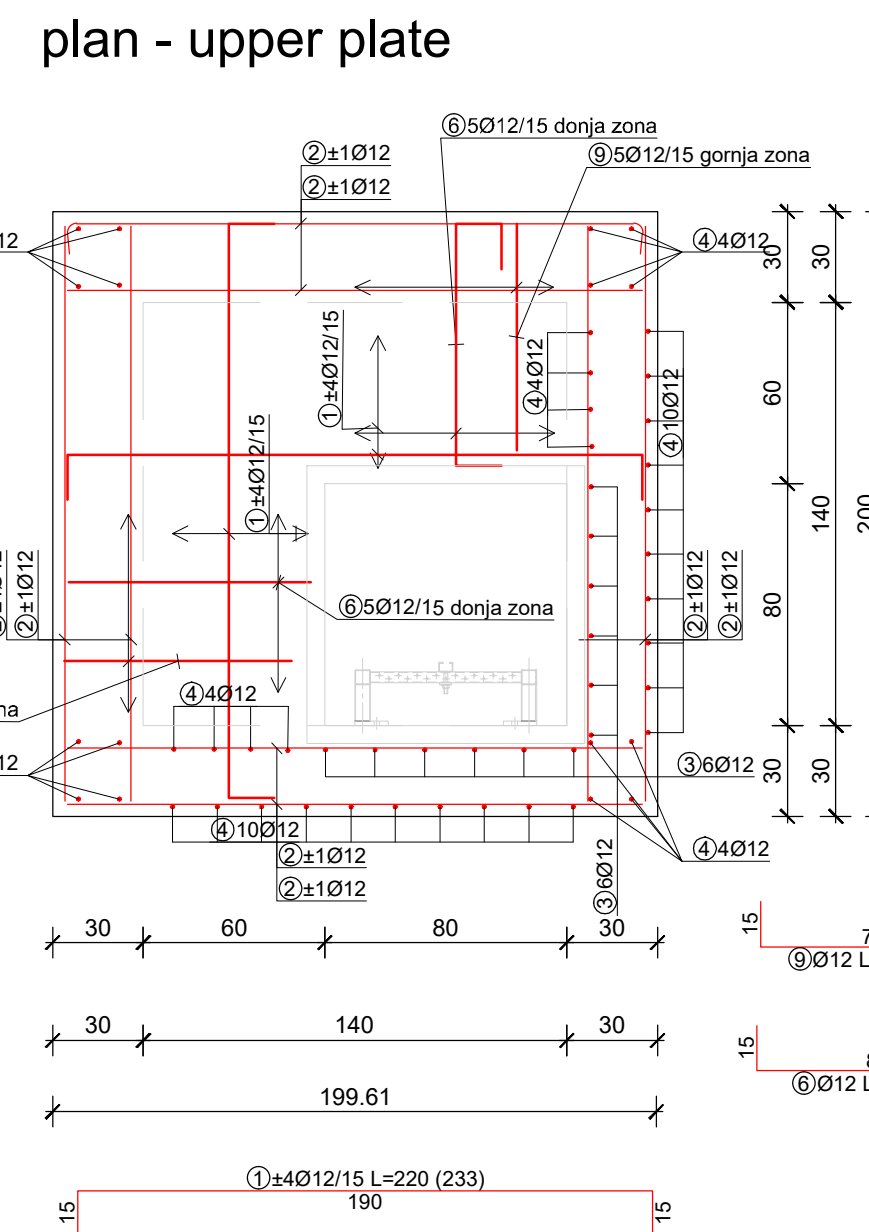
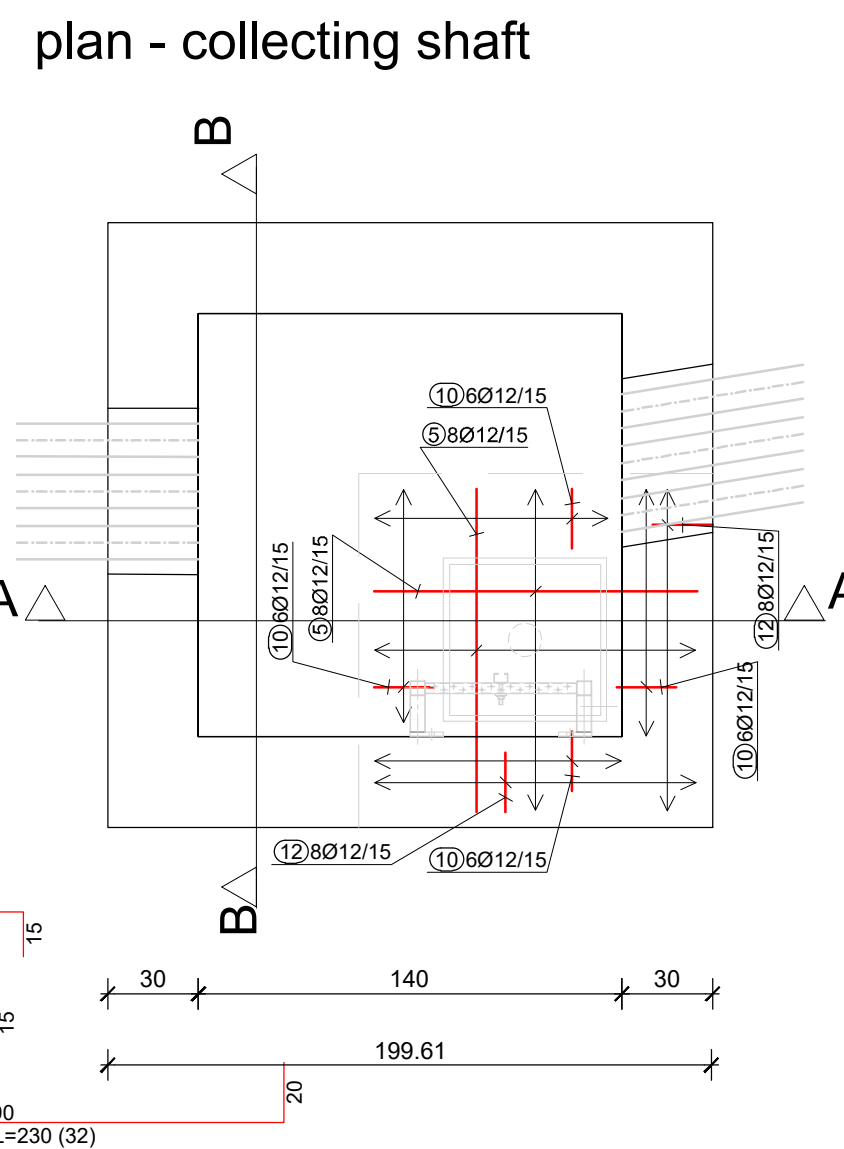


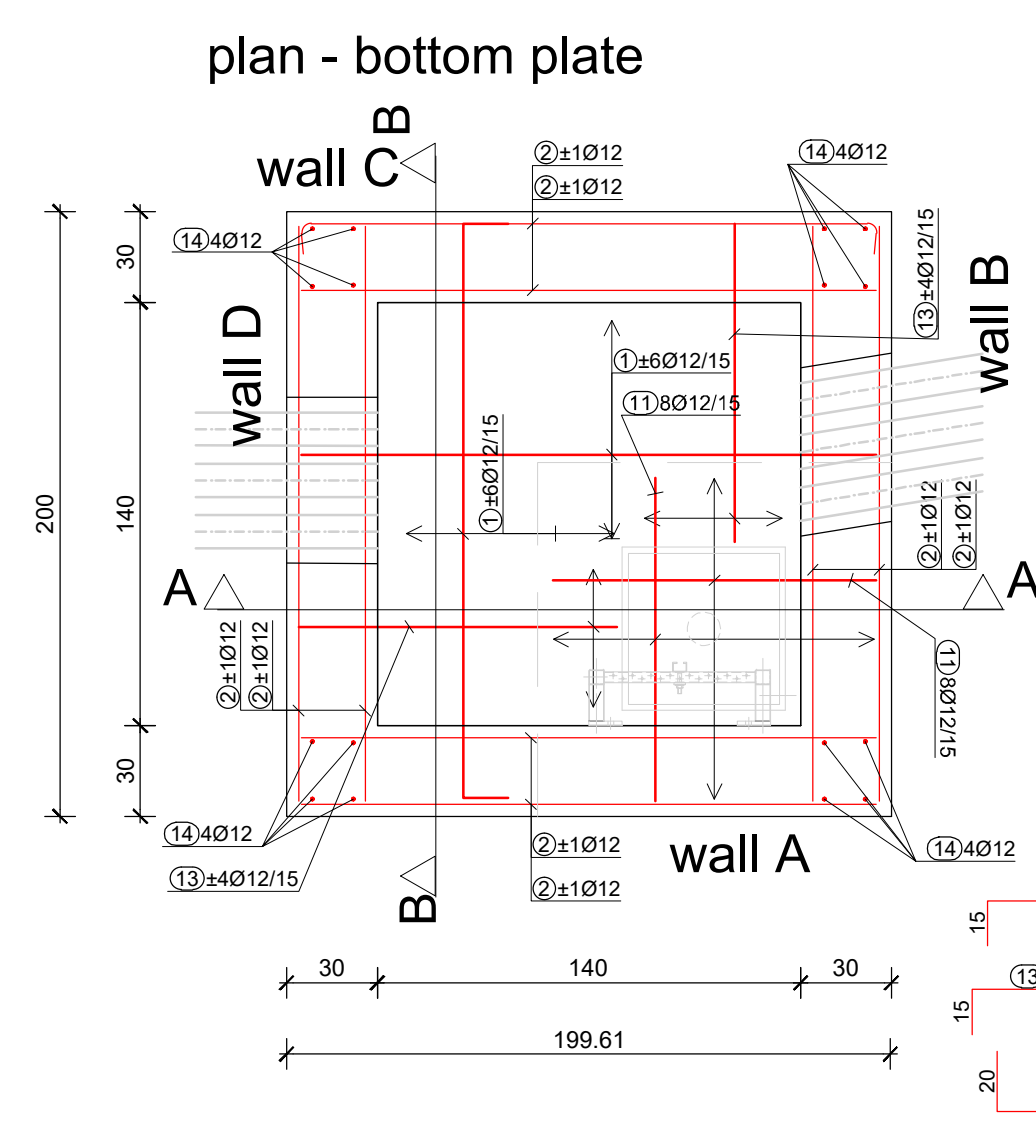

Palice - specifikacija						
POZ	oblika in mere [mm]	Ø	pos. dolžina [m]	n [kos]	skupna dolžina [m]	
KABELSKU JAŠEK JE 156 (1 pcs.)						
1		12	2.20	233	512.6	
2		12	2.30	32	73.6	
3		12	4.20	12	50.4	
4		12	4.49	65	291.6	
5		12	2.67	16	42.7	
6		12	1.25	10	12.5	
7		12	1.17	4	4.7	
8		12	3.40	13	44.2	
9		12	1.05	10	10.5	
10		12	0.90	24	21.6	
11		12	1.37	36	49.3	
12		12	1.20	16	19.2	
13		12	1.33	16	21.3	
14		12	1.05	58	60.9	
15		12	1.07	14	14.8	
16		12	0.81	4	3.2	
17		12	1.03	4	4.1	
18		12	0.67	4	2.7	
Palice - izvedek						
Ø [mm]	Skupna dolžina [m]		Teža enote [kg/m²]		Skupna teža [kg]	
B500B, Ø <= 12 mm						
12	1240.37		0.89		1101.1	
Skupaj (B500B, Ø <= 12 mm)					1101.1	
Skupaj					1101.1	

Shaft wall penetration detail

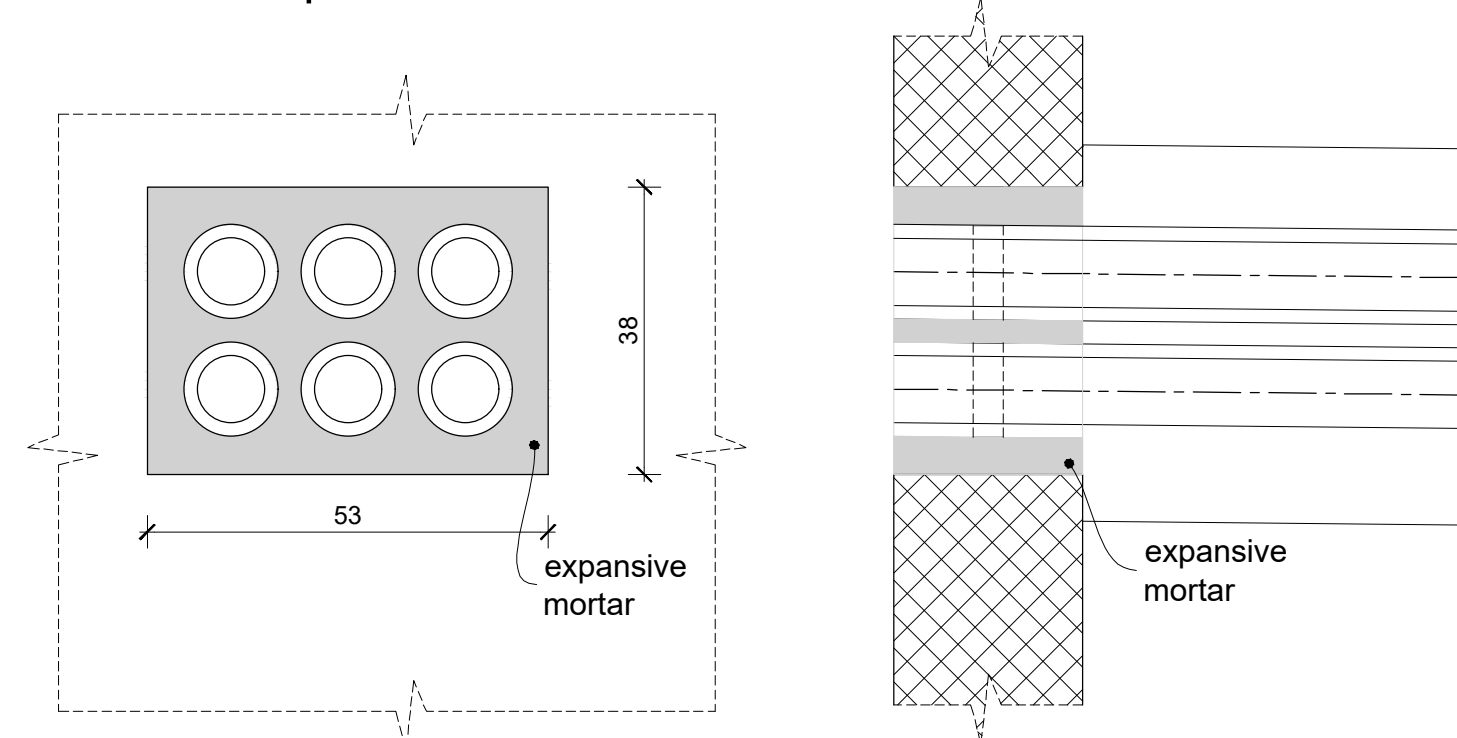

NOTES:

1. MATERIAL:
CONCRETE ACC. TO SIST EN 206, SIST 1026, SIST EN 1992-1-1
- construction concrete: C30/37 XC4/XF3 Cl 0,2 Dmax16
- concrete cover: min 4 cm
- lean concrete C12/15 X0
- execution class 2, tolerance class 1 acc. to SIST EN
13670 and national annex

REINFORCEMENT B500B ACC. TO SIST EN 10080, SIST EN 1992-1-1

2. CONCRETE SURFACE FINISH TYPE ACC. TO SIST EN 13670
AND NATIONAL ANNEX

FORMED SURFACES:

- UNFORMED SURFACES:
- visible surfaces: simple VB2
 - invisible surface: basic VB0
- UNFORMED STRUCTURES:
- visible surfaces: simple
 - invisible surface: basic

3. ALL DIMENSIONS SHALL BE CHECKED AND ADJUSTED ON SIGHT

		H2.2-14														
<table border="0" style="width: 100%;"> <tr> <td style="width: 50%;">1. Interim Dwg. No.:</td> <td style="width: 50%;">D-436-022-0-IA</td> </tr> <tr> <td>Interim Sketch No.:</td> <td>N/A</td> </tr> <tr> <td>2. Design Mod. No.:</td> <td>1345-EE-L</td> </tr> <tr> <td>3. Drawing. Rev. No.:</td> <td>-</td> </tr> <tr> <td>4. New Drawing. No.:</td> <td>D-436-022</td> </tr> <tr> <td>5. Resp. Eng.: R. ŠPIONJAK</td> <td>Date: 05. 2025.</td> </tr> <tr> <td>6. Checker: B.LALATOVIĆ</td> <td>Date: 05. 2025.</td> </tr> </table>			1. Interim Dwg. No.:	D-436-022-0-IA	Interim Sketch No.:	N/A	2. Design Mod. No.:	1345-EE-L	3. Drawing. Rev. No.:	-	4. New Drawing. No.:	D-436-022	5. Resp. Eng.: R. ŠPIONJAK	Date: 05. 2025.	6. Checker: B.LALATOVIĆ	Date: 05. 2025.
1. Interim Dwg. No.:	D-436-022-0-IA															
Interim Sketch No.:	N/A															
2. Design Mod. No.:	1345-EE-L															
3. Drawing. Rev. No.:	-															
4. New Drawing. No.:	D-436-022															
5. Resp. Eng.: R. ŠPIONJAK	Date: 05. 2025.															
6. Checker: B.LALATOVIĆ	Date: 05. 2025.															

NUKLEARNA ELEKTRARNA KRSKO				
NUCLEAR POWER PLANT KRSKO				
Steel reinforcement layout for electrcital manhole JE158				
		DESIGN ENGINEERING		
NUCLEAR POWER PLANT KRSKO		KRSKO, SLOVENIA		
MADE	CHECKED	LE APPROVAL		
1. R.ŠPIONJAK	2. D. VUKAS	3. J. KERIN		
REFERENCE DRAWINGS:				
SCALE	D-436-022			0
1:25	DRAWING NUMBER		SYSTEM	SH.NO. REV.

Original Design Firm:	EKONERG
Replaced Manual Drawing:	N/A
Last Revision And Date:	0, 07.2025

THIS IS A CAD DRAWING AND SHOULD NOT BE REVISED OR MODIFIED MANUALLY

0	07.2025	EKO	ISSUED PER MOD 1345--EE--L	D.V.	J.K.
NO.	DATE	BY	REVISION	CKD BY	ILE APPR