

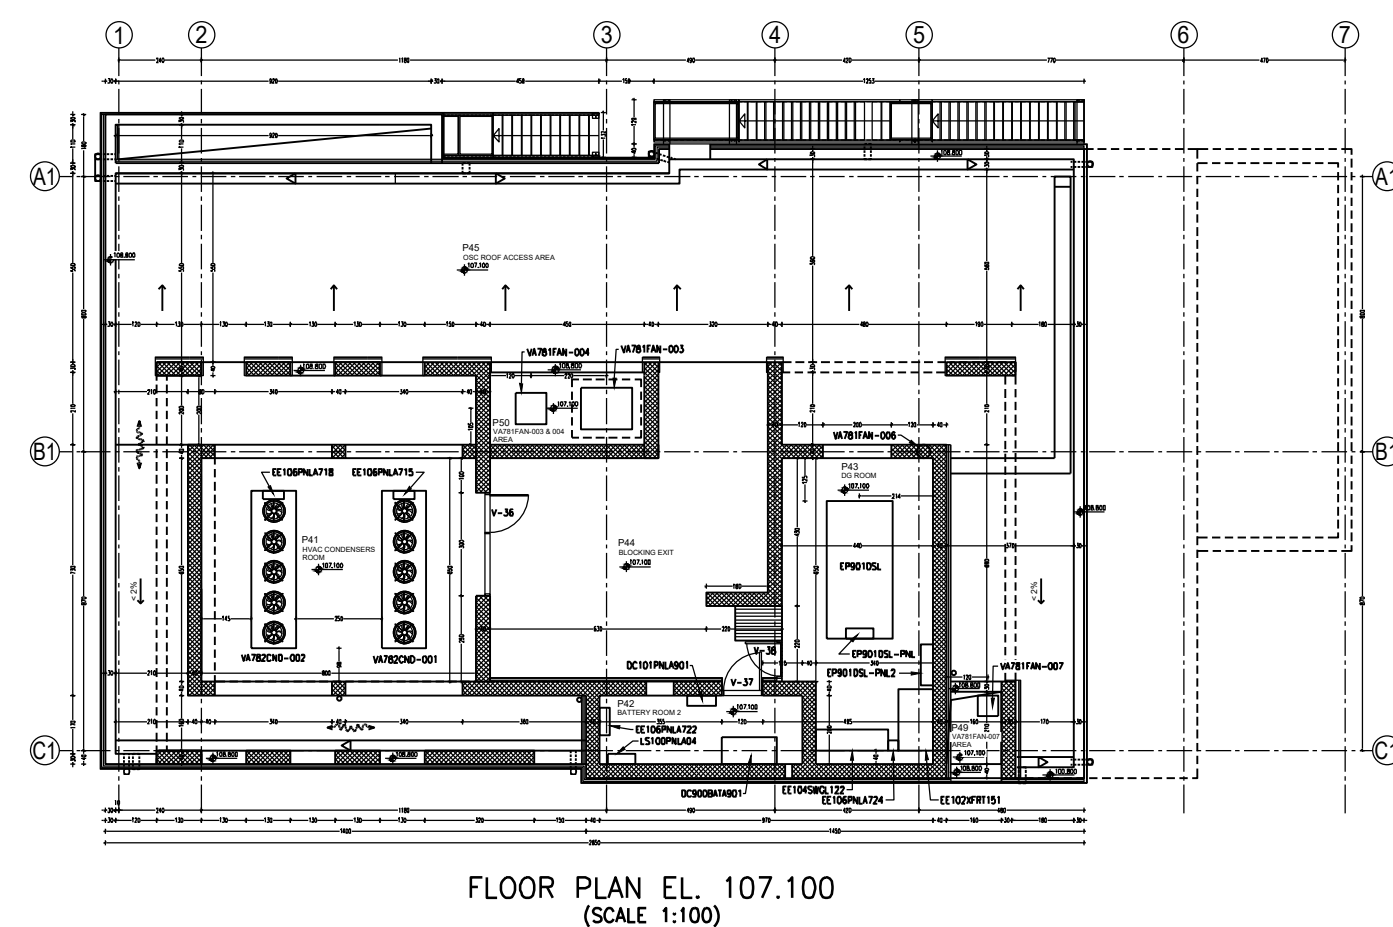
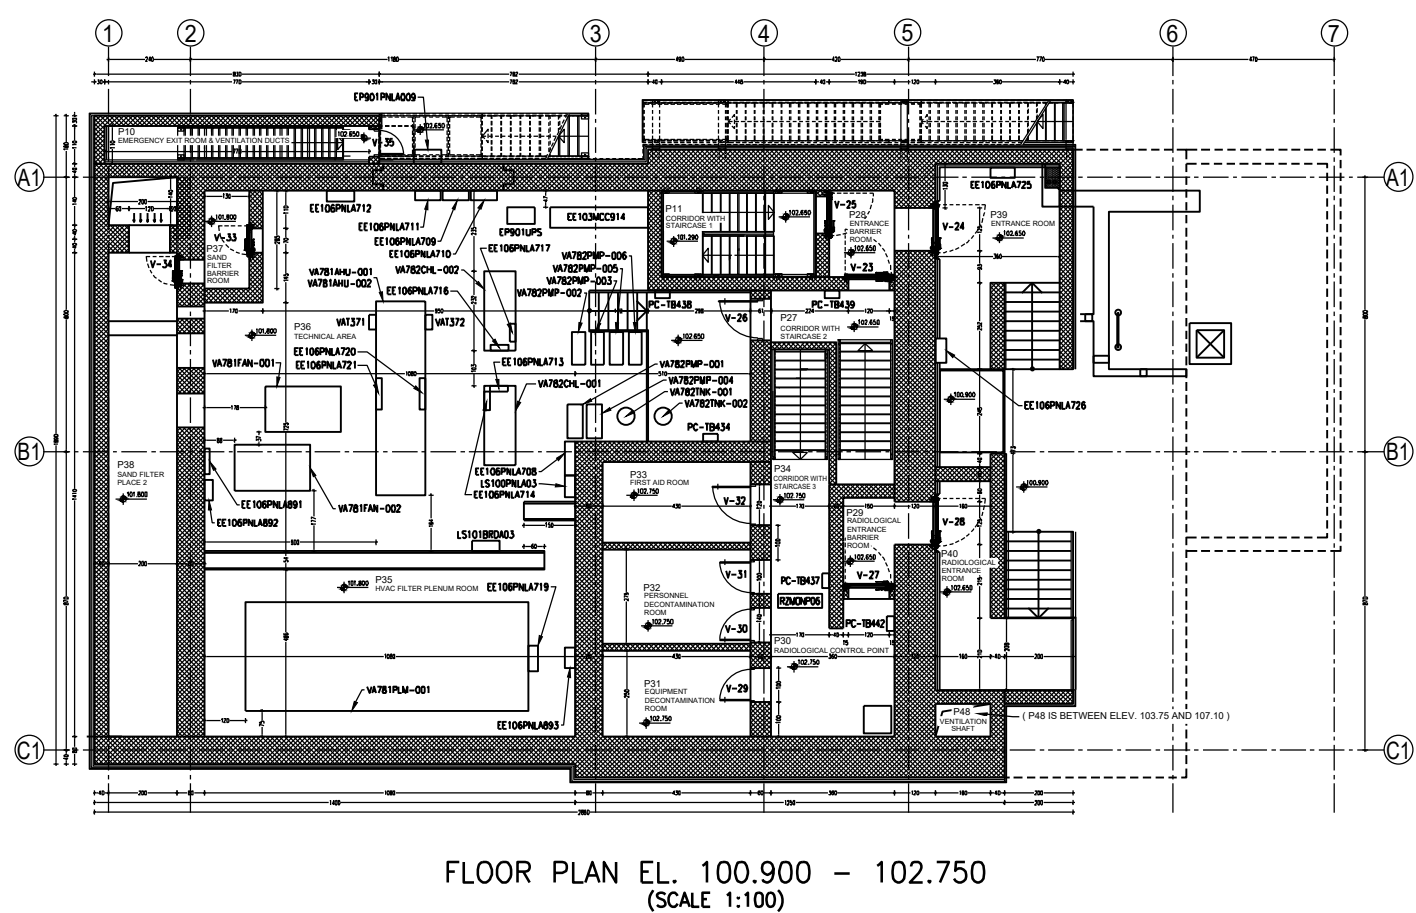
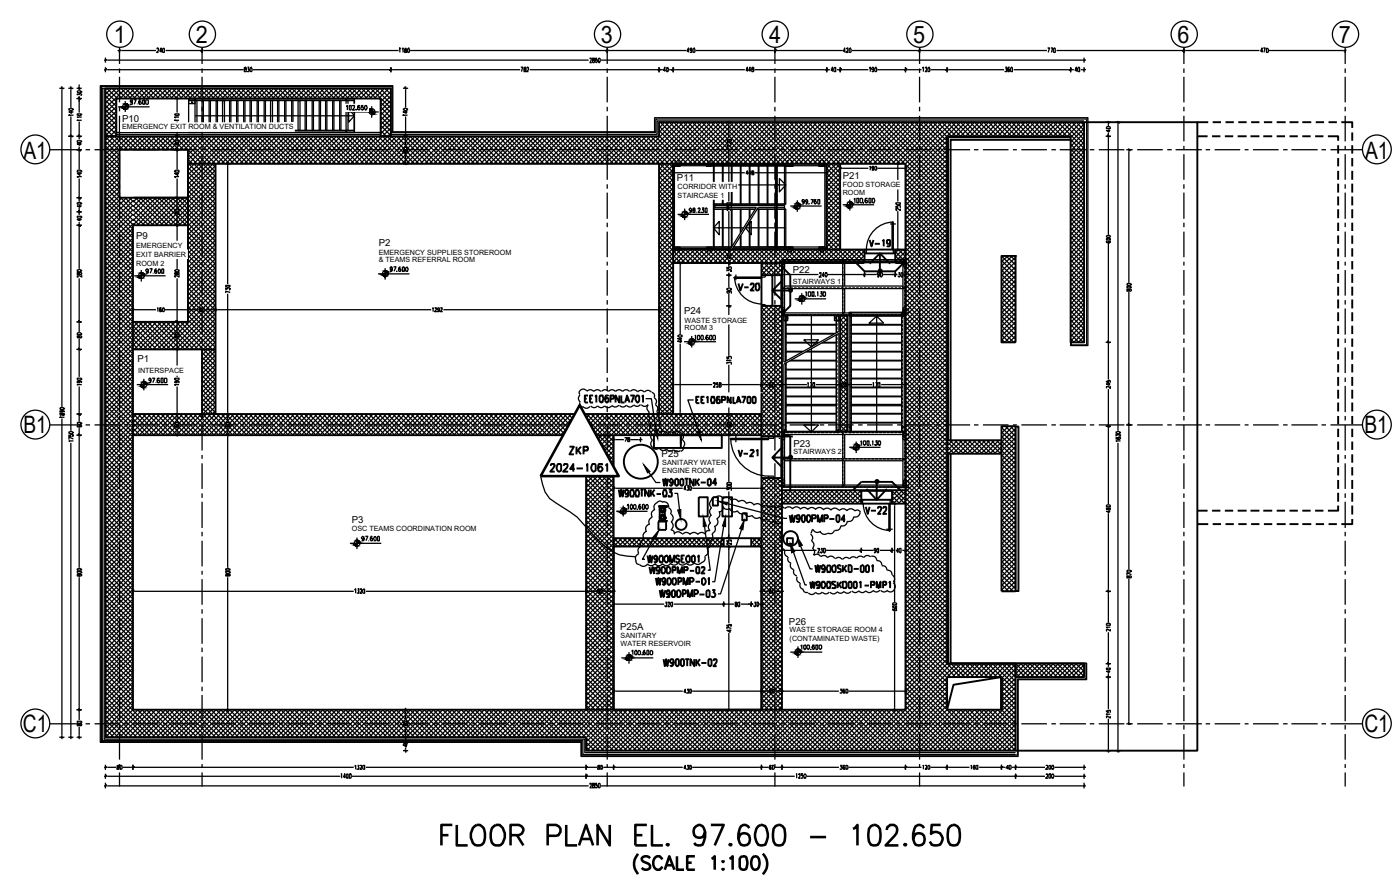
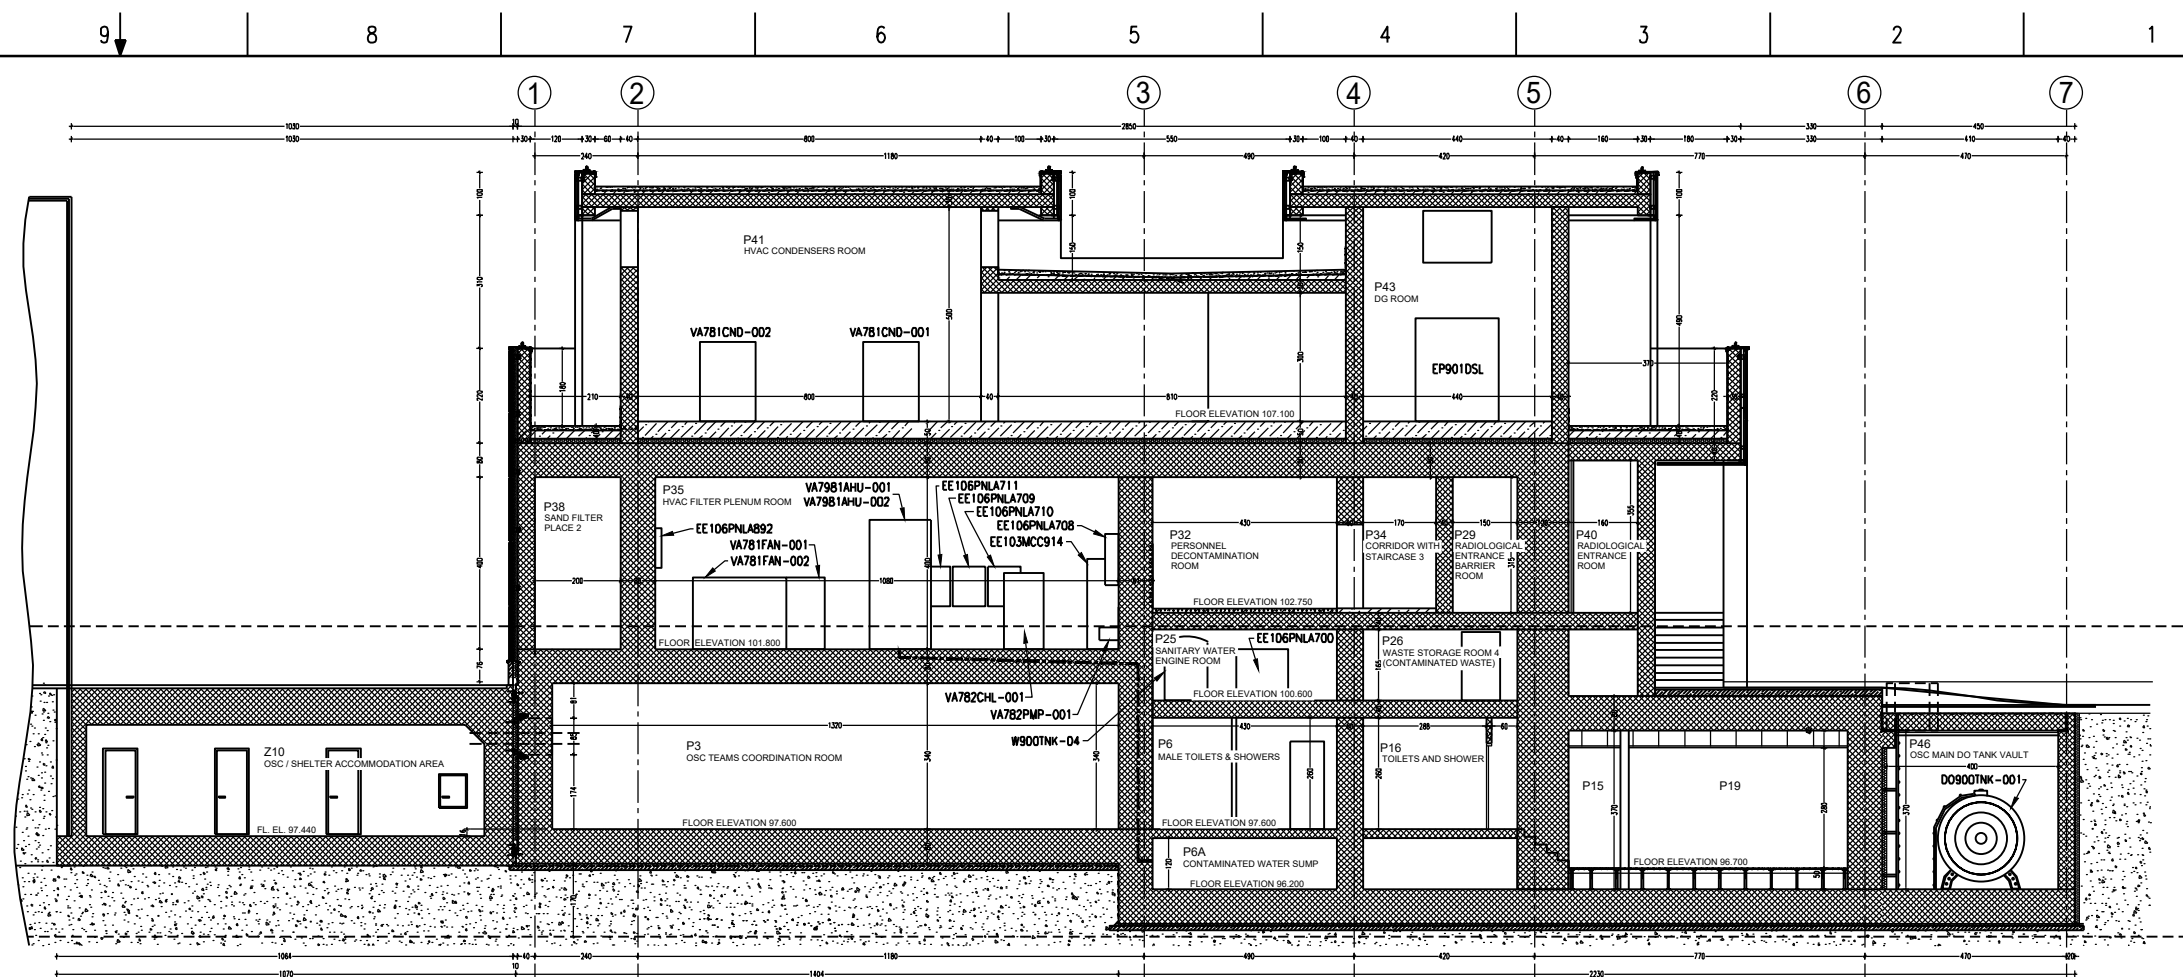
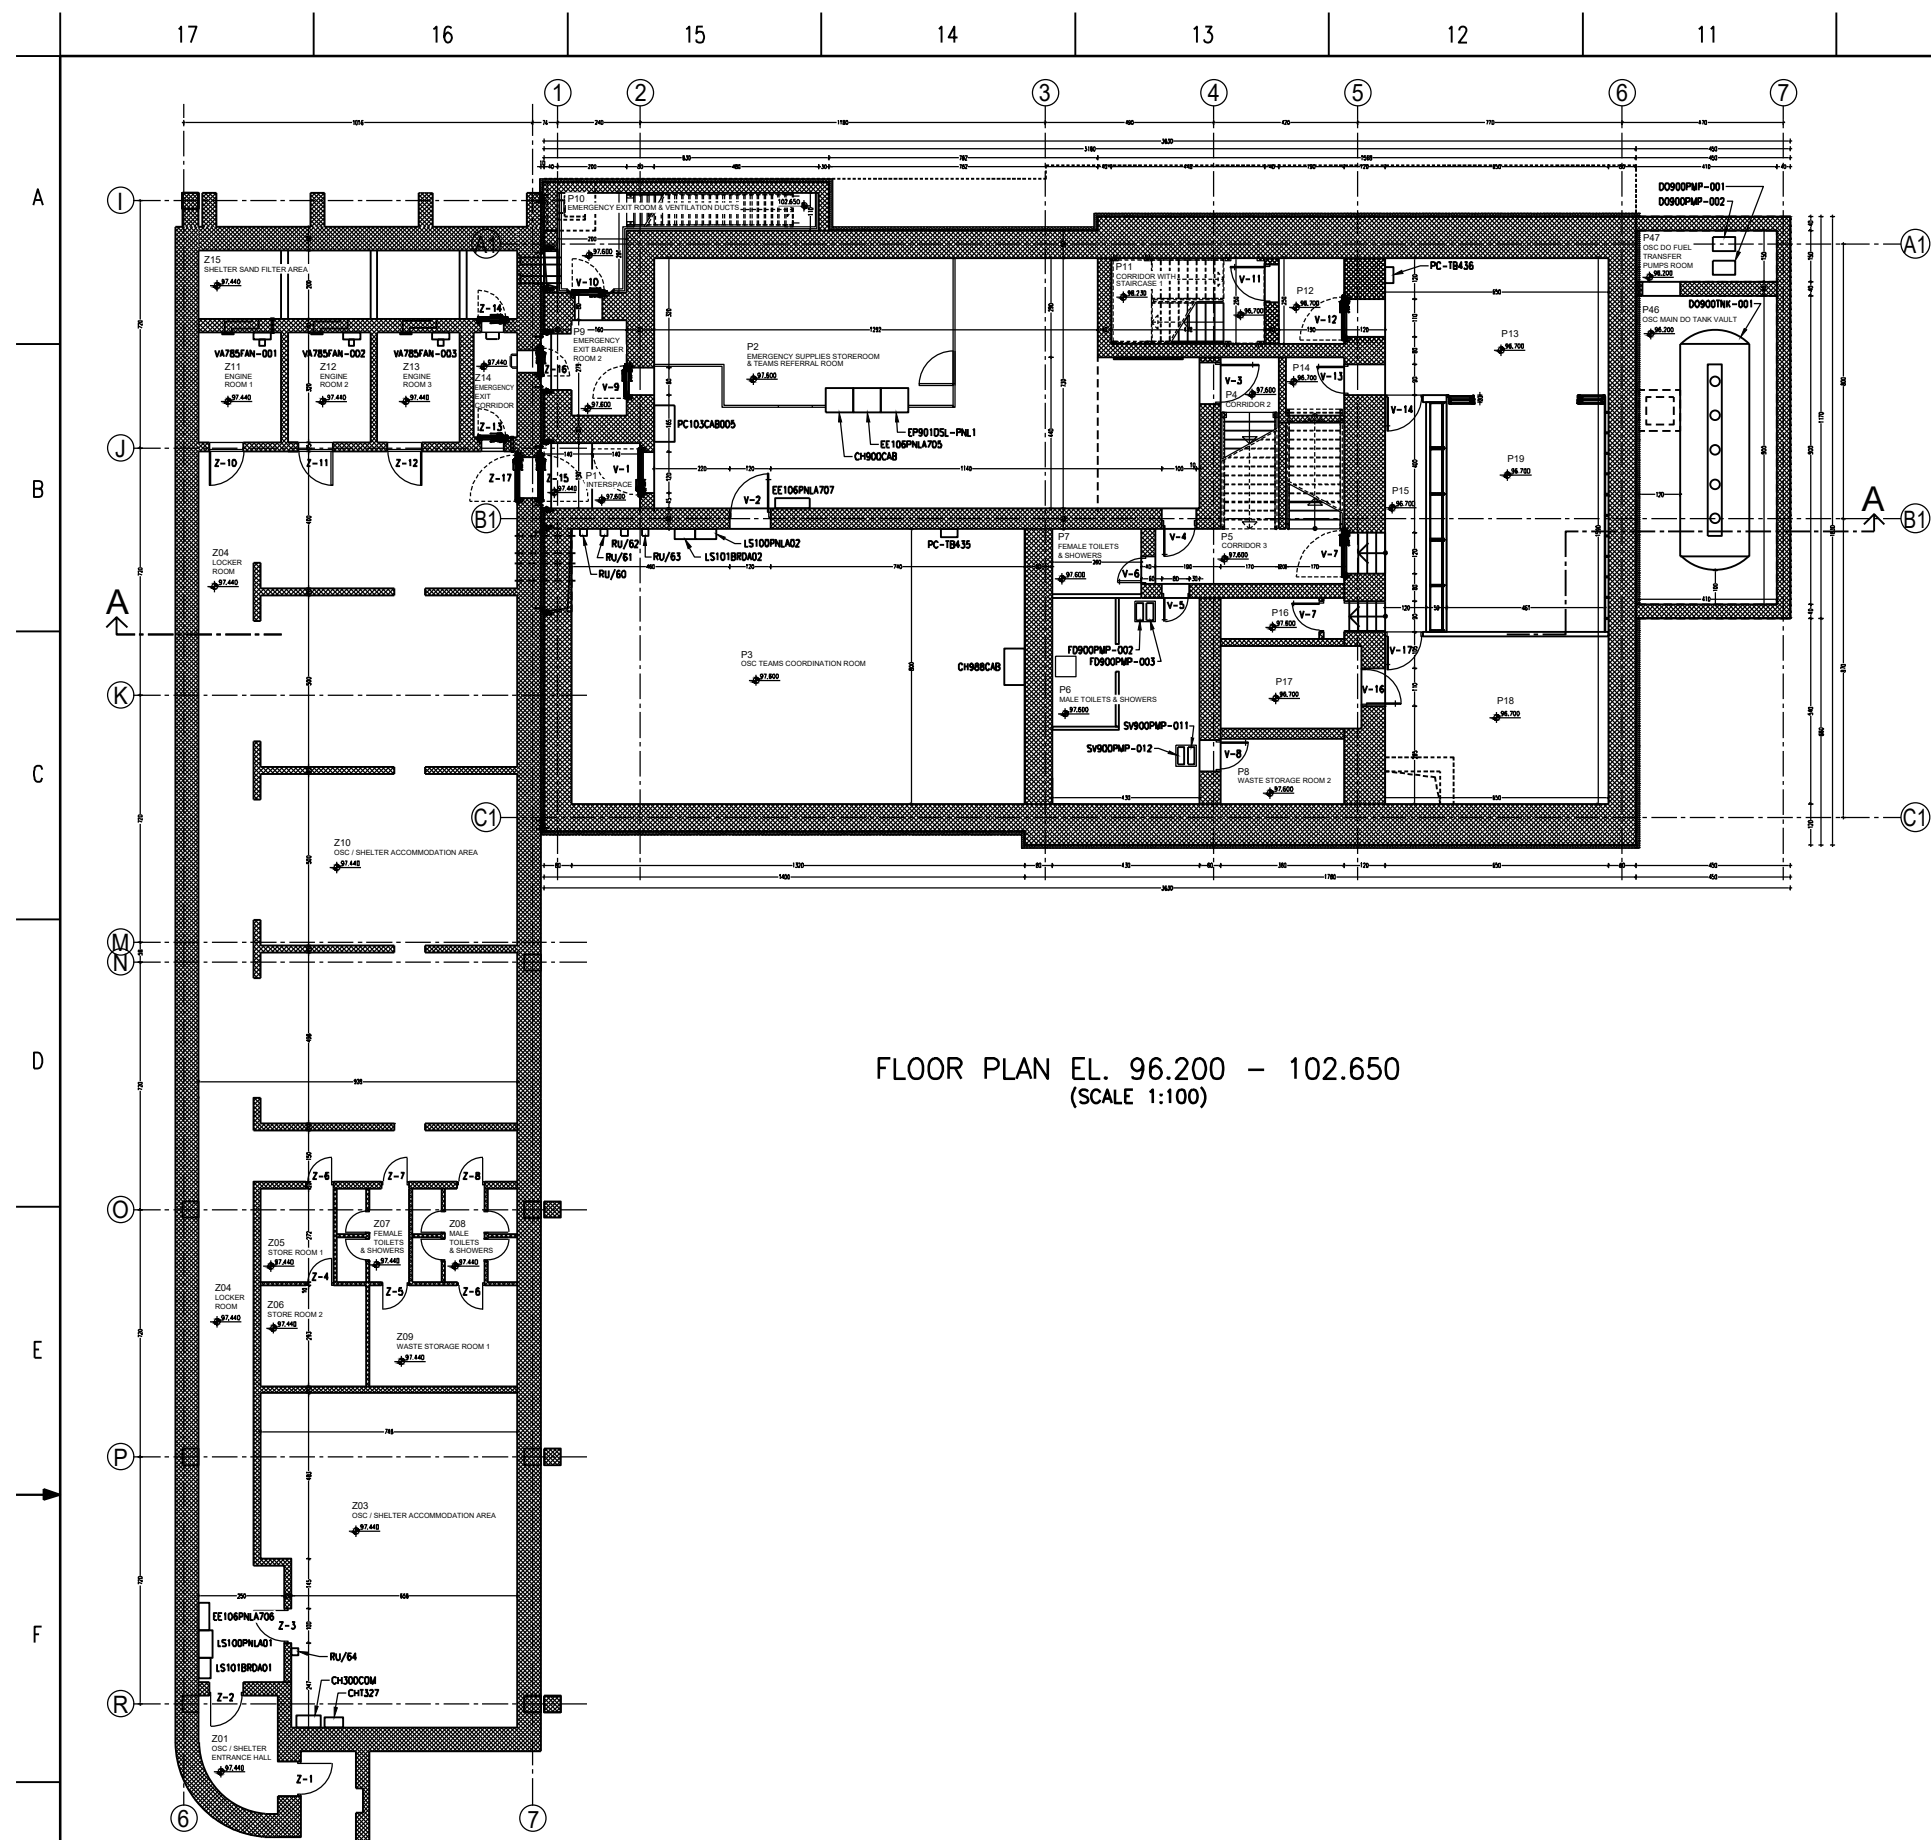


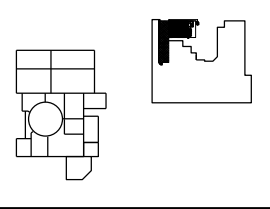

Note:
1. The coordinates in the drawings of the electrical series have the OSC prefix for PC-CKS.

1. Interim Des. No.:	E-004-416-C-A
2. Interim Des. No.:	N/A
3. Design Mod. No.:	ZKP 2024-1061
4. Drawing Rev. No.:	0
5. New Drawing No.:	E-004-416
6. Rev. No.:	0
7. Rev. No.:	0
8. Rev. No.:	0
9. Rev. No.:	0
10. Rev. No.:	0

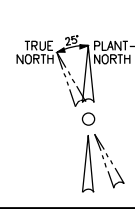

Original Design Firm: SPRO INZENIRING d.o.o.
Replaced Manual Drawing: N/A
Last Revision And Date: N/A

THIS IS A CAD DRAWING AND SHOULD NOT BE REVISED OR MODIFIED MANUALLY

REFERENCE DRAWINGS:

NO. DATE BY REVISION

0 25.05.22 F.F. ISSUED PER MOD. 1056-NA-L R.P. J.K.

NO. DATE BY REVISION

0 25.05.22 F.F. ISSUED PER MOD. 1056-NA-L R.P. J.K.

NUKLEARNA ELEKTRARNA KRSKO NUCLEAR POWER PLANT KRSKO		
FINAL PLANT LAYOUT		
OPERATIONS SUPPORT CENTER (OSC)		
FLOOR PLAN EL. 96.200 - 107.100 & SECTIONS		
DESIGN ENGINEERING		
MADE BY: F. FAKIN		
CHECKED BY: R. PETAN		
APPROVED BY: J. KERIN		
SCALE: 1:100		
DRAWING NUMBER: E-004-416		
SYSTEM: SH.NO. REV. 0		