



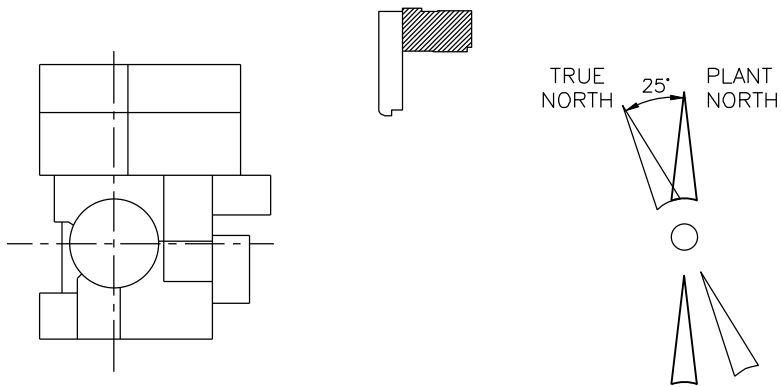

KEY PLAN

FIRE AREA	MECL ROOM	ROOM DESCRIPTION
PS02	P1	INTERSPACE
	P2	EMERGENCY SUPPLIES STOREROOM & TEAMS REFERRAL ROOM
	P3	OSC TEAMS COORDINATION ROOM
	P9	EMERGENCY EXIT BARRIER ROOM 2
PS14	P10	EMERGENCY EXIT ROOM & VENTILATION DUCTS
PS03	P11	CORRIDOR WITH STAIRCASE 1
PS08	P21	FOOD STORAGE ROOM
PS05	P22	STAIRWAYS 1
	P23	STAIRWAYS 2
PS09	P24	WASTE STORAGE ROOM 3
	P25	SANITARY WATER ENGINE ROOM
	P25A	SANITARY WATER RESERVOIR
	P26	WASTE STORAGE ROOM 4 (CONTAMINATED WASTE)

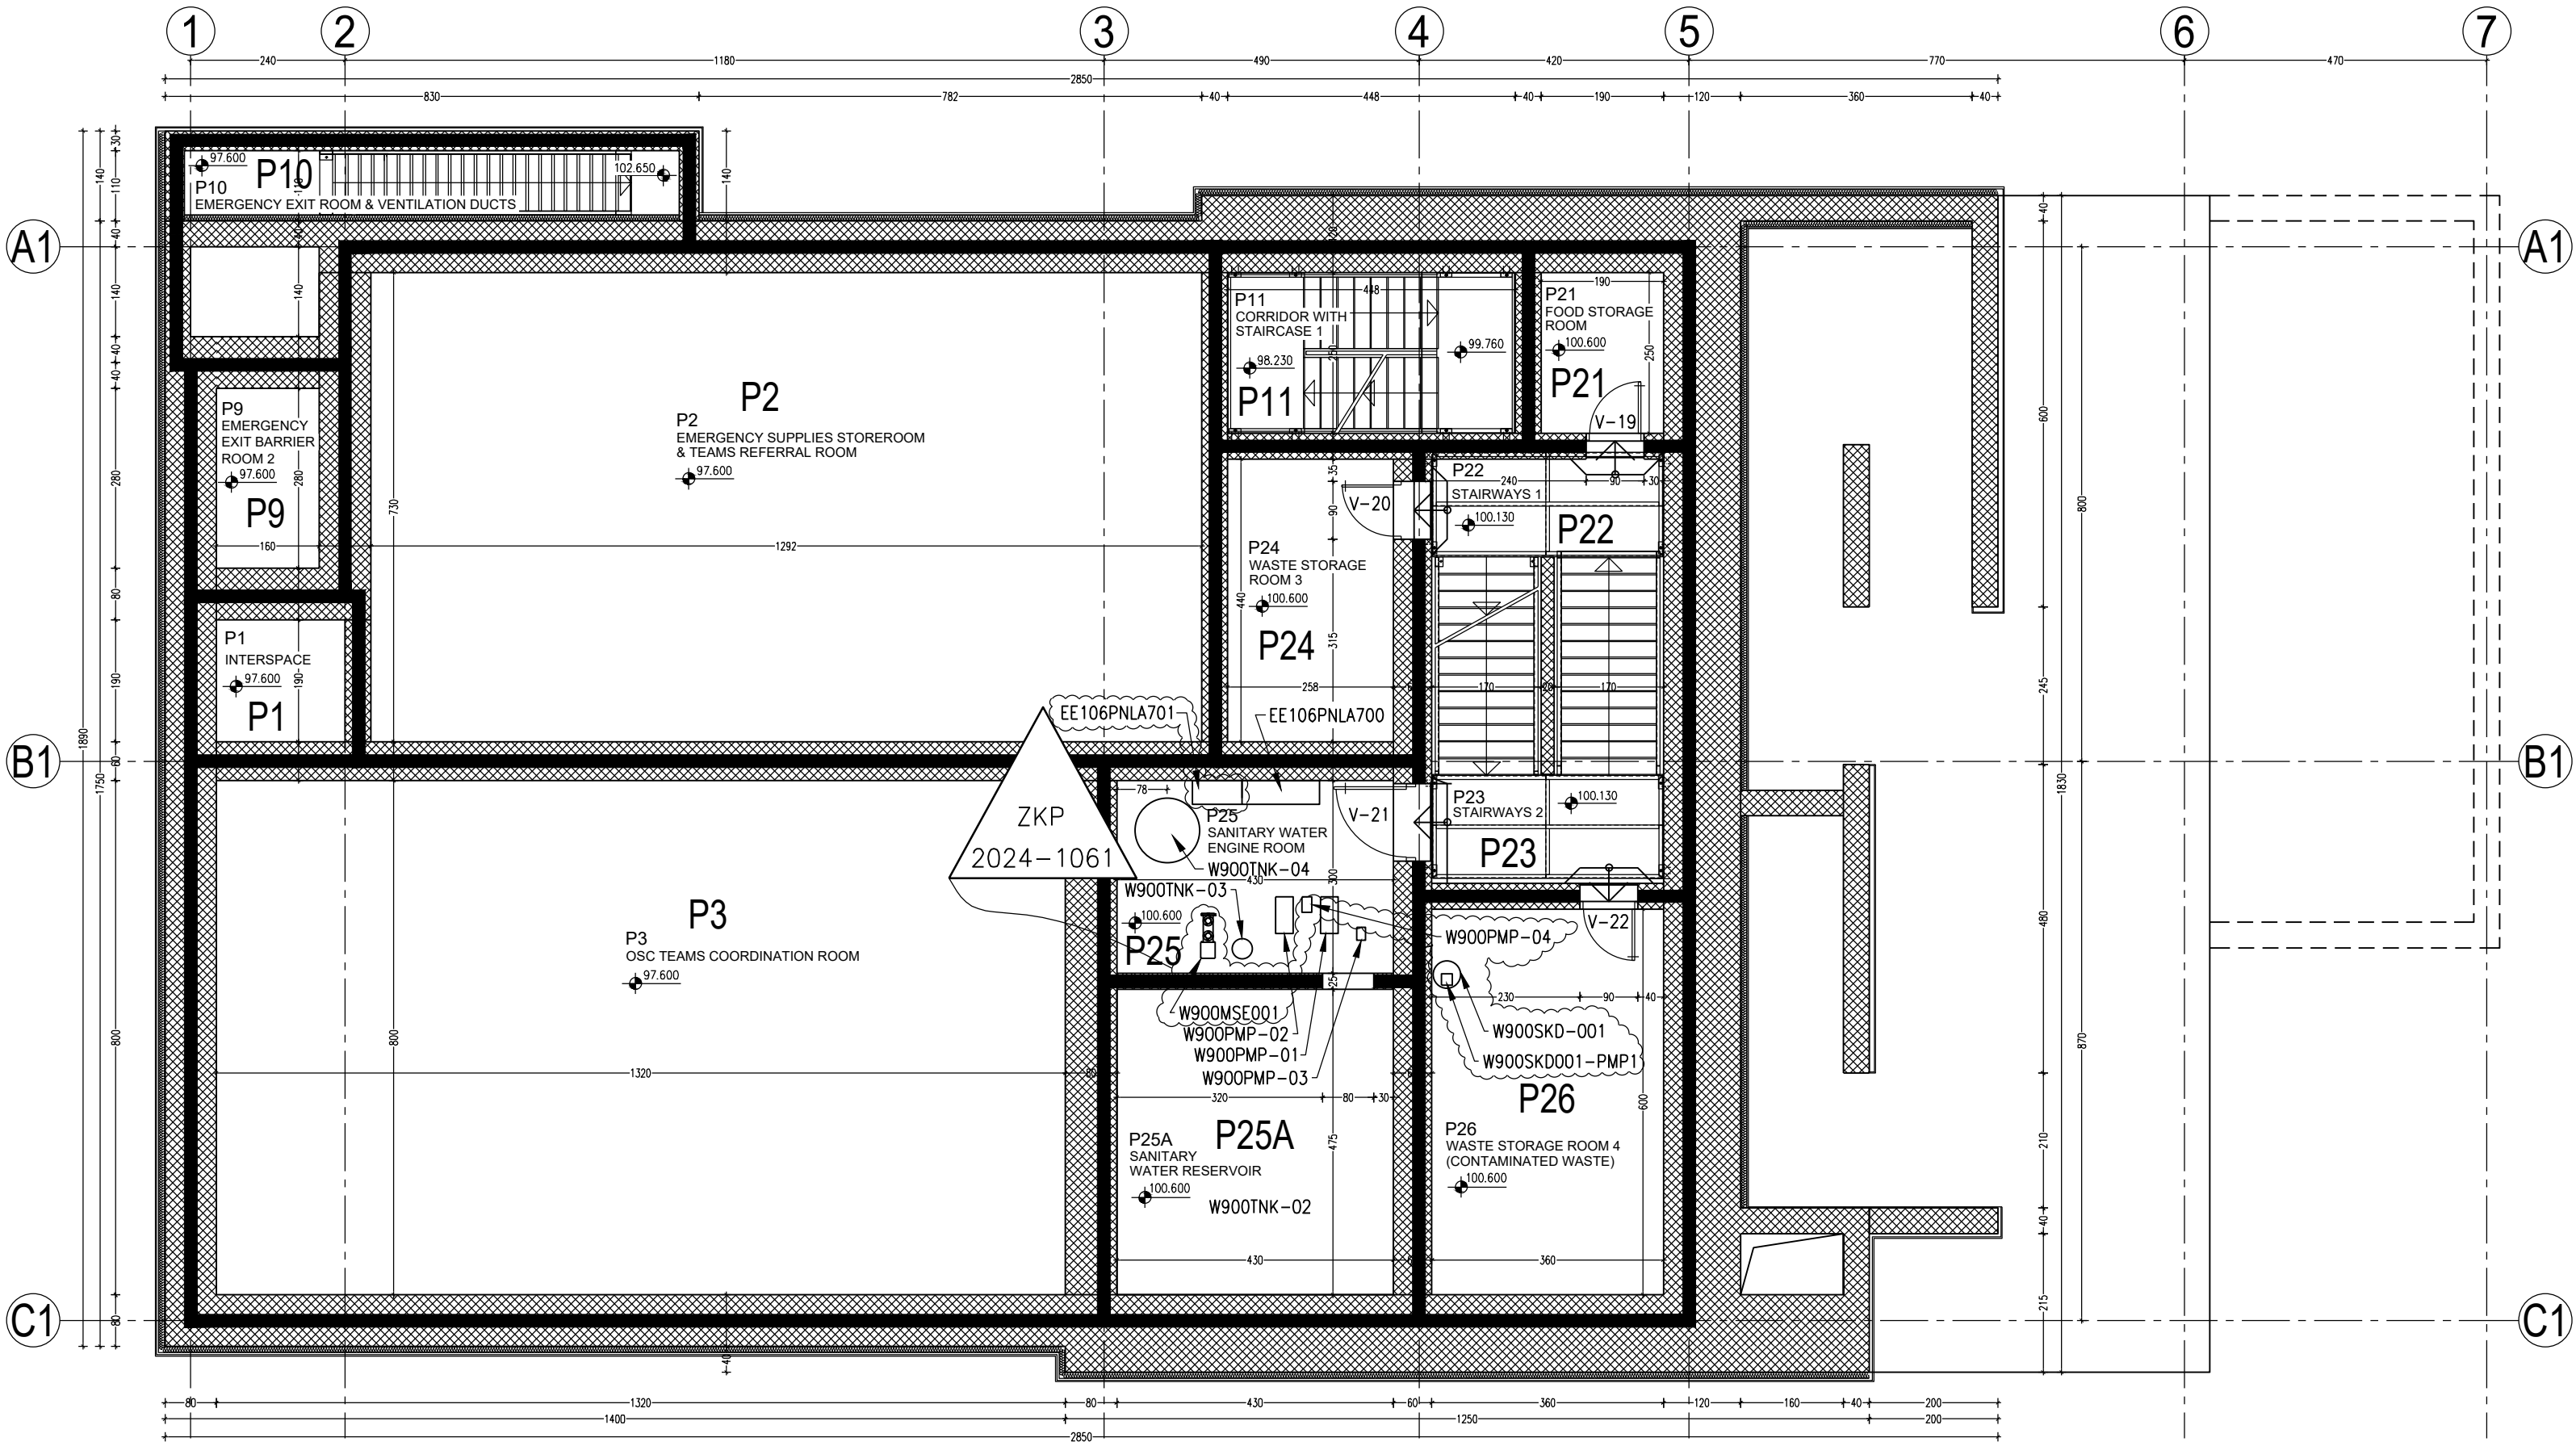

1. Interim Dwg. No.: MECL-OSC-02-0-IA
Interim Sketch No.: N/A
2. Design Mod. No.: ZKP 2024-1061
3. Drawing Rev. No.: 0
4. New Drawing No.: MECL-OSC-02
5. Resp. Eng.: T. BROMŠE Date: 18.07.2025
6. Checker: R. MLAKAR Date: 18.07.2025

Original Design Firm: SIPRO INZENIRING d.o.o.
Replaced Manual Drawing: _____
Last Revision And Date: _____

THIS IS A CAD DRAWING AND SHOULD NOT BE REVISED OR MODIFIED MANUALLY

0	25.05.22	F.F.	ISSUED PER MOD. 1056-NA-L	R.P.	G.Z.
NO.	DATE	BY	REVISION	CKD. BY	LE APPR.

NUKLEARNA ELEKTRARNA KRŠKO NUCLEAR POWER PLANT KRŠKO		
MECL PLANT LAYOUT DRAWING		
OPERATIONS SUPPORT CENTER OSC		
ELEVATIONS 97.600 - 102.650		
DESIGN ENGINEERING		
NUCLEAR POWER PLANT KRŠKO		KRŠKO, SLOVENIA
MADE	CHECKED	LE APPROVAL
1. F. FAKIN	2. R. PETAN	3. G. ZORIČ
REFERENCE DRAWINGS: <u>E-004-416</u>		
SCALE		
MECL-OSC-02		
DRAWING NUMBER		SYSTEM SH.NO. REV.
		0