


1. ALL DEVICES SHOWN ARE IN EE106PNLA701
2. REFERENCE:
3. ABBREVIATIONS:
* - W100PLC

4. TOUCH PANEL MOUNTED ON FRONT DOOR OF PANEL

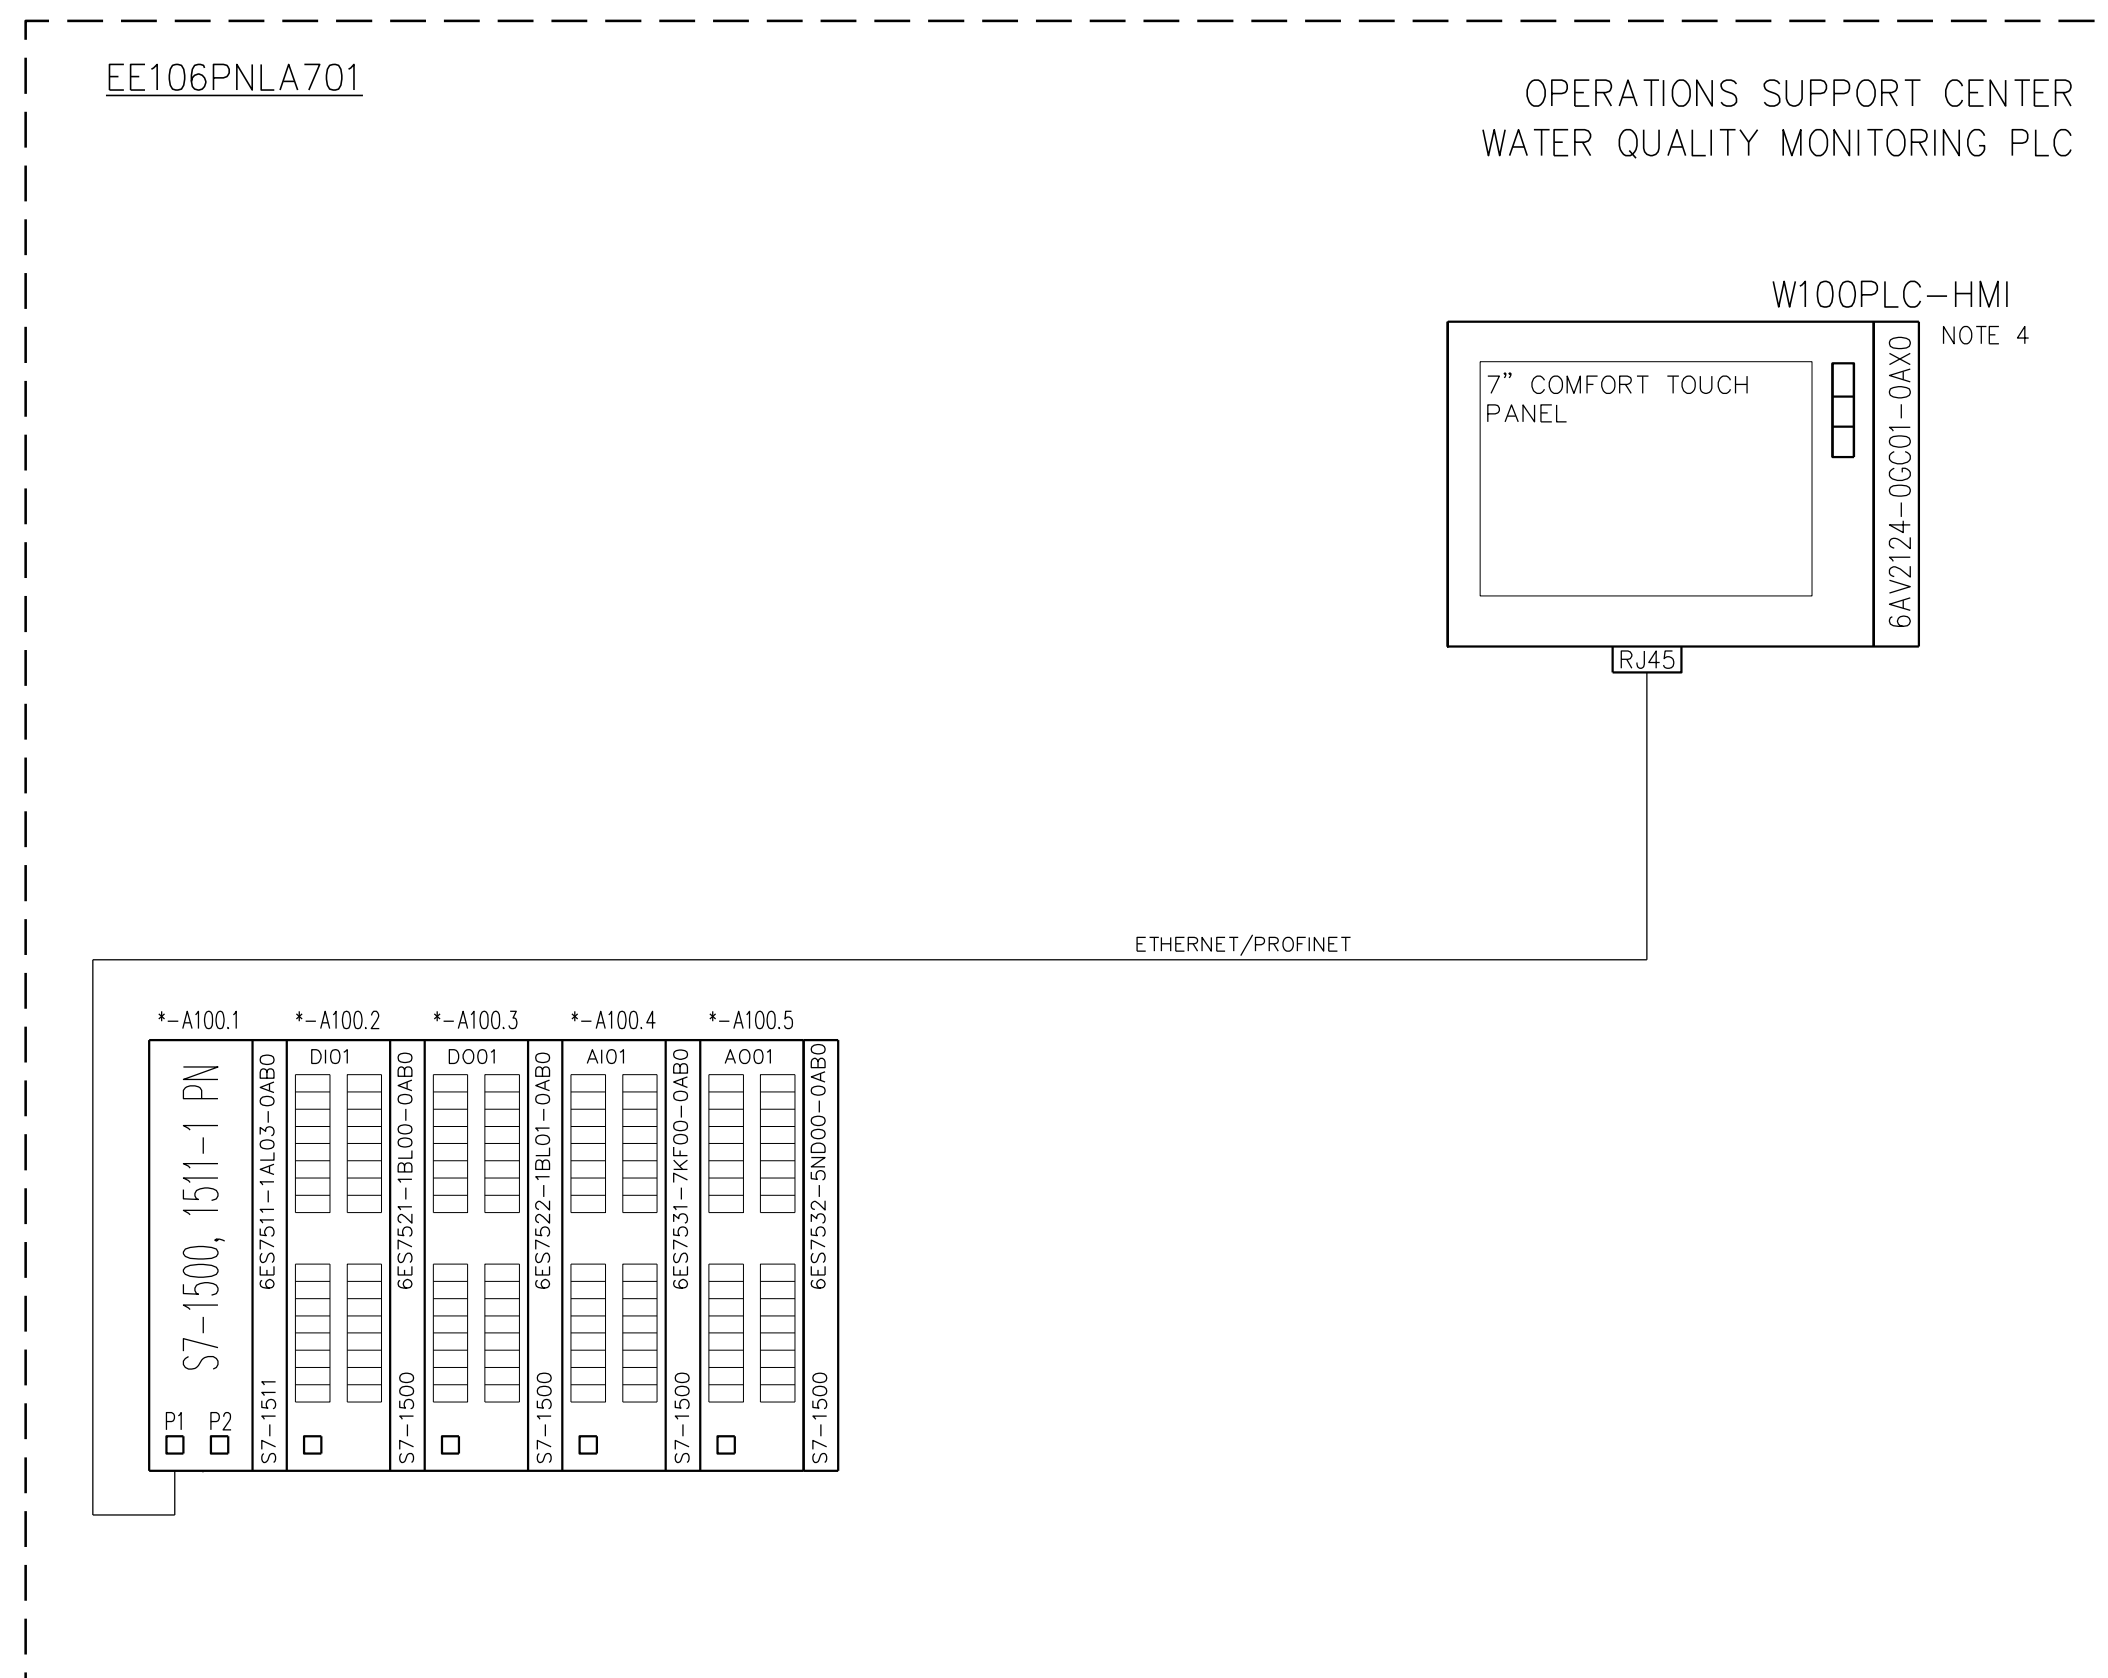

NEW
DRAWING

ZKP
2024-1061

1. Interim Dwg. No.: 816-264-10-IA
Interim Sketch No.: N/A

2. Design Mod. No.: ZKP 2024-1061

3. Drawing Rev. No.: N/A

4. New Drawing No.: 816-264-10

5. Resp. Eng.: M. SEGULA Date: 07.2025

6. Checker: B.BAS Date: 07.2025

Original Design Firm:	SIPRO INZENIRING D.O.O.
Replaced Manual Drawing:	N/A
Last Revision And Date:	N/A

THIS IS A CAD DRAWING AND SHOULD NOT BE REVISED OR MODIFIED MANUALLY

THIS IS A CAD DRAWING AND SHOULD NOT BE REVISED OR MODIFIED MANUALLY					
NO	DATE	BY	REVISION	CKD BY	IF APPR

NUKLEARNA ELEKTRARNA KRSKO				
NUCLEAR POWER PLANT KRSKO				
PROCESS COMPUTER SYSTEMS – PCS				
NETWORK LAYOUT DIAGRAM				
(EE106PNLA701) W100PLC NETWORK				
		DESIGN ENGINEERING		
NUCLEAR POWER PLANT KRSKO		KRŠKO, SLOVENIA		
MADE	CHECKED	LE APPROVAL		
1. M. ŠEĞULA	2. R. PETAN	3. D. VEHOVAR		
REFERENCE DRAWINGS:				
SCALE	816–264		W	10
	DRAWING NUMBER		SYSTEM	SH.NO.