



FILE: 81636430-IA.DWG, SPRJELJ:

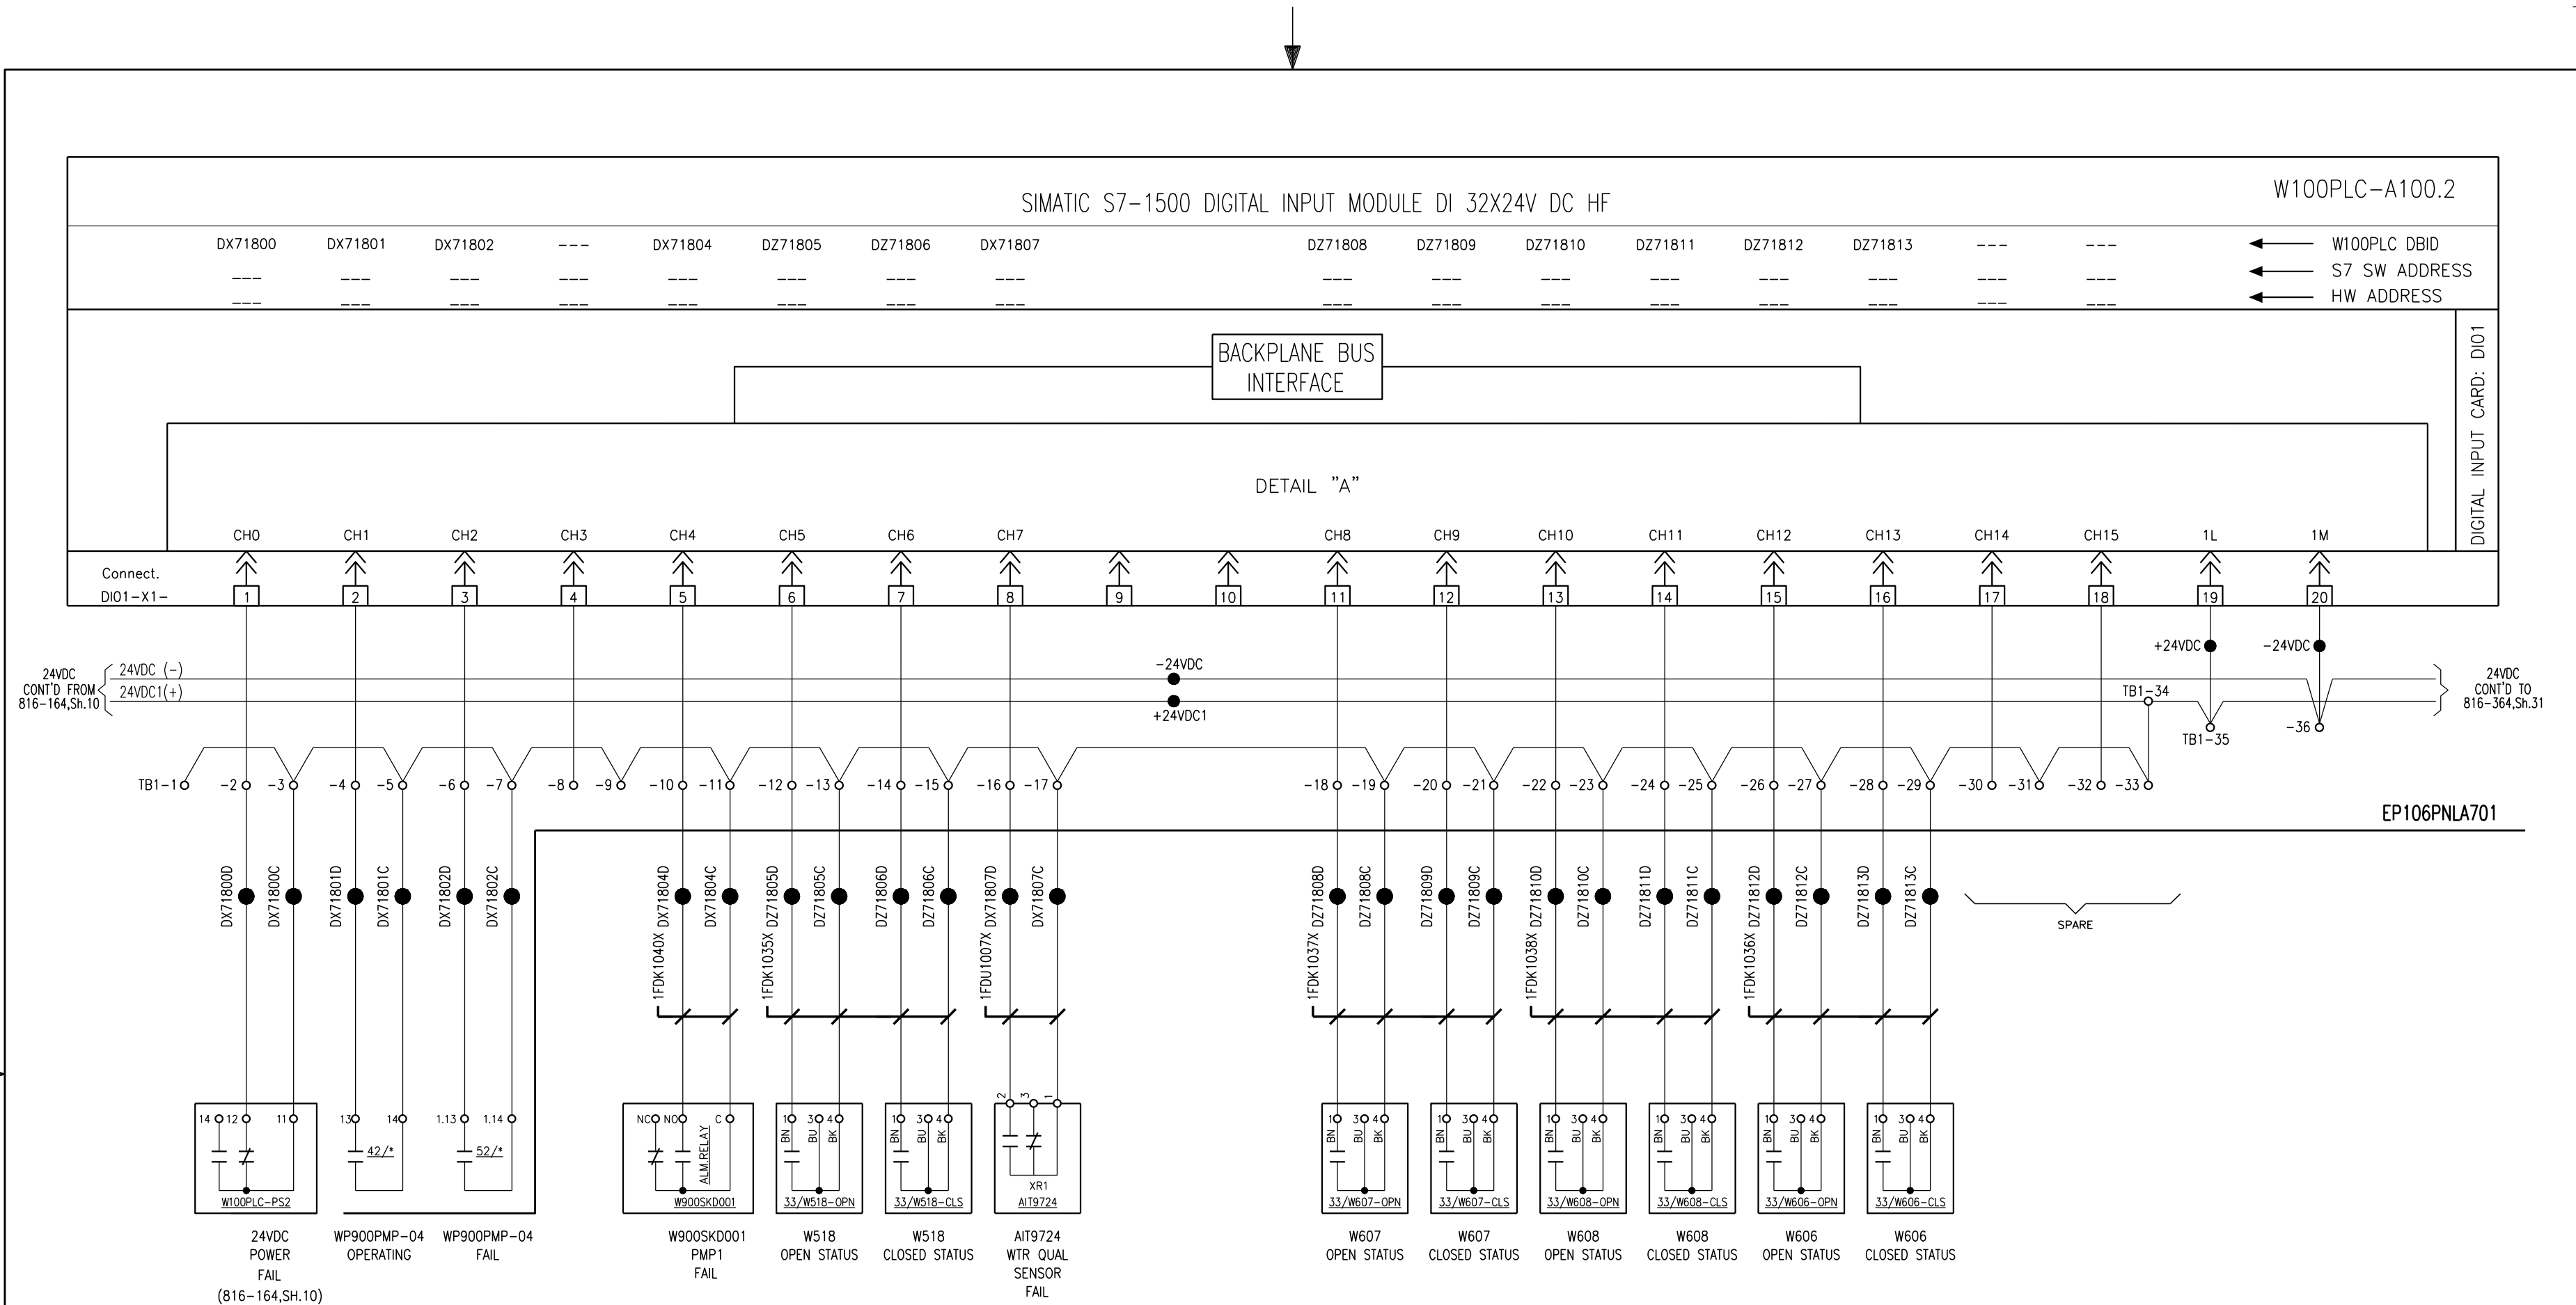

DETAIL "A" - DIGITAL INPUT MODULE DI 32X24V DC HF


Type 6ES7521-1BL00-0AB0

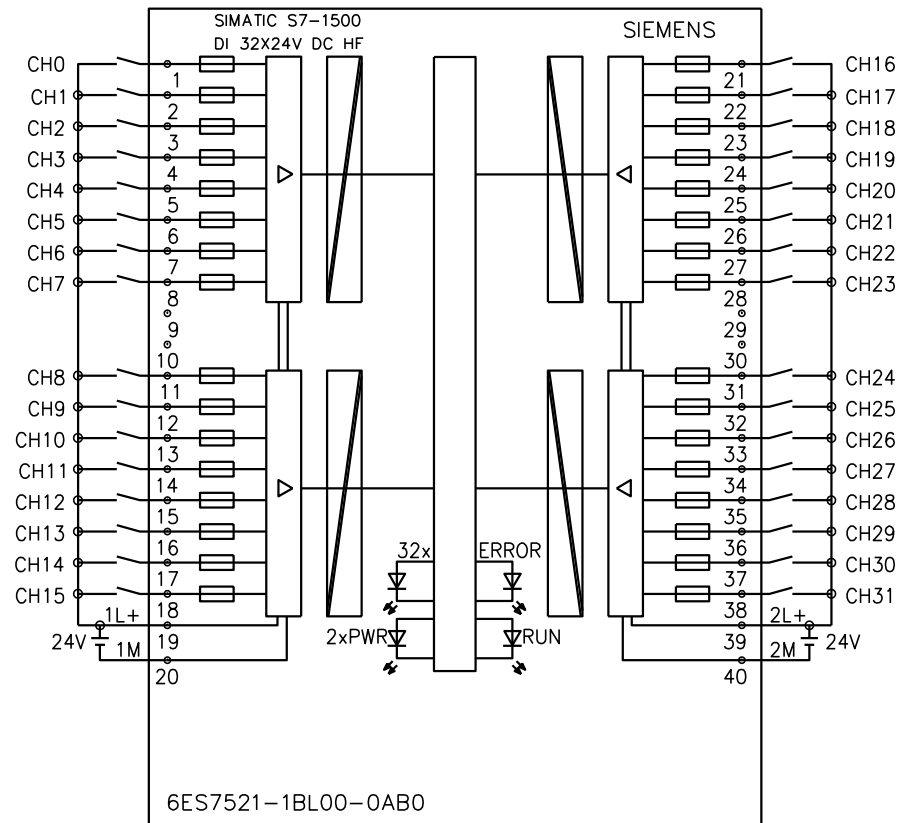

NOTES:

- ALL DEVICES WITHOUT LOCATION MARKINGS ARE LOCATED IN CABINET EE106PNLA701
- ALL DIGITAL CHANNELS INPUT CIRCUITS HAVE SCHEMATIC AS SHOWN IN DETAIL "A".
- * - W900PMP-04

NEW
DRAWING

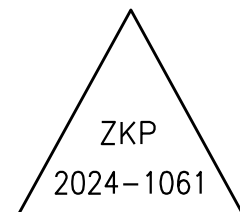

1. Interim Dwg. No.:	816-364-30-IA
Interim Sketch No.:	N/A
2. Design Mod. No.:	ZKP 2024-1061
3. Drawing Rev. No.:	N/A
4. New Drawing No.:	816-364-30
5. Resp. Eng.:	M. ŠEĞULA Date: 07.2025
6. Checker:	B.BAS Date: 07.2025

Original Design Firm: SIPRO INZENIRING D.O.O.
Replaced Manual Drawing: N/A
Last Revision And Date: N/A

THIS IS A CAD DRAWING AND SHOULD NOT BE REVISED OR MODIFIED MANUALLY

NO.	DATE	BY	REVISION	CKD. BY	LE APPR.

NUKLEARNA ELEKTRARNA KRSKO NUCLEAR POWER PLANT KRSKO		
PROCESS COMPUTER SYSTEMS - PCS		
I/O LOOP WIRING DIAGRAM: OSC WTR SYS MONIT		
DIGITAL INPUTS W100PLC-A100.2 1/2		
DESIGN ENGINEERING		
MADE	CHECKED	LE APPROVAL
1. M. ŠEĞULA	2. R. PETAN	3. D. VEHOVAR
REFERENCE DRAWINGS:		
SCALE	816-364	W 30 0
DRAWING NUMBER		SYSTEM SH.NO. REV