

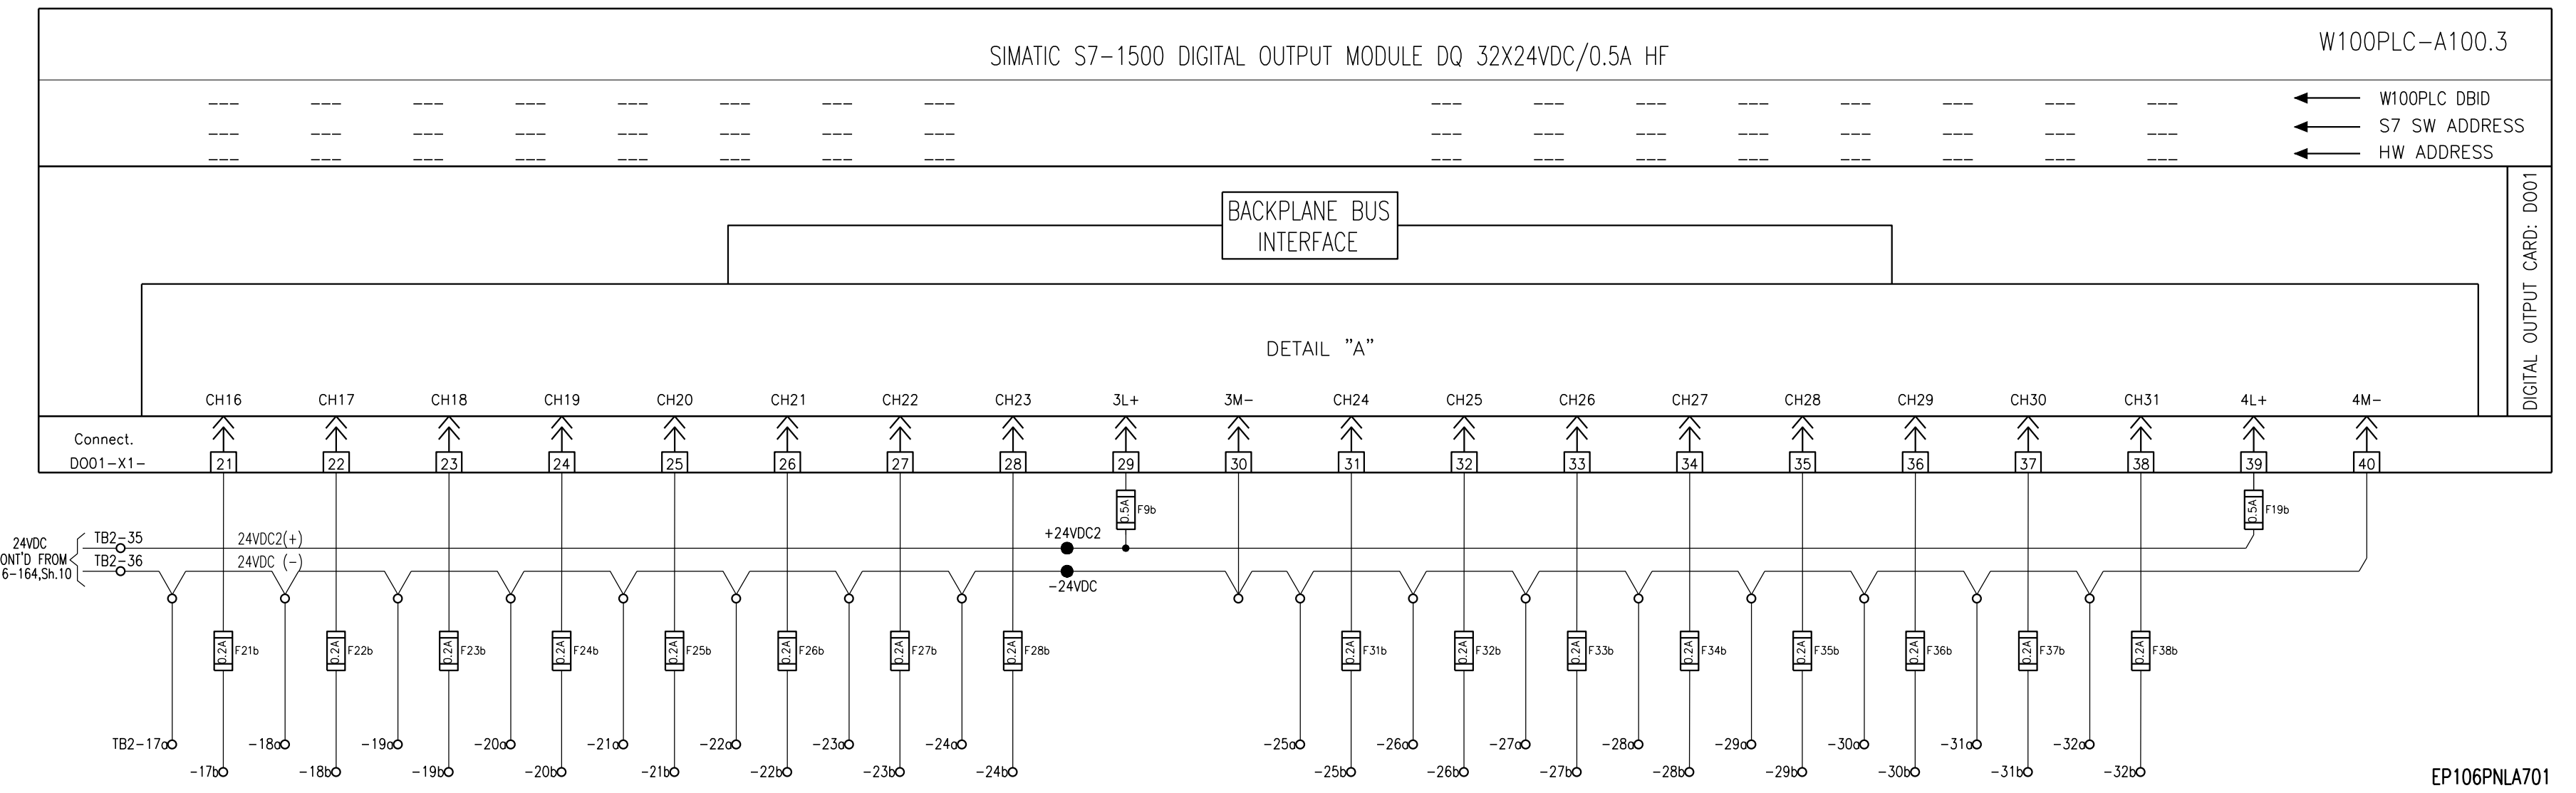


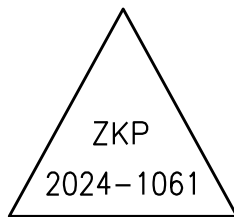

DETAIL "A" - DIGITAL OUTPUT MODULE DQ 32X24VDC/0.5A HF  
Type 6ES7522-1BL01-0AB0

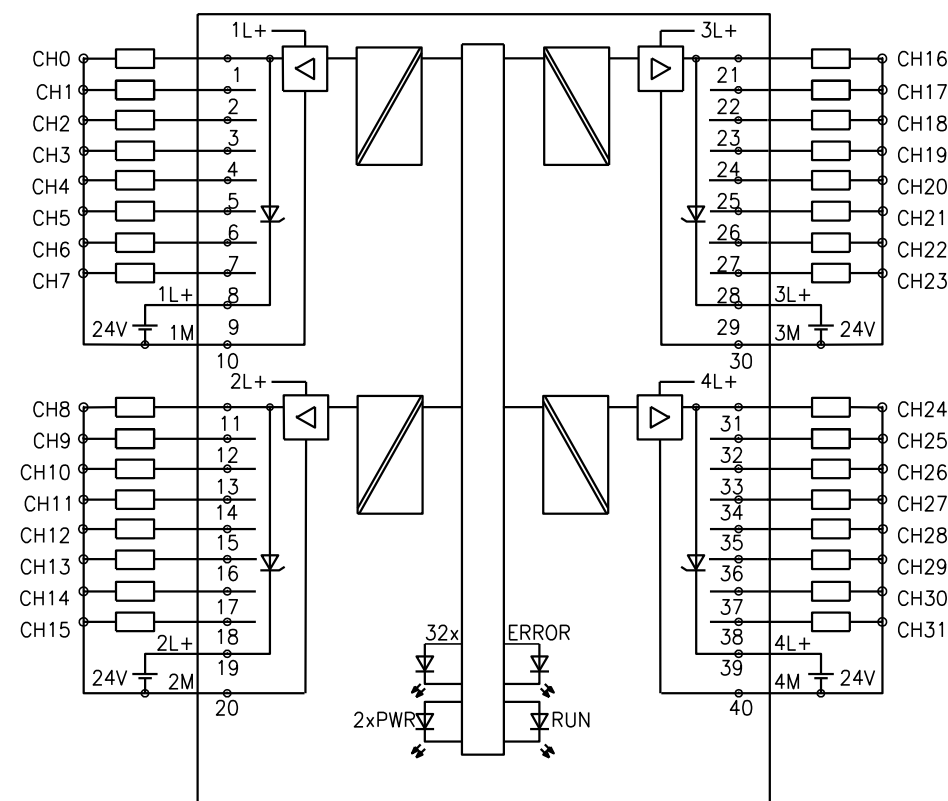

|                      |                         |
|----------------------|-------------------------|
| 1. Interim Dwg. No.: | 816-364-33-IA           |
| Interim Sketch No.:  | N/A                     |
| 2. Design Mod. No.:  | ZKP 2024-1061           |
| 3. Drawing Rev. No.: | N/A                     |
| 4. New Drawing No.:  | 816-364-33              |
| 5. Resp. Eng.:       | M. SEGULA Date: 07.2025 |
| 6. Checker:          | B.BAS Date: 07.2025     |

Original Design Firm: SIPRO INZENIRING D.O.O.  
Replaced Manual Drawing: N/A  
Last Revision And Date: N/A

THIS IS A CAD DRAWING AND SHOULD NOT BE REVISED OR MODIFIED MANUALLY

| NO. | DATE | BY | REVISION | CKD. BY | LE APPR. |
|-----|------|----|----------|---------|----------|
|     |      |    |          |         |          |
|     |      |    |          |         |          |
|     |      |    |          |         |          |
|     |      |    |          |         |          |
|     |      |    |          |         |          |

- NOTES:
- ALL DEVICES WITHOUT LOCATION MARKINGS ARE LOCATED IN CABINET EE106PNLA701
  - ALL DIGITAL CHANNELS INPUT CIRCUITS HAVE SCHEMATIC AS SHOWN IN DETAIL "A".

NEW  
DRAWING

|                                                         |             |                    |
|---------------------------------------------------------|-------------|--------------------|
| NUKLEARNA ELEKTRARNA KRSKO<br>NUCLEAR POWER PLANT KRSKO |             |                    |
| PROCESS COMPUTER SYSTEMS - PCS                          |             |                    |
| I/O LOOP WIRING DIAGRAM: OSC WTR SYS MONIT              |             |                    |
| DIGITAL OUTPUTS W100PLC-A100.3 SH.2/2                   |             |                    |
| DESIGN ENGINEERING                                      |             |                    |
| NUCLEAR POWER PLANT KRSKO                               |             | KRSKO, SLOVENIA    |
| MADE                                                    | CHECKED     | LE APPROVAL        |
| 1. M. SEGULA                                            | 2. R. PETAN | 3. D. VEHOVAR      |
| REFERENCE DRAWINGS:                                     |             |                    |
| SCALE                                                   | 816-364     | W 33               |
| DRAWING NUMBER                                          |             | SYSTEM SH.NO. REV. |