


FILE: 81666407-IA.DWG, SPREJEL:

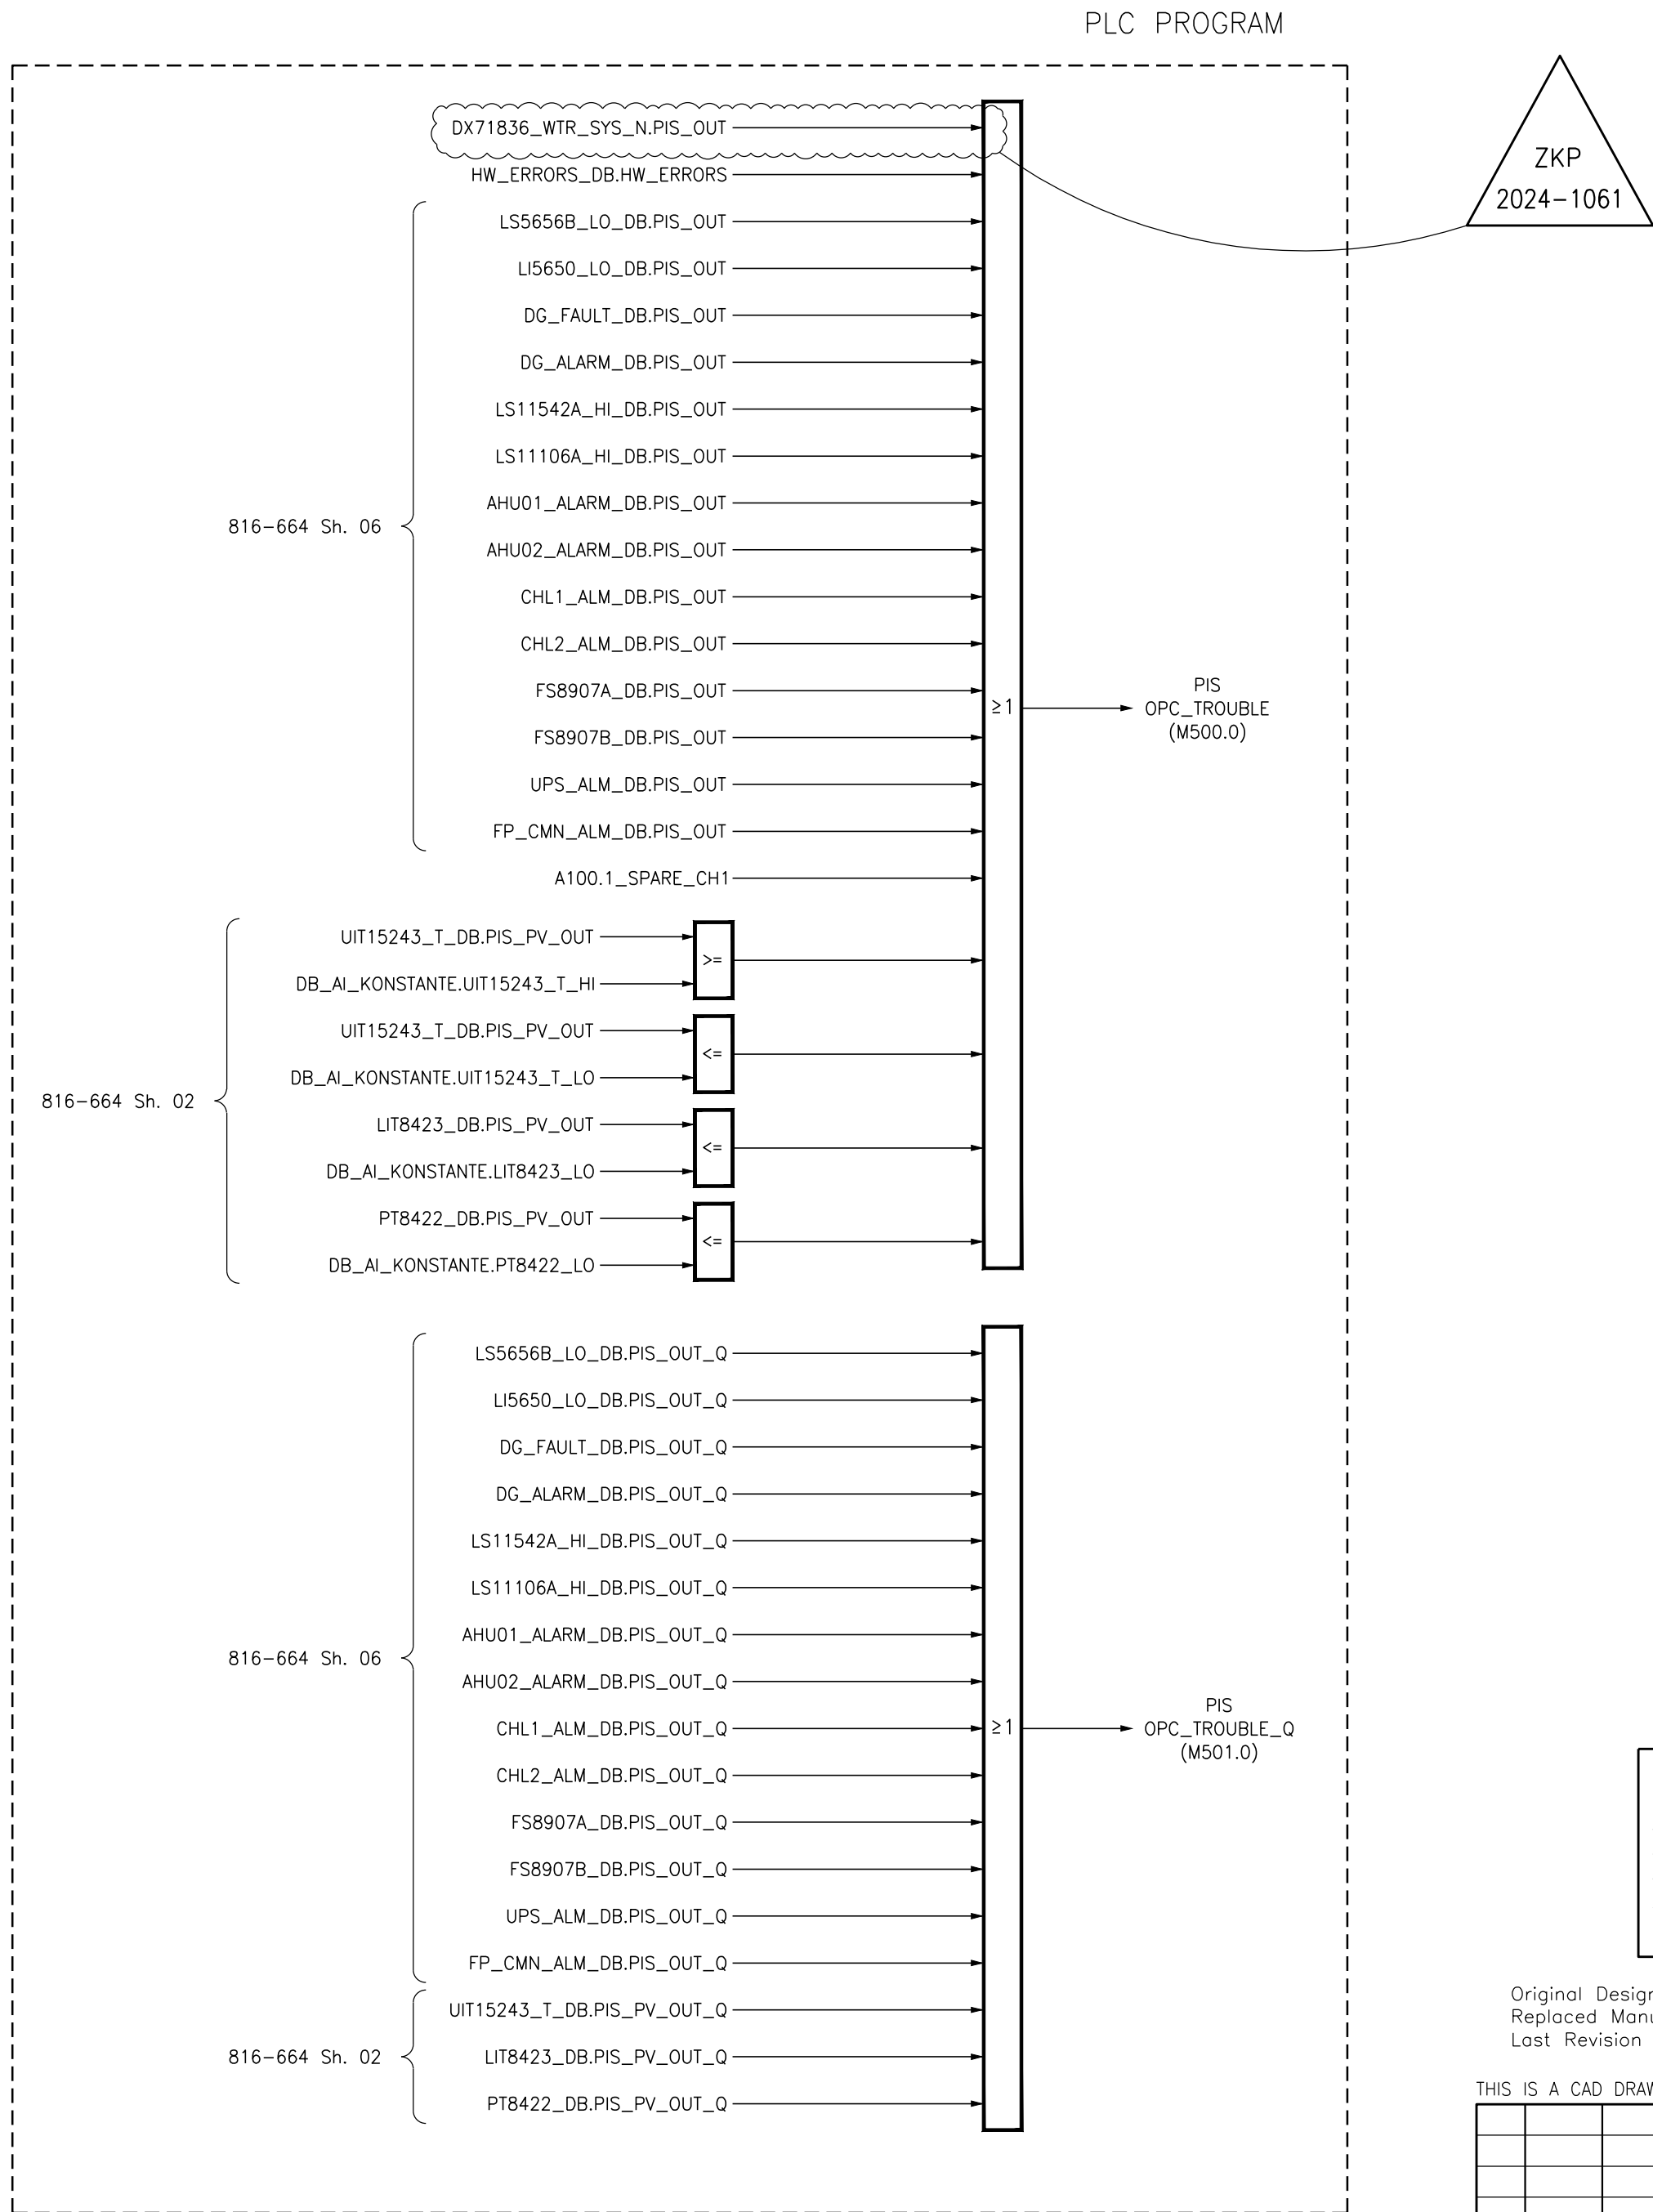

1. Interim Dwg. No.:	816-664-07-0-IA
Interim Sketch No.:	N/A
2. Design Mod. No.:	ZKP 2024-1061
3. Drawing Rev. No.:	0
4. New Drawing No.:	N/A
5. Resp. Eng.: M. SEGULA	Date: 07.2025
6. Checker: B.BAS	Date: 07.2025

Original Design Firm: IBE
Replaced Manual Drawing: N/A
Last Revision And Date: N/A

THIS IS A CAD DRAWING AND SHOULD NOT BE REVISED OR MODIFIED MANUALLY

O	30.08.23	IBE	ISSUED PER MOD 1056-NA-L	R.P.	D.V.
NO.	DATE	BY	REVISION	CKD. BY	LE APPR.

NUKLEARNA ELEKTRARNA KRSKO NUCLEAR POWER PLANT KRSKO						
PROCESS COMPUTER SYSTEM – (PCS)						
PROGRAM LOGIC & FUNCTIONAL DIAGRAMS						
OPC COMMON TROUBLE ALARM LOGIC						
	DESIGN ENGINEERING					
	NUCLEAR POWER PLANT KRSKO			KRSKO, SLOVENIA		
MADE		CHECKED		LE APPROVAL		
1. IBE		2. R. PETAN		3. D. VEHOVAR		
REFERENCE DRAWINGS:						
SCALE	816–664			07	0	
DRAWING NUMBER				SYSTEM	SH.NO.	REV.