



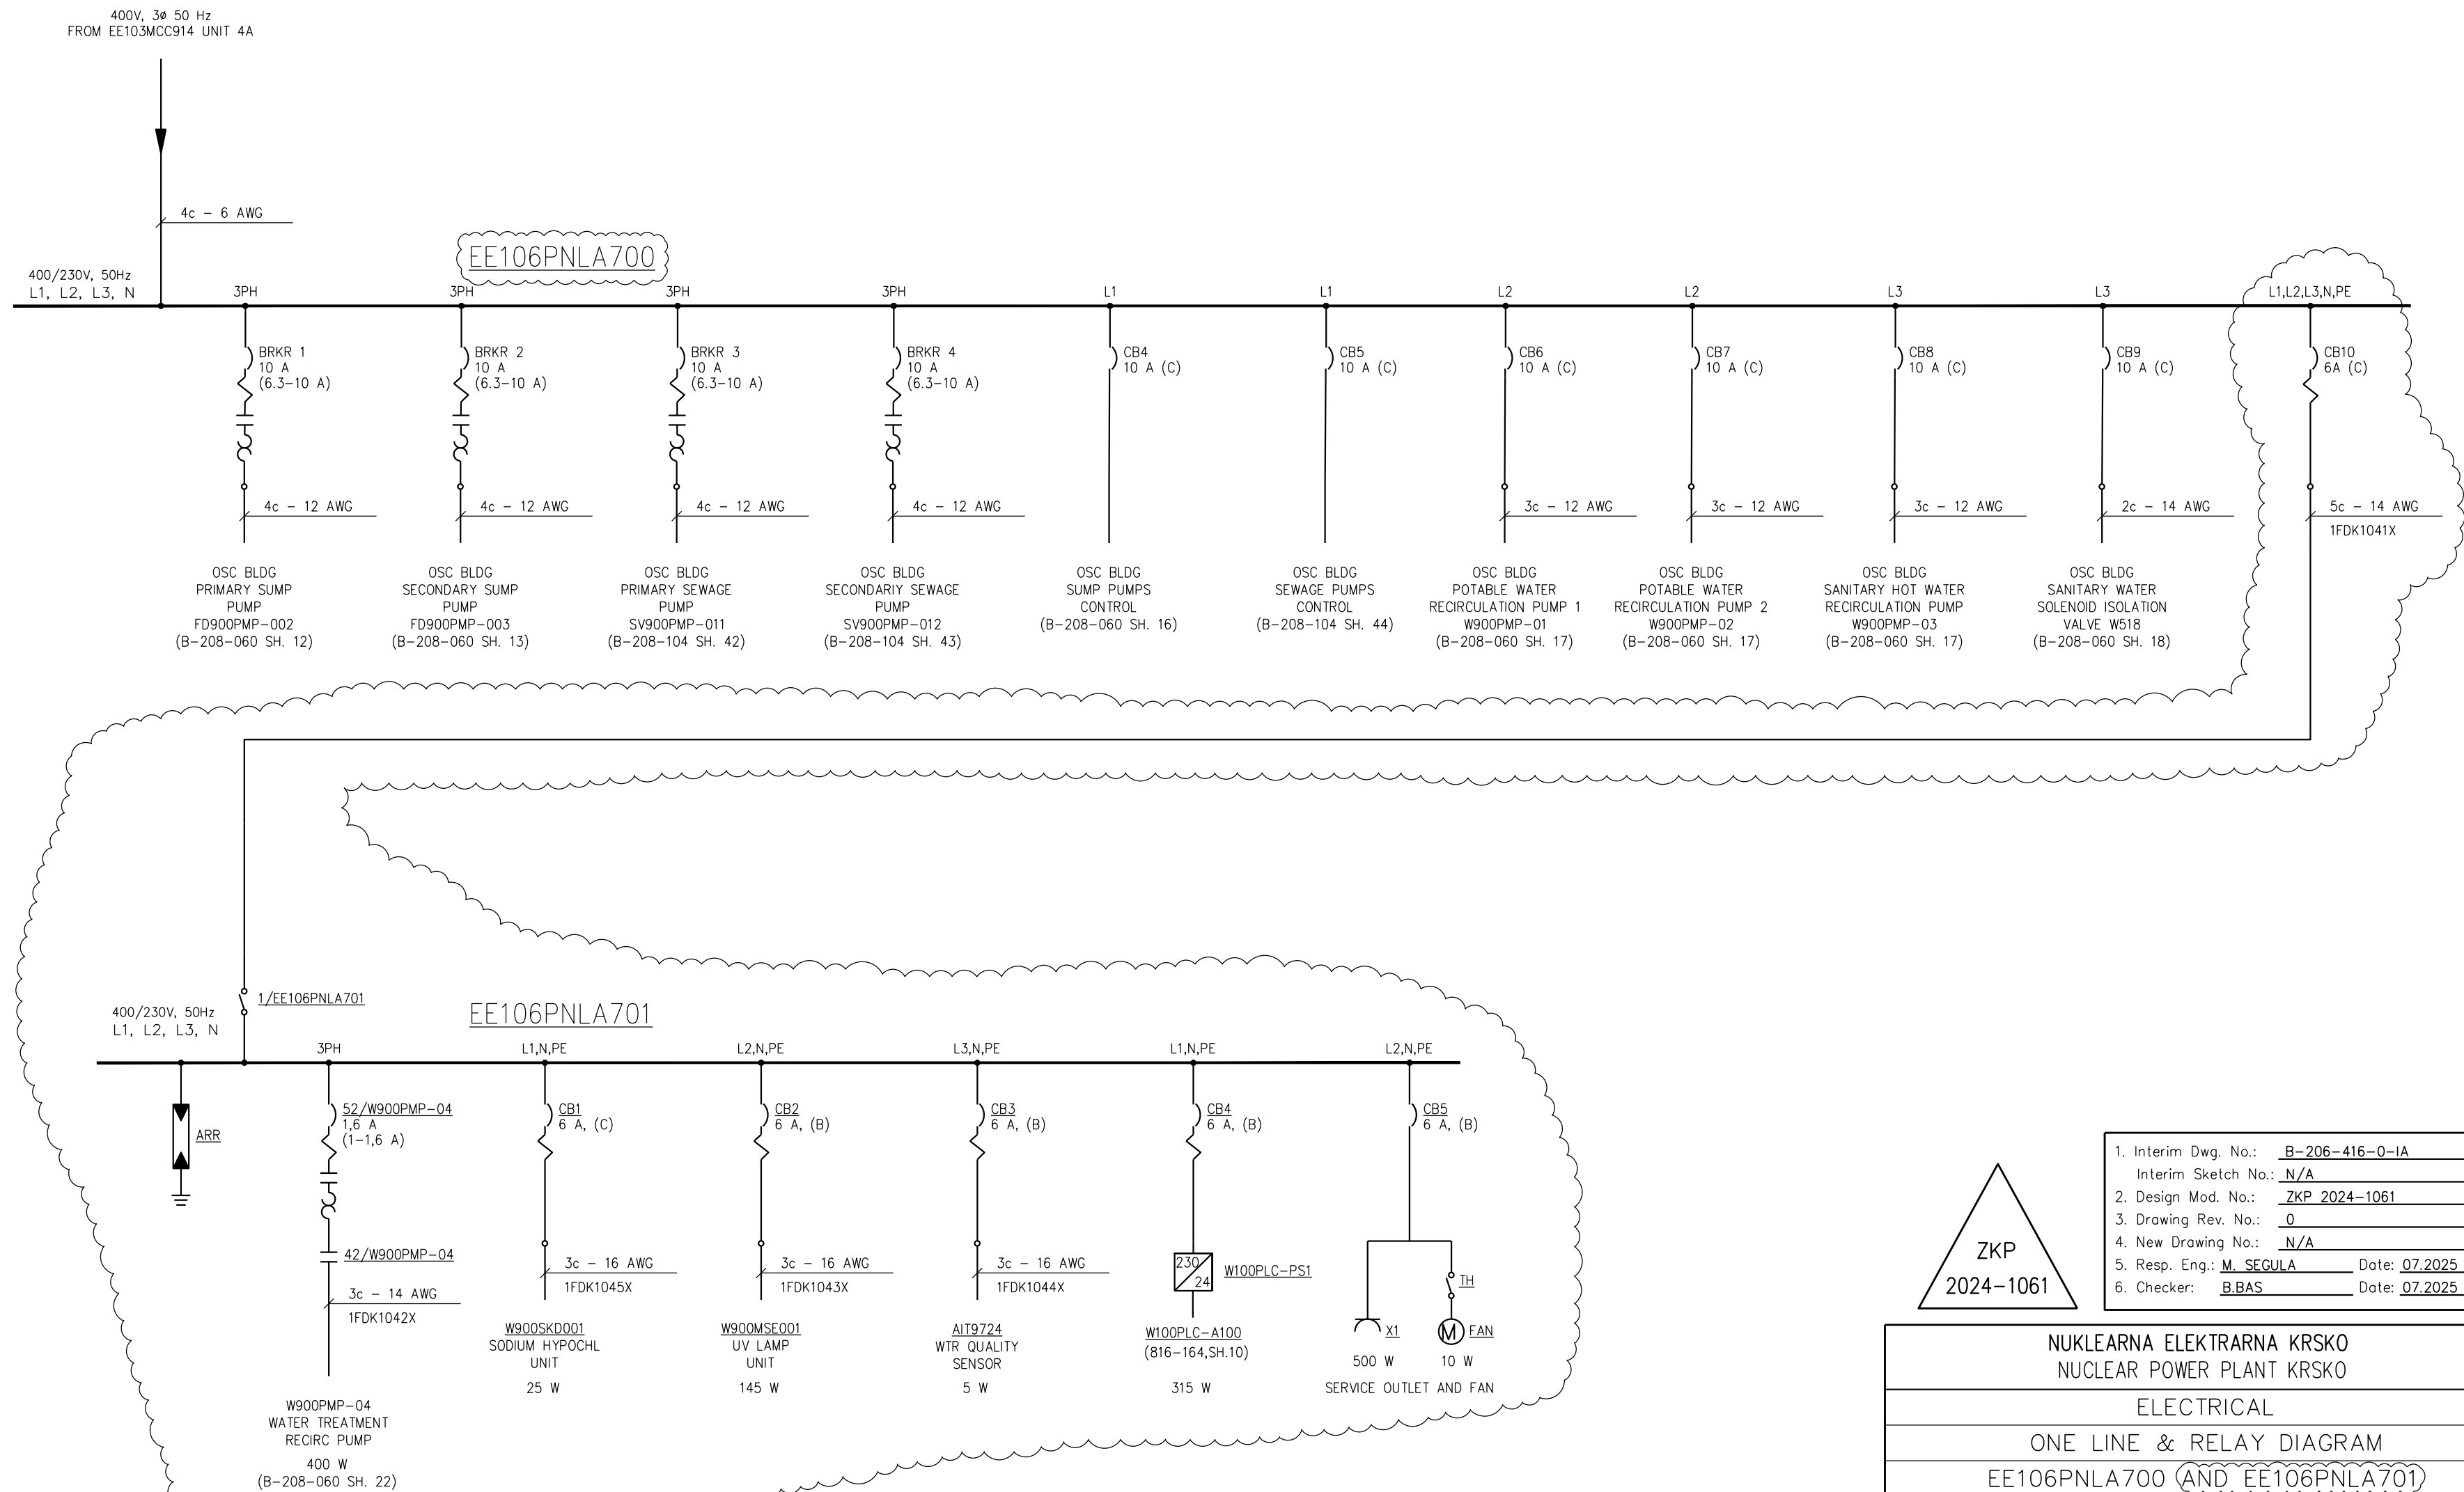

1. Interim Dwg. No.:	B-206-416-0-1A
Interim Sketch No.:	N/A
2. Design Mod. No.:	ZKP 2024-1061
3. Drawing Rev. No.:	0
4. New Drawing No.:	N/A
5. Resp. Eng.:	M. SEGULA
Date:	07.2025
6. Checker:	B.BAS
Date:	07.2025

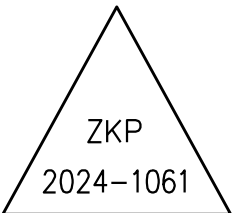

NUKLEARNA ELEKTRARNA KRSKO
NUCLEAR POWER PLANT KRSKO

ELECTRICAL

ONE LINE & RELAY DIAGRAM

EE106PNLA700 (AND EE106PNLA701)

DESIGN ENGINEERING

NUCLEAR POWER PLANT KRSKO

KRSKO, SLOVENIA



MADE	CHECKED	LE APPROVAL
1. P. VINTAR	2. R. PETAN	3. B. PEVEC

REFERENCE
DRAWINGS:

SCALE	B-206-416	0
NO.	DATE	BY
NO.	DATE	BY

Original Design Firm: SIPRO INŽENIRING D.O.O.
Replaced Manual Drawing: N/A
Last Revision And Date: N/A

THIS IS A CAD DRAWING AND SHOULD NOT BE REVISED OR MODIFIED MANUALLY

0	03.2022	P.V.	ISSUE'D PER MOD. 1056-NA-L	R.P.	B.P.
NO.	DATE	BY	REVISION	CKD. BY	LE APPR.