

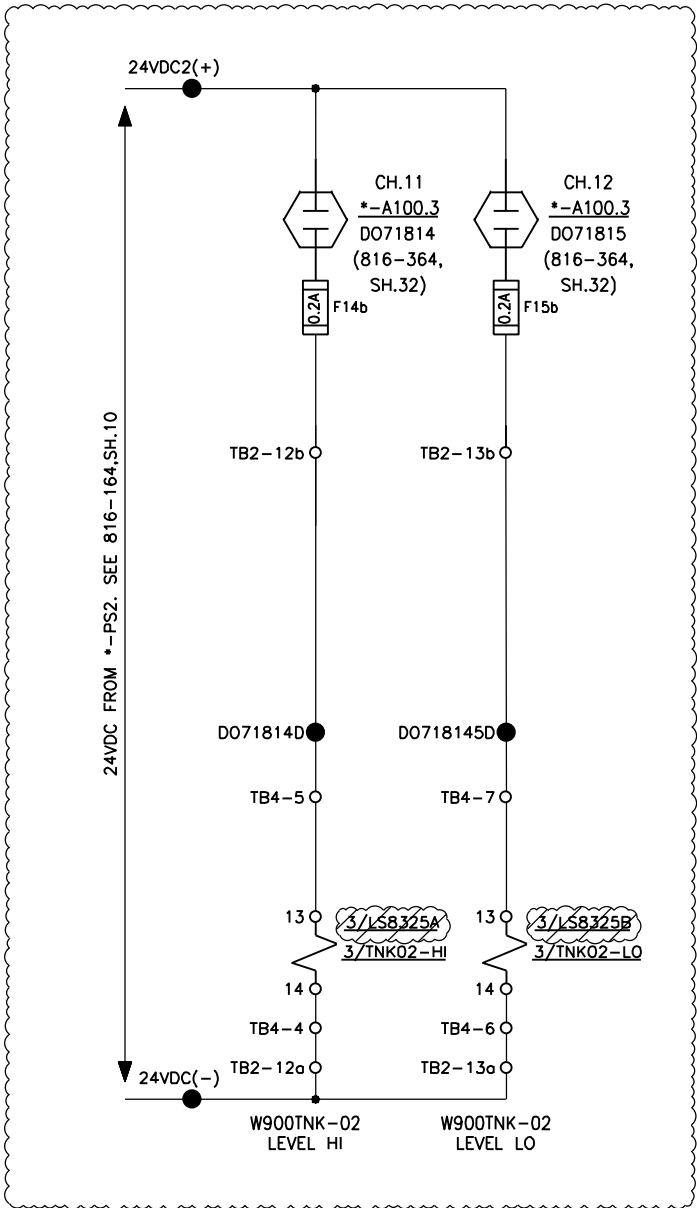


- NOTES:-
1. ALL DEVICES WITHOUT LOCATION MARKINGS ARE LOCATED IN EE106PNLA700
 2. LOCATION SYMBOLS:
□ LOCALLY MOUNTED
 3. LAST USED WIRE NO. 6-FD18. UNUSED 3-FD18, 4-FD18
 4. * - W100PLC
 5. CONTACT W100PLC-A100.3,CH.11 CLOSES WHEN WATER LEVEL IN TANK REACHES 100%. CONTACT OPENS WHEN WATER LEVEL IS BELOW 100%.
 6. CONTACT W100PLC-A100.3,CH.12 CLOSES WHEN WATER LEVEL IN TANK IS BELOW 36%. CONTACT OPENS WHEN WATER LEVEL IS ABOVE 90%.

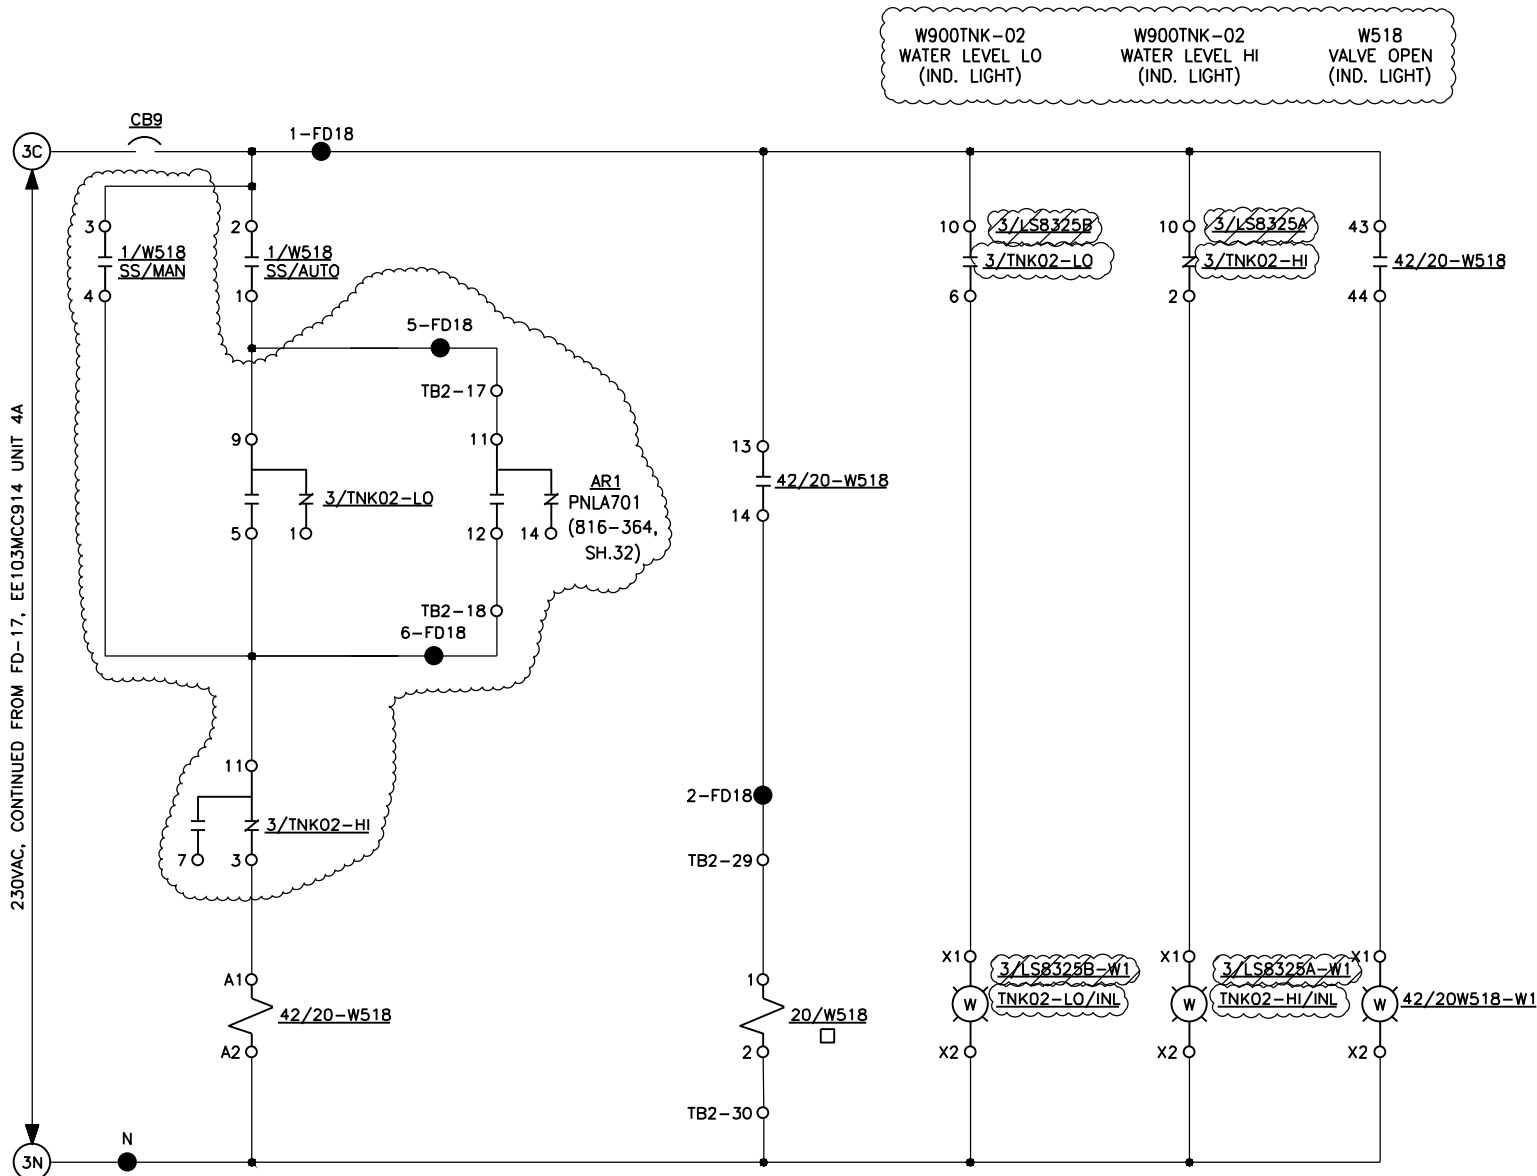

ZKP
2024-1061

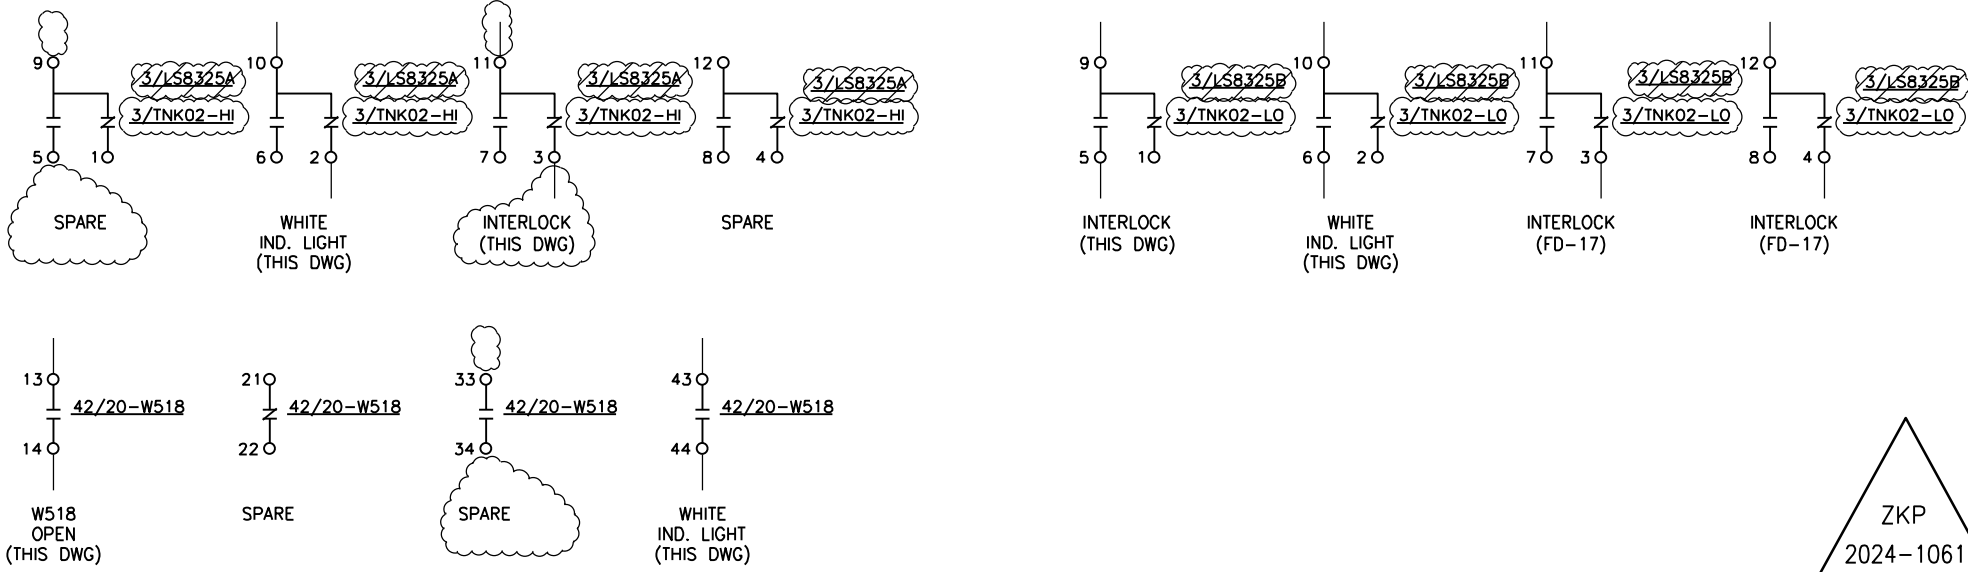

1. Interim Dwg. No.:	B-208-060-18-0-IB
Interim Sketch No.:	N/A
2. Design Mod. No.:	ZKP 2024-1061
3. Drawing Rev. No.:	0
4. New Drawing No.:	N/A
5. Resp. Eng.:	M. SEGULA Date: 03.2026
6. Checker:	B. BAS Date: 03.2026

ZKP
2024-1061

Original Design Firm: SIPRO INŽENIRING d.o.o.
Replaced Manual Drawing: N/A
Last Revision And Date: N/A

THIS IS A CAD DRAWING AND SHOULD NOT BE REVISED OR MODIFIED MANUALLY

0	02.2022	P.V.	ISSUED PER 1056-NA-L	R.P.	B.P.
NO.	DATE	BY	REVISION	CKD. BY	LE APPR.

NUKLEARNA ELEKTRARNA KRSKO NUCLEAR POWER PLANT KRSKO				
ELECTRICAL ELEMENTARY – DIAGRAM				
SUMP DISCHARGE SYSTEM				
OSC W900TNK-02 CONTROL				
DESIGN ENGINEERING				
		NUCLEAR POWER PLANT KRSKO KRSKO, SLOVENIA		
MADE		CHECKED		LE APPROVAL
1.	P. VINTAR	2.	R. PETAN	3. B. PEVEC
REFERENCE DRAWINGS: SS-211-060, E-5, E-6, <u>K-7 & W-6</u>				
SCALE		B-208-060		FD 18 0
DRAWING NUMBER			SYSTEM	SH.NO. REV.

FILE: 20806018.DWG SPREJEL:-----