


FILE: 21006002.DWG, SPREJEL:

NOTES:

- FOR INTERNAL WRING OF EE106PNLA701
SEE B-208-060, 816-164.sh.10 AND 816-364 SERIES
OF DRAWINGS AS REFERENCED ON WIREMARKS
- TERMINAL BLOCKS MARKED WITH ASTERISK (*)
CONTAIN 0.2A FUSE

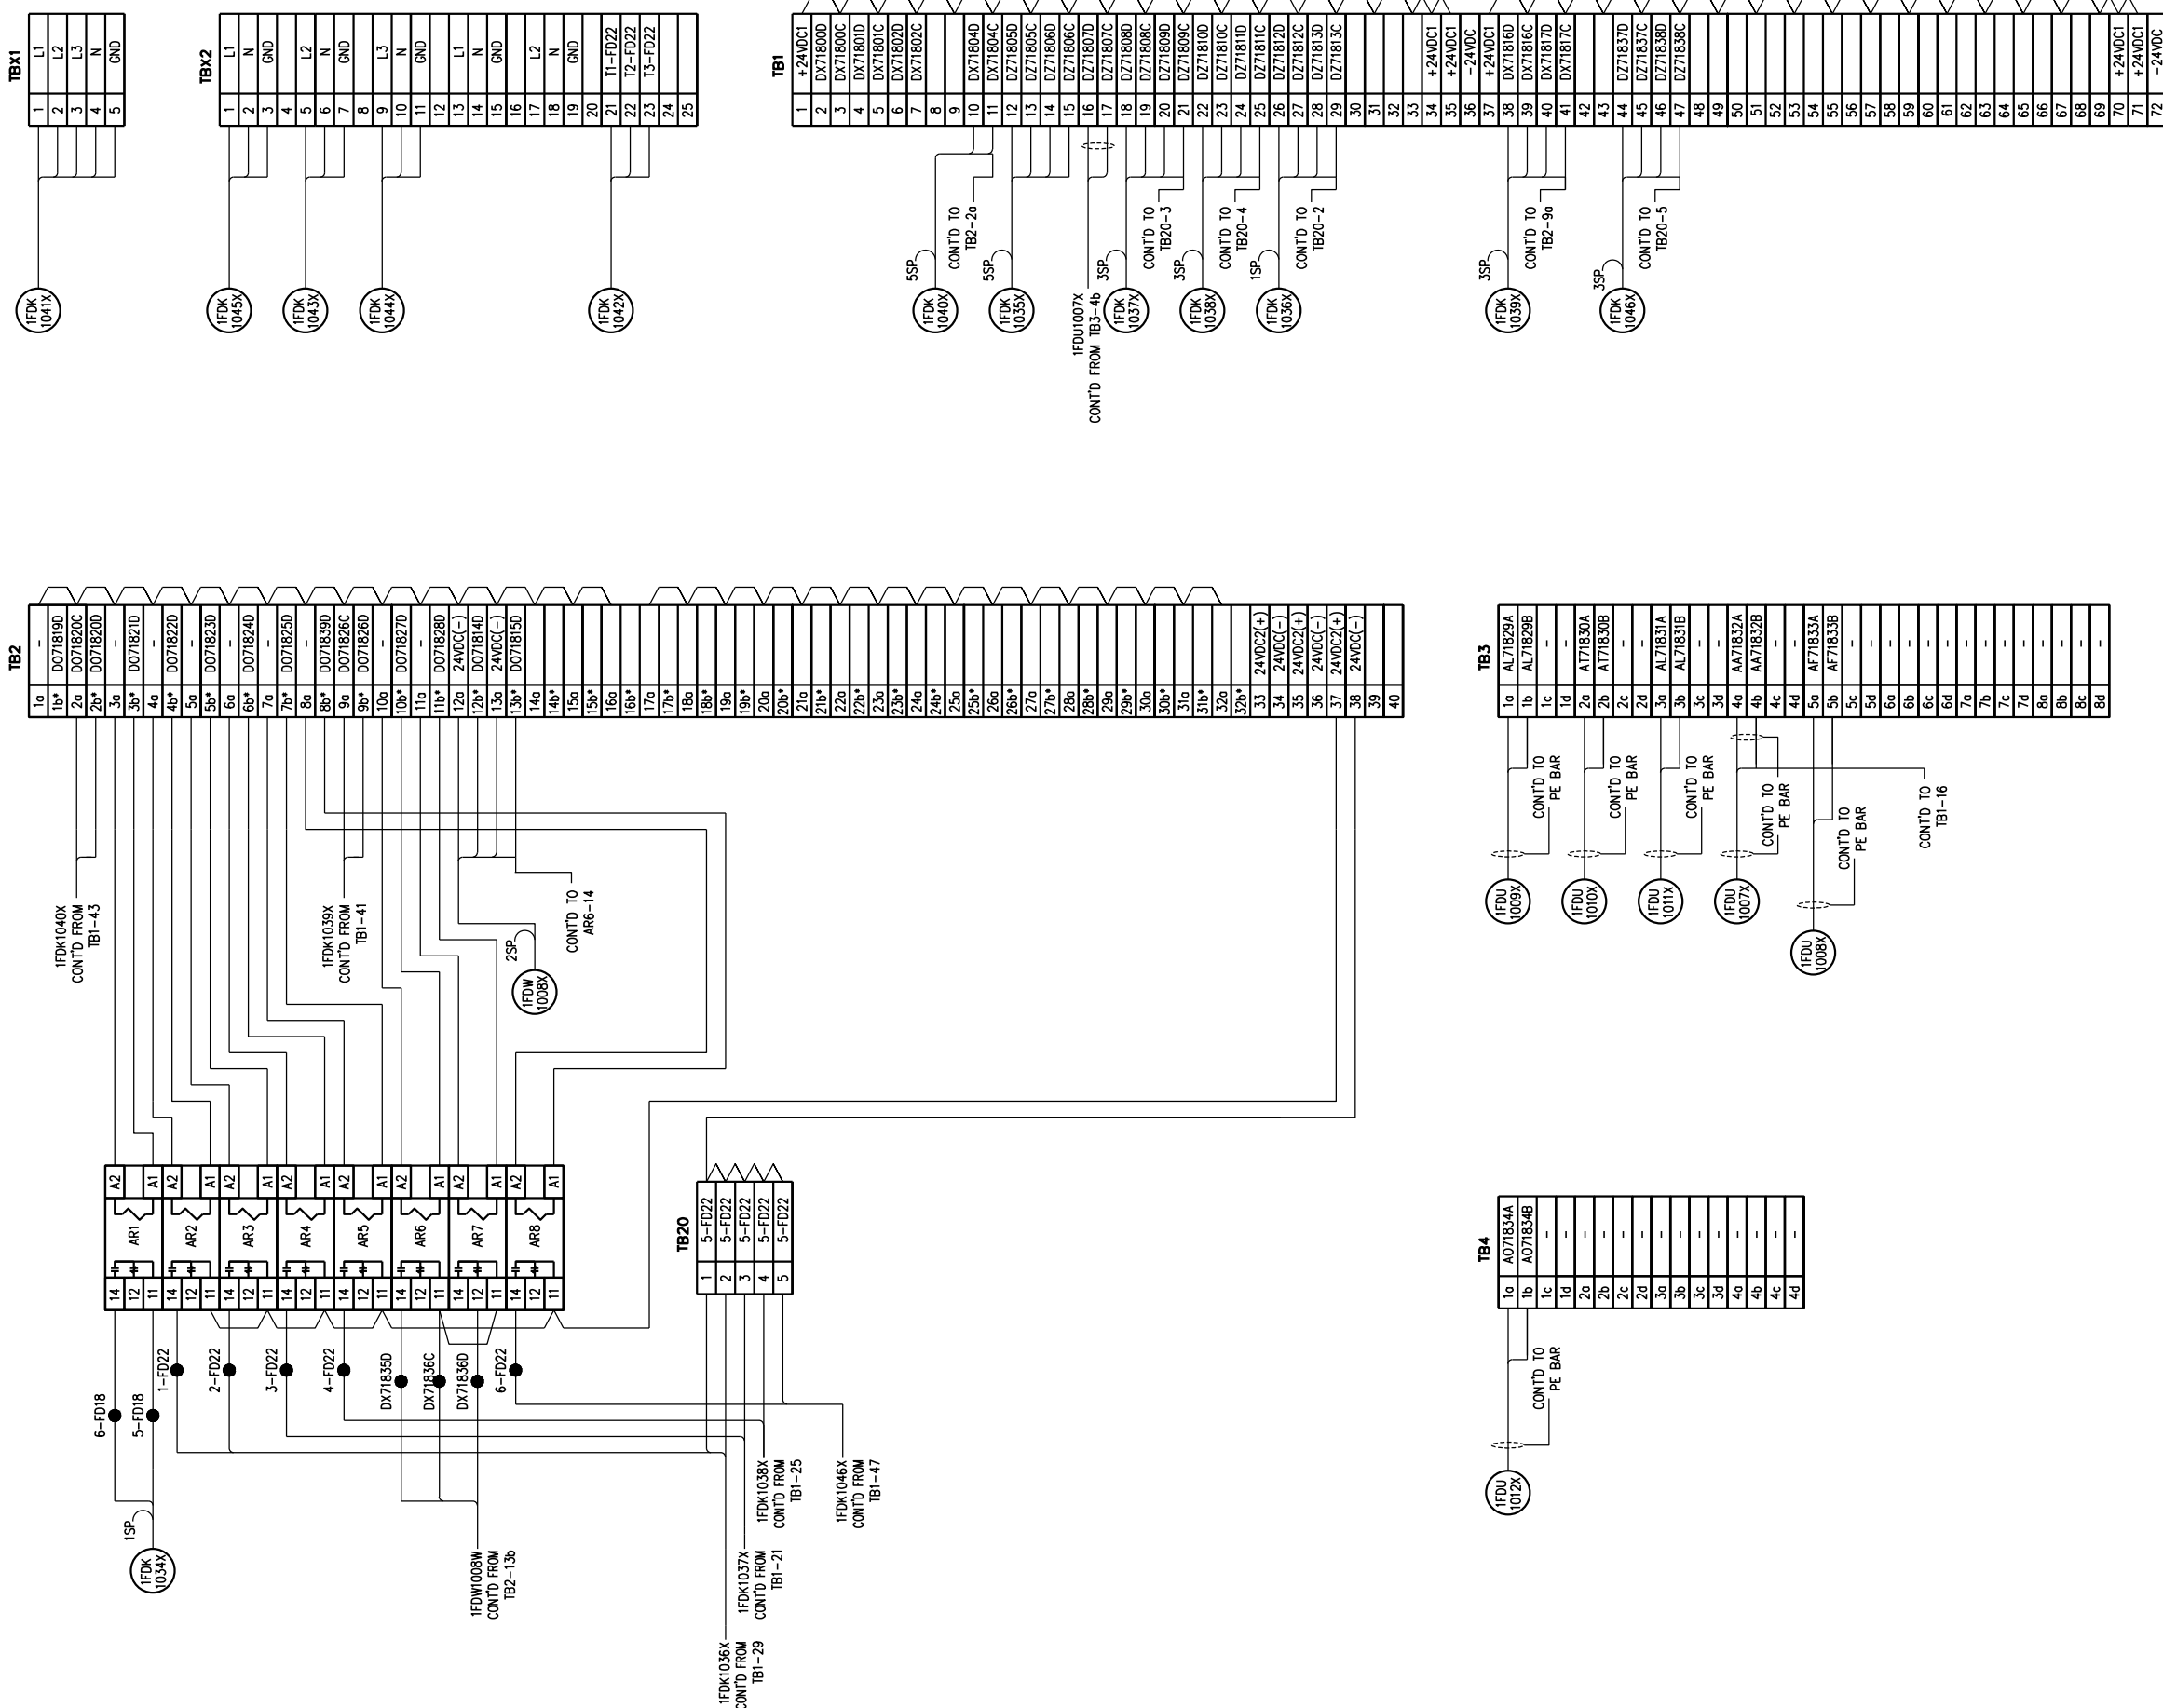

Original Design Firm: SIRO-INZENIRING d.o.o.
Replaced Manual Drawing: N/A
Lost Revision And Date: N/A

THIS IS A CAD DRAWING AND SHOULD NOT BE REVISED OR MODIFIED MANUALLY.

NO.	DATE	BY	REVISION	QCD BY	LE APPR.

NUKLEARNA ELEKTRARNA KRŠKO NUCLEAR POWER PLANT KRŠKO	
ELECTRICAL	
OSC. WATER SYS. MONITORING	
EE106PNLA701 CONTROL PANEL	
DESIGN ENGINEERING	
MADE	CHECKED
1. M. SEGULA	2. R. PETAN
LE APPROVAL	
3. B. PEVEC	
REFERENCE DRAWINGS:	
SCALE: N/A	
C-210-060	
DRAWING NUMBER	
SYSTEM	
SKIN	
REV.	