

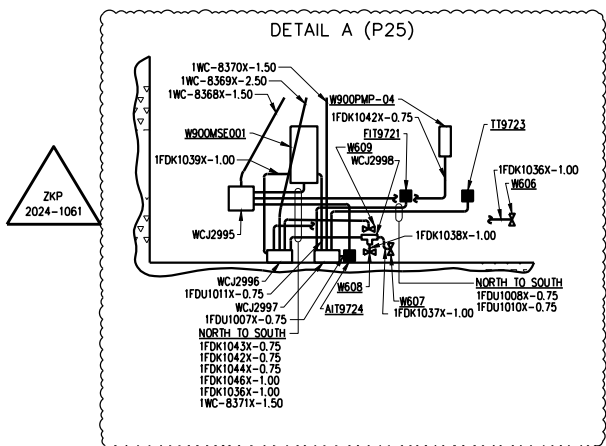
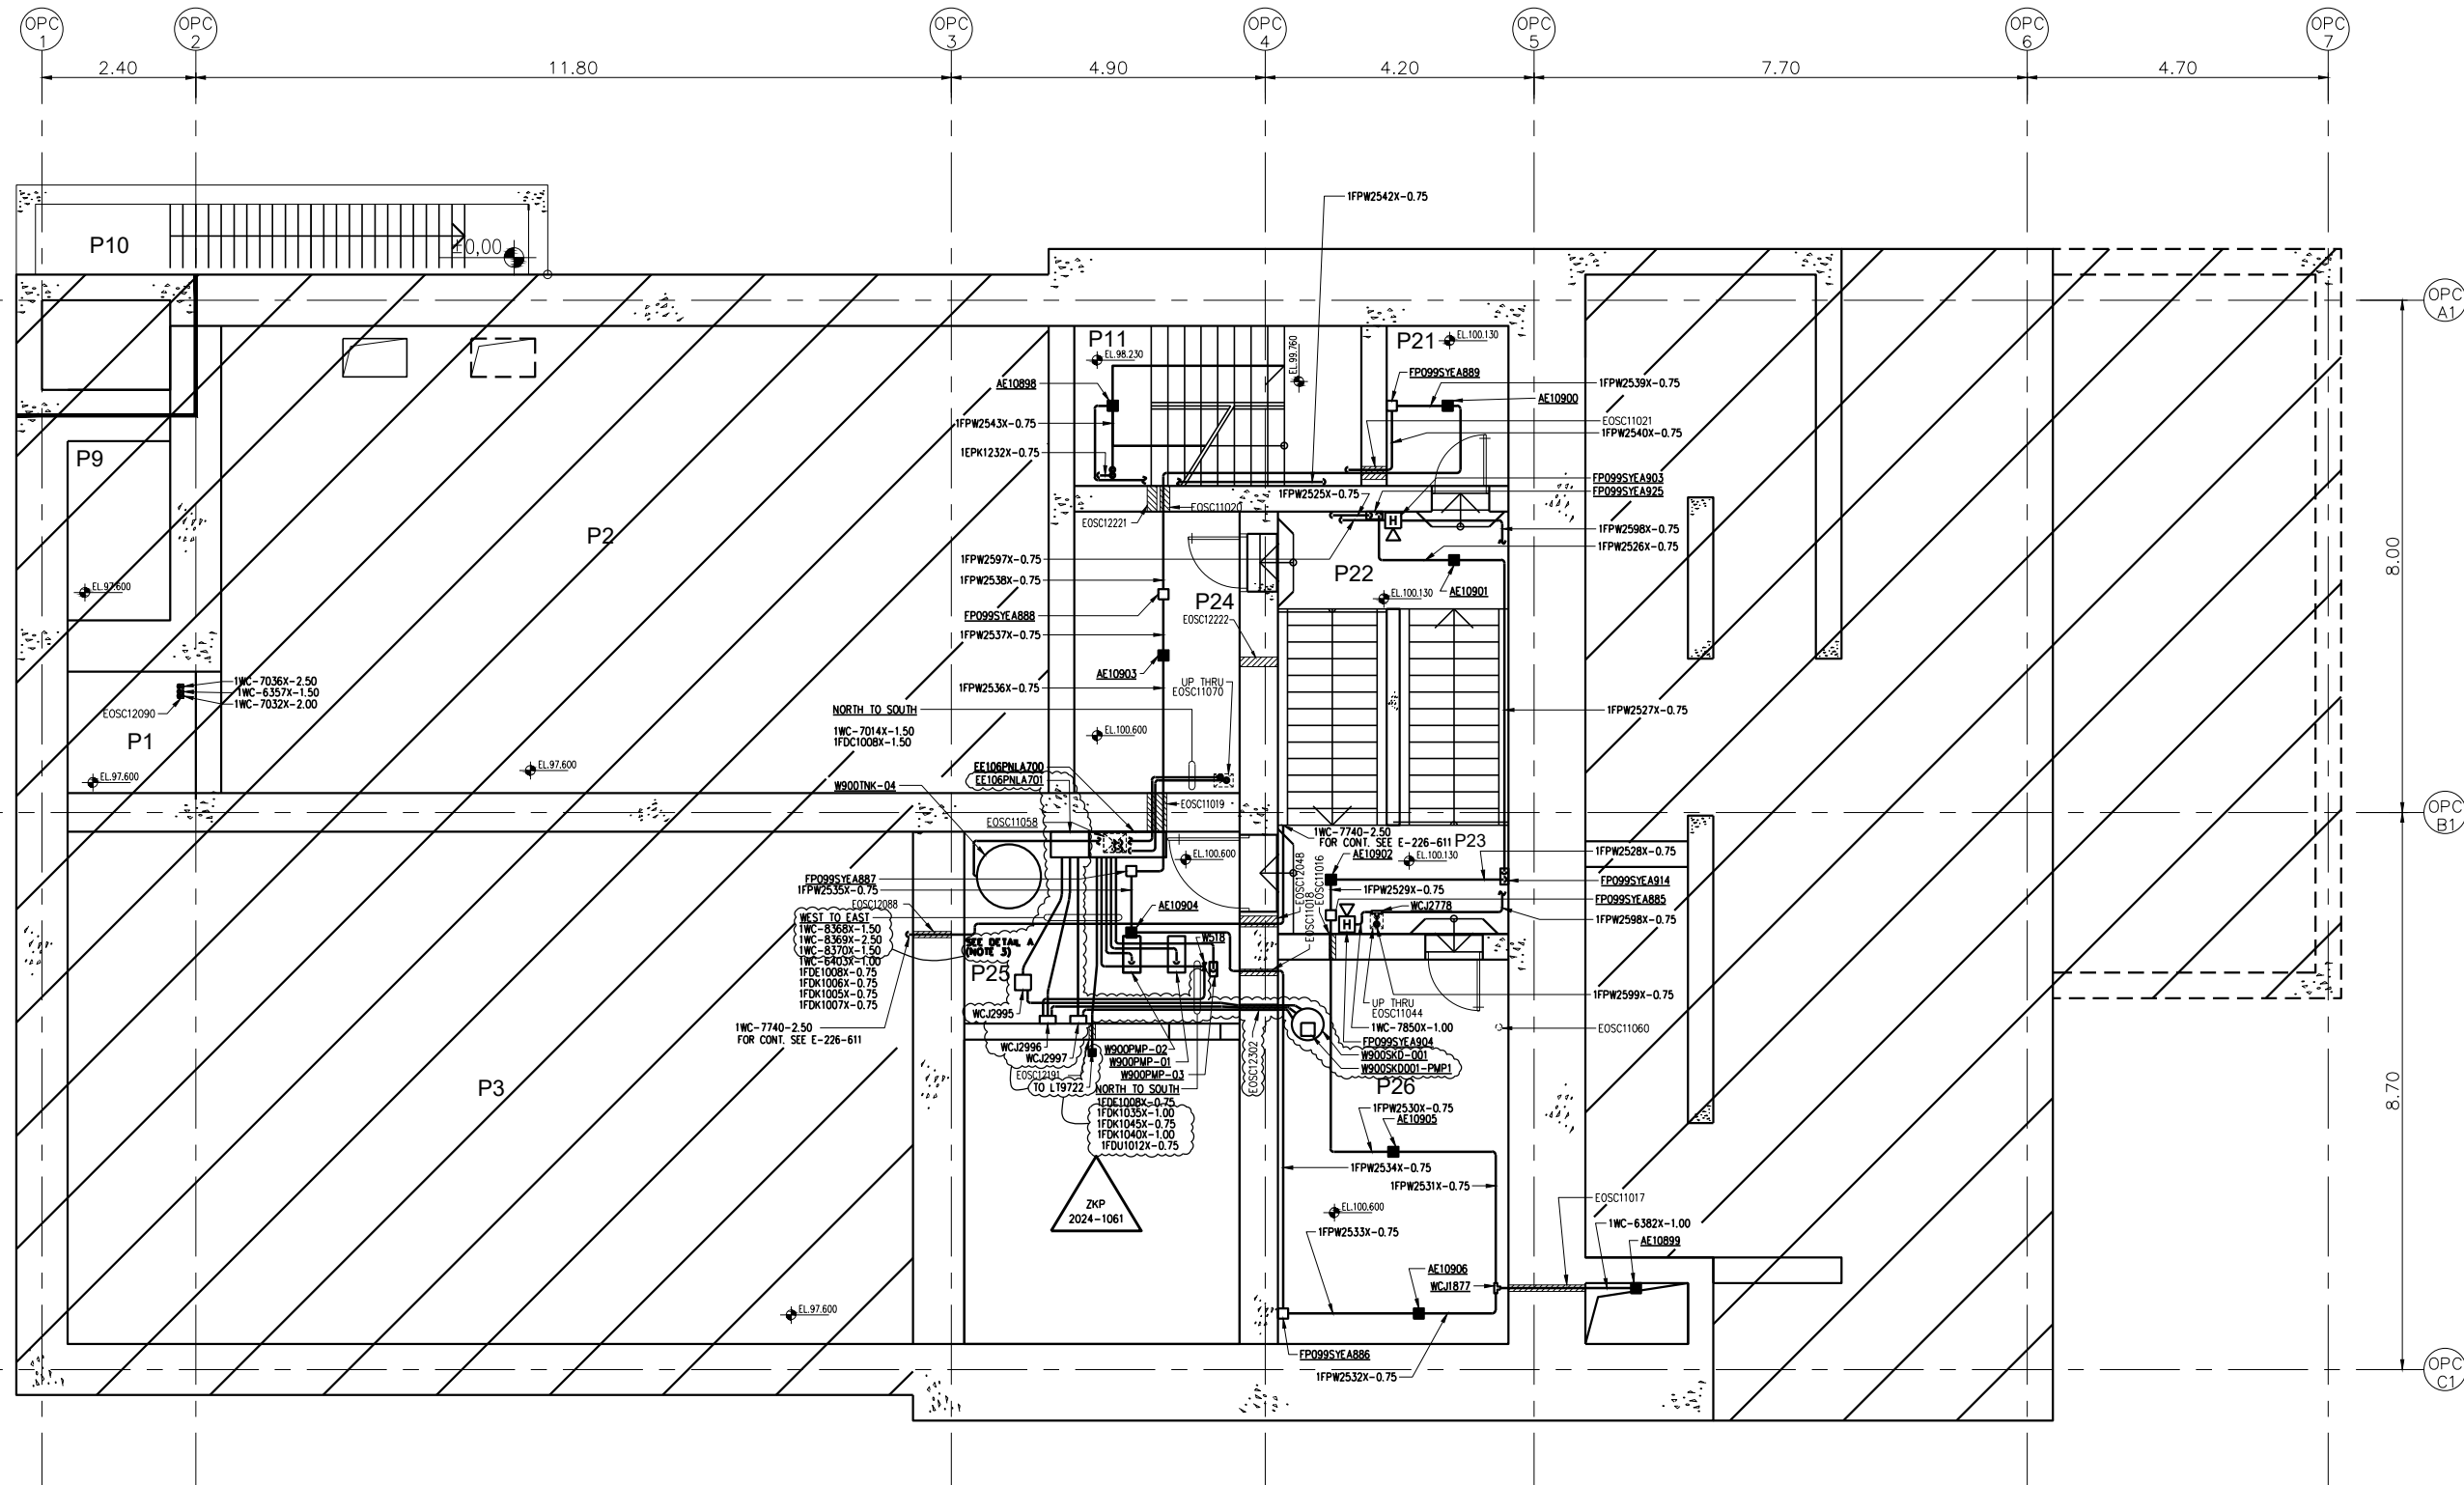


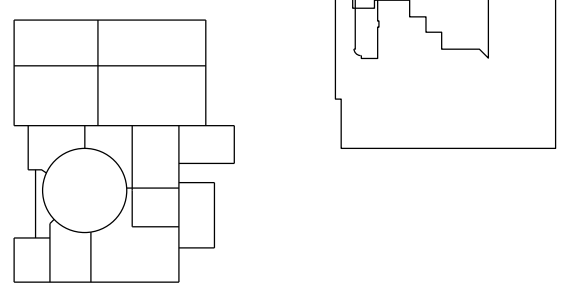

- VIA IWC-6382X
IFPW2531X
IFPW2532X
- VIA IWC-6403X
IFDE1006X
IFDE1007X
- VIA IWC-7014X
IEPK1233X
IEPK1234X
- VIA IWC-7740X
SPARE (ONIC)
- VIA IWC-7850X
IFPW2598X
IFPW2599X
- VIA IWC-8352X
TCHW1970X
TCHW1971X
TCHW1972X
TCHW1980X
TCHW1981X
TCHW1982X
- VIA IWC-7032X
IRMU1098X
IRMU1099X
IRMU1000X
- VIA IWC-7036X
SPARE (ANTENNA)
- VIA IWC-8368X
IFDK1042X
IFDK1043X
IFDK1044X
IFDK1045X
- VIA IWC-8369X
IFDK1035X
IFDK1036X
IFDK1037X
IFDK1038X
IFDK1039X
IFDK1040X
IFDK1046X
- VIA IWC-8370X
IFDU1007X
IFDU1008X
IFDU1010X
IFDU1011X
IFDU1012X
- VIA IWC-8371X
IFDK1037X
IFDK1038X

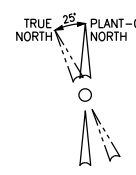

- NOTES
- FOR VA, EP SYSTEMS SEE: E-226-612A
FOR CABLE TRAYS SEE: E-226-622
FOR ROOM DETAILS SEE: E-204-416
 - FOR COMMUNICATION SYSTEM CABLES SEE: E-218-327
E-226-611, E-226-611A AND E-226-621
 - ADDITIONAL EQUIPMENT AND CONDUITS IN ROOM P25 SHOWN IN DETAIL A.

1. Interim Desig. No.: E-226-612-D-1A	Interim Design No.: N/A
2. Design Mod. No.: ZKP 2024-1061	Design Mod. No.: N/A
3. Drawing Rev. No.: 0	Drawing Rev. No.: N/A
4. New Drawing No.: N/A	New Drawing No.: N/A
5. Resp. Eng.: E. BUS	Date: 08.2022
6. Checker: M. SEGULA	Date: 08.2022

Original Design Firm: SIPRO INŽENIRING D.O.O.	
Replaced Manual Drawing: N/A	
Last Revision And Date: N/A	
THIS IS A CAD DRAWING AND SHOULD NOT BE REVISED OR MODIFIED MANUALLY	
DATE	BY
0. 09.2022	M.S.
REVISION	
DOW. BY DATE	

NUKLEARNA ELEKTRARNA KRSKO NUCLEAR POWER PLANT KRSKO	
ELECTRICAL	
CONDUIT AND CABLE TRAY LAYOUT	
OSC BLDG MEZZAZINE FLOOR - EL.97.60-102.65	
DESIGN ENGINEERING	
MADE M. SEGULA	CHECKED R. PETAN
1. M. SEGULA	2. R. PETAN
3. B. PEVEC	LE APPROVAL
REFERENCE DRAWINGS:	
SCALE	
DRAWING NUMBER	
SYSTEM	
SH. NO.	
REV.	