

Replaced Manual Drawing: N/A
Original Design Firm: SIPRO
Last Revision And Date: N/A

FILE: 211060E6.DWG, SPREJEL:

LEGEND:

CIRCUIT No. -
No. COND & WIRE SIZE -
VOLTS -
B/M ITEM -
CONDUIT SIZE & TYPE -
NATURE OF CIRCUIT - WIRE MARKS -


NUKLEARNA ELEKTRARNA KRSKO		MADE		CHKD		DRAWING NUMBER				REV
NUCLEAR POWER PLANT KRSKO						SS-211-060				A
ELECTRICAL BLOCK DIAGRAMS		PDS		ENG INTERF		DESIGN ENGINEERING				
SYSTEM - FD						NUCLEAR POWER PLANT KRSKO				
SUMP DISCHARGE SYSTEM						KRSKO, SLOVENIA				
		SCALE		W.O.		ENGINEER APPROVAL				
		REV		MADE		CH		PDS		DATE
		A		M.S.		R.P.		B.P.		02.2022

THIS IS A CAD DRAWING AND SHOULD NOT BE REVISED OR MODIFIED MANUALLY

CODE E

SHEET E-6

REFERENCE: B-208-060 Sh. FD-18

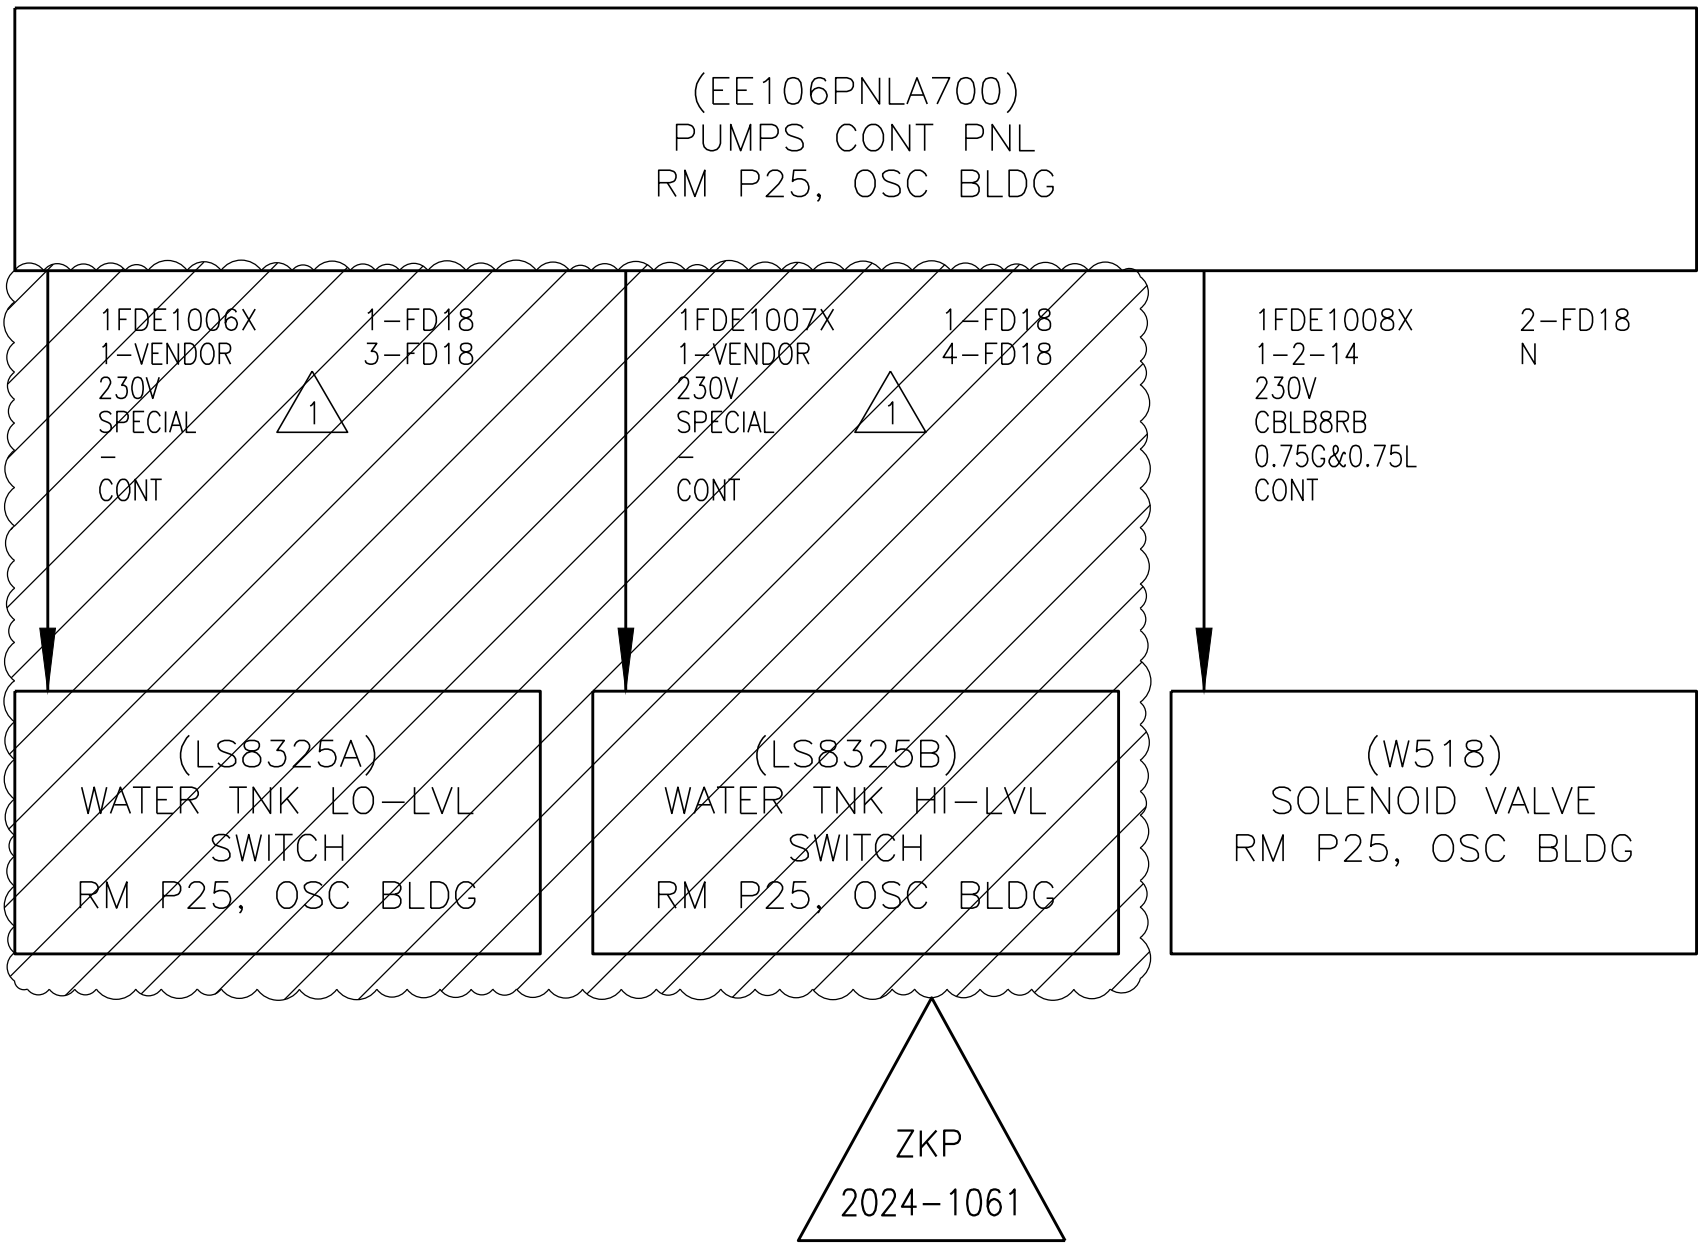

VIA 1WC-6403X
1 SS-211-151, Sh. (-)1207

ZKP
2024-1061

1. Interim Dwg. No.:	SS-211-060-E6-0-IA
Interim Sketch No.:	N/A
2. Design Mod. No.:	ZKP 2024-1061
3. Drawing Rev. No.:	0
4. New Drawing No.:	N/A
5. Resp. Eng.:	M.ŠEĞULA Date: 07.2025
6. Checker:	A. MAJERIĆ Date: 07.2025

BLANK CIRCUITS -
NEXT CIRCUIT - NONE

REV	MADE	CH	APPS	DATE
A	M.S.	R.P.	B.P.	02.2022
ISSUED PER : MOD. 1056-NA-L				