

Replaced Manual Drawing:
Original Design Firm:
Last Revision And Date:

N/A
SIPRO INŽENIRING d.o.o.
N/A

SPREJEL:

FILE: 211060U3-IA.dwg

LEGEND:

CIRCUIT No. —
No. COND & WIRE SIZE —
VOLTS —
B/M ITEM —
CONDUIT SIZE & TYPE —
NATURE OF CIRCUIT —

1. Interim Dwg. No.:	SS-211-060-U3-IA
Interim Sketch No.:	N/A
2. Design Mod. No.:	ZKP 2024-1061
3. Drawing Rev. No.:	N/A
4. New Drawing No.:	SS-211-060, SH: U-3
5. Resp. Eng.:	M.ŠEĞULA Date: 07.2025
6. Checker:	A.MAJERIČ Date: 07.2025



WIRE MARKS —

NUKLEARNA ELEKTRARNA KRSKO
NUCLEAR POWER PLANT KRSKO

ELECTRICAL BLOCK DIAGRAM

SYSTEM — FD

SUMP DISCHARGE SYSTEM



MADE	CHKD	DRAWING NUMBER		REV
		SS-211-060		
PDS		ENG INTERF		DESIGN ENGINEERING
		1.	2.	NUCLEAR POWER PLANT KRSKO
				KRSKO, SLOVENIA
SCALE				
W.O.		ENGINEER APPROVAL		
REV	MADE	CH	PDS	APP
				DATE
				REV
				MADE
				CH
				PDS
				APP
				DATE

THIS IS A CAD DRAWING AND SHOULD NOT BE REVISED OR MODIFIED MANUALLY

CODE — U

SHEET U-3

REFERENCE: —

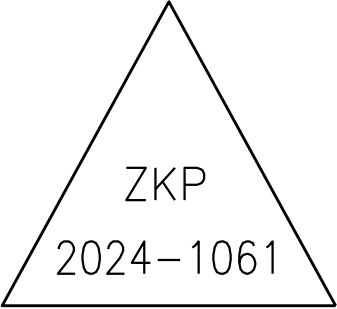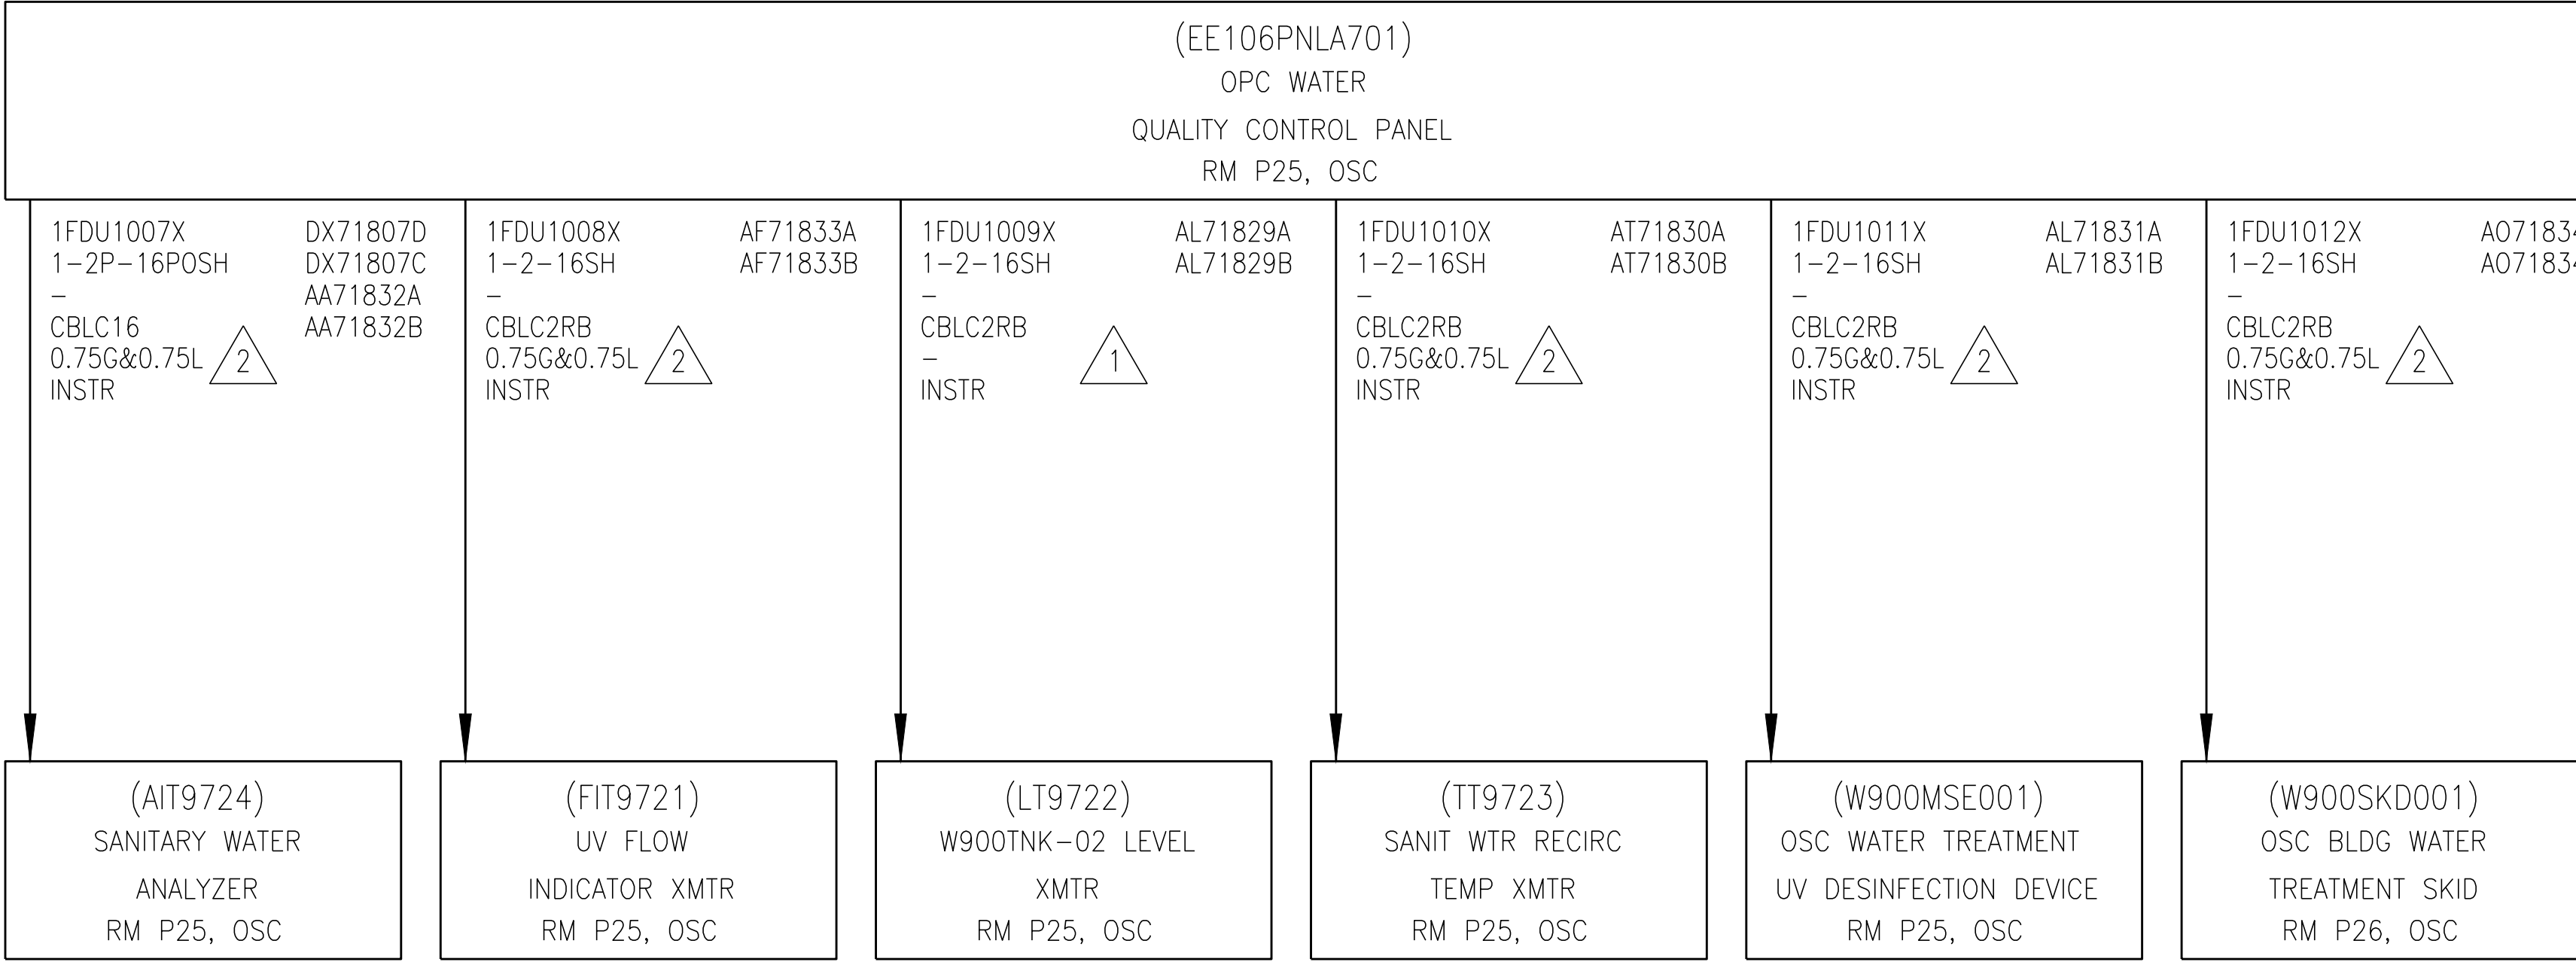

1 VIA 1WC-6403X
SS-211-151 SH(-)1207
2 VIA 1WC-8370X
SS-211-151 SH(-)1601

BLANK CIRCUITS — NONE
NEXT CIRCUIT — —

REV	MADE	CH	APPS	DATE
ISSUED PER:				