

Replaced Manual Drawing:
Original Design Firm:
Last Revision And Date:

N/A
IBE
N/A

FILE: 2111511207 DWG, SPREJEL:

LEGEND:

CIRCUIT NO. -
NO. COND & WIRE SIZE -
VOLTS -
B/M ITEM -
CONDUIT SIZE & TYPE -
NATURE OF CIRCUIT -

WIRE MARKS

NUKLEARNA ELEKTRARNA KRSKO
NUCLEAR POWER PLANT KRSKO

ELECTRICAL BLOCK DIAGRAMS
SYSTEM - WC
WIREWAY AND CONDUIT SYSTEM


DATE	CHKD	DRAWING NUMBER	REV
		SS-211-151	B
PDS		END TRSF	DESIGN ENGINEERING
1.	2.		NUCLEAR POWER PLANT KRSKO
SCALE			KRSKO, SLOVENIA
W.O.		ENGINEER APPROVAL	DATE
REV	MADE	CH	PDS
A	IBE	D.I.	B.P.

THIS IS A CAD DRAWING AND SHOULD NOT BE REVISED OR MODIFIED MANUALLY

CODE (-)

SHEET (-) 1207

REFERENCE:

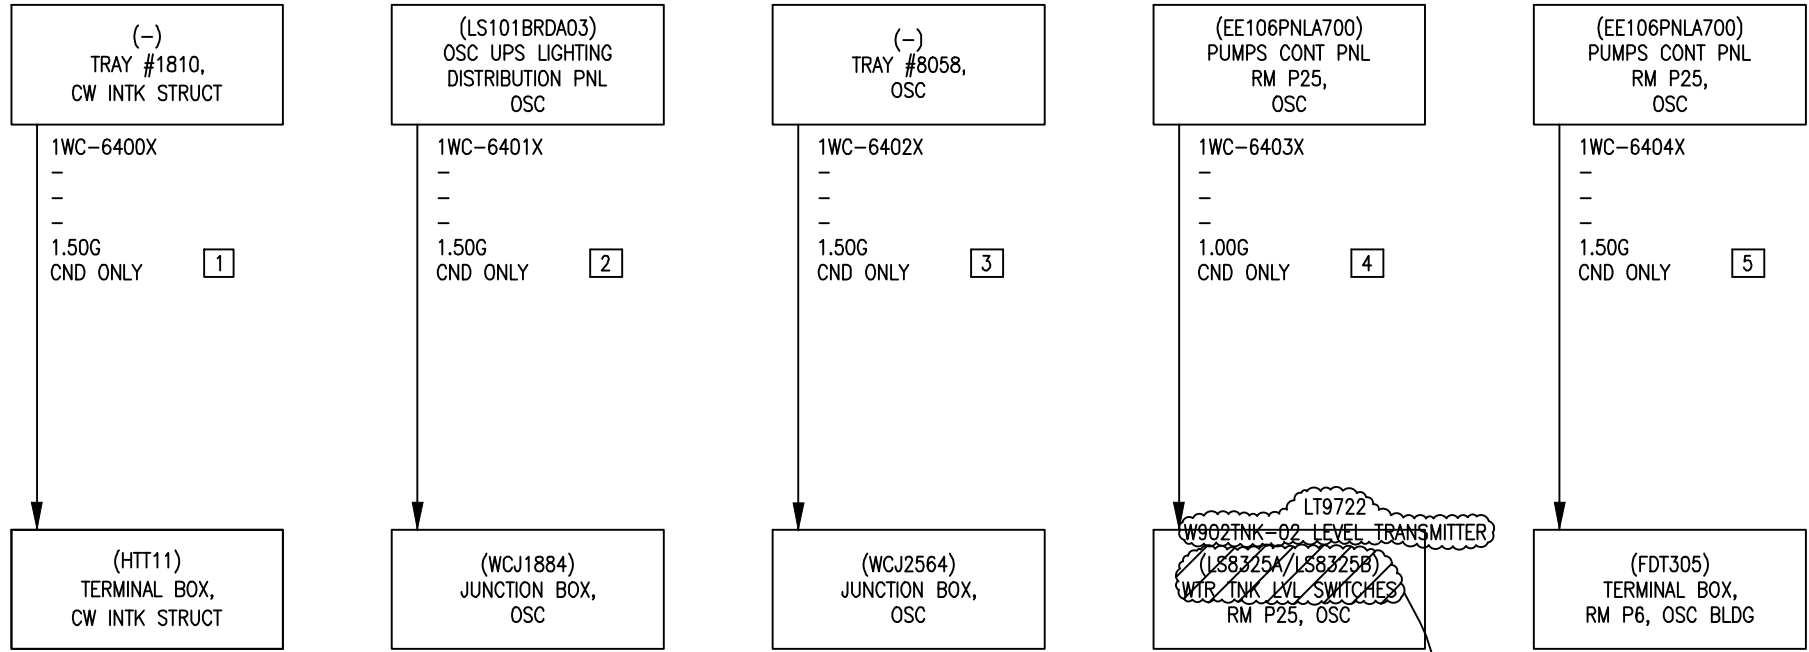

- 1 CONTAINS: 1HTK1259X, 1HTK1265X
- 2 CONTAINS: 1PCK1076X, 1PCK1077X
- 3 CONTAINS: 1VAK1459X, 1VAK1460X
- 4 CONTAINS: 1FDE1006X, 1FDE1007X, 1FDE1009X
- 5 CONTAINS: 1FDK1032X, 1FDK1033X

REV	MADE	CH	APPS	DATE
A	IBE	D.I.	B.P.	19.08.17
ISSUED PER: MOD 1044-CW-L				
REV	MADE	CH	APPS	DATE
B	M.S.	R.P.	B.P.	12.2021
REV'D PER MOD. 1056-NA-L & FDCR15-3				



1. Interim Dwg. No.:	SS-211-151-1207-B-IB
Interim Sketch No.:	N/A
2. Design Mod. No.:	ZKP 2024-1061
3. Drawing Rev. No.:	B
4. New Drawing No.:	N/A
5. Resp. Eng.:	M. SEGULA
6. Checker:	A. MAJERIC
Date:	06.2026

BLANK CIRCUITS - 1WC-6402
NEXT CIRCUIT - 1WC-6405