

Replaced Manual Drawing:
Original Design Firm:
Last Revision And Date:

N/A
SIPRO INŽENIRING d.o.o.
N/A


FILE: 2111511600-IA.DWG, SPREJEL:

REV	MADE	CH	PC-CKS	APPS	DATE
-	-	-	-	-	-
ISSUED PER:					MOD -

LEGEND:

CIRCUIT No. -
No. COND & WIRE SIZE -
VOLTS -
B/M ITEM -
CONDUIT SIZE & TYPE -
NATURE OF CIRCUIT -

WIRE MARKS -

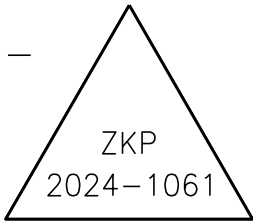


1. Interim Dwg. No.:	SS-211-151-1600-IA
Interim Sketch No.:	N/A
2. Design Mod. No.:	ZKP 2024-1061
3. Drawing Rev. No.:	N/A
4. New Drawing No.:	SS-211-151 sh. 1600
5. Resp. Eng.:	M. ŠEGULA Date: 08.2025
6. Checker:	F. RUS Date: 08.2025


NUKLEARNA ELEKTRARNA KRSKO NUCLEAR POWER PLANT KRSKO	MADE	CHKD	DRAWING NUMBER					REV				
			SS-211-151					-				
ELECTRICAL BLOCK DIAGRAM	PDS		ENG INTERF		DESIGN ENGINEERING							
	1.		2.		NUCLEAR POWER PLANT KRSKO							
SYSTEM – WC	SCALE		KRSKO, SLOVENIA									
WIREWAY AND CONDUIT SYSTEM	W.O.		ENGINEER APPROVAL					DEPT.	DATE			
	REV	MADE	CH	PC-CKS	APP	DATE	REV	MADE	CH	PC-CKS	APP	DATE

THIS IS A CAD DRAWING AND SHOULD NOT BE REVISED OR MODIFIED MANUALLY


CODE (-)
REFERENCE: SHEET (-) 1600

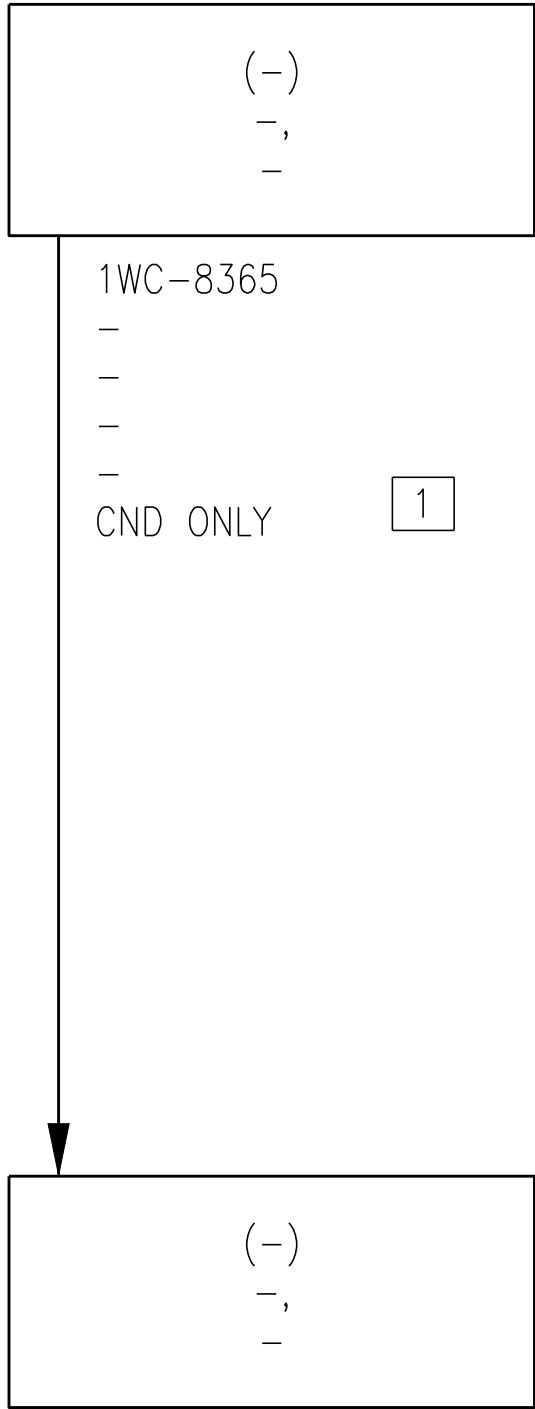


1 CONTAINS:

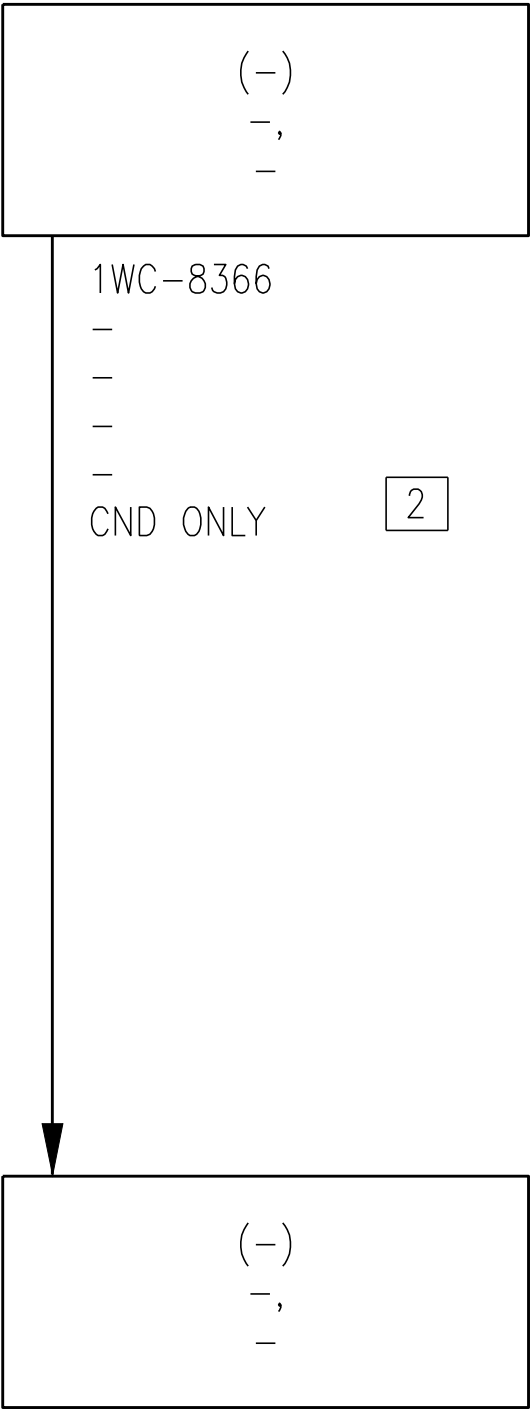

2 CONTAINS:

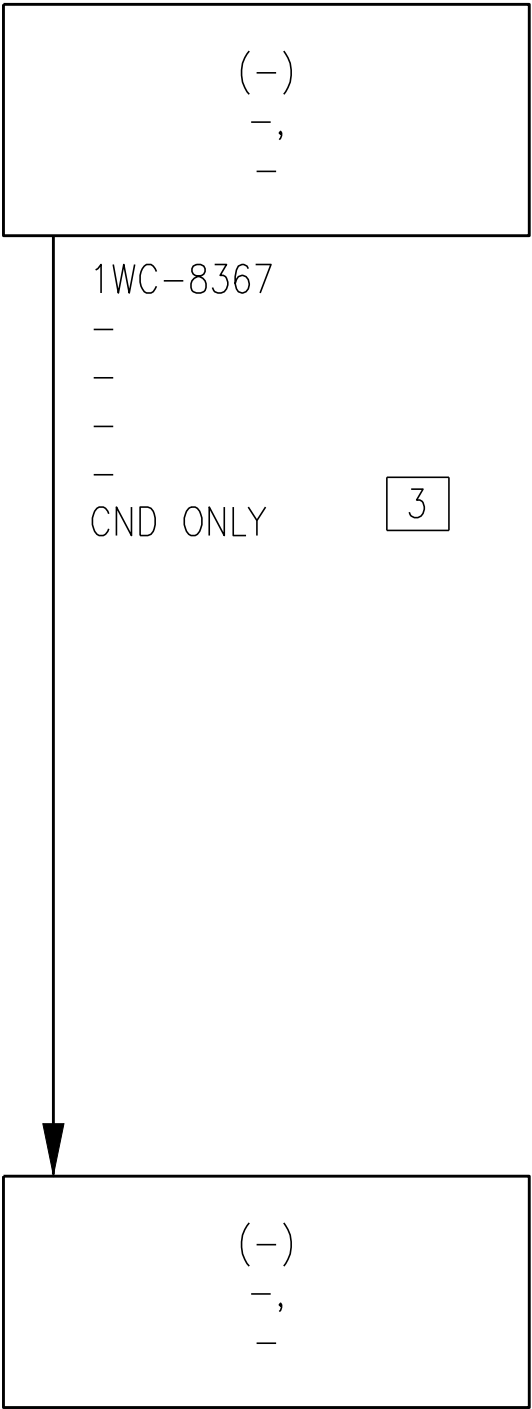

3 CONTAINS:

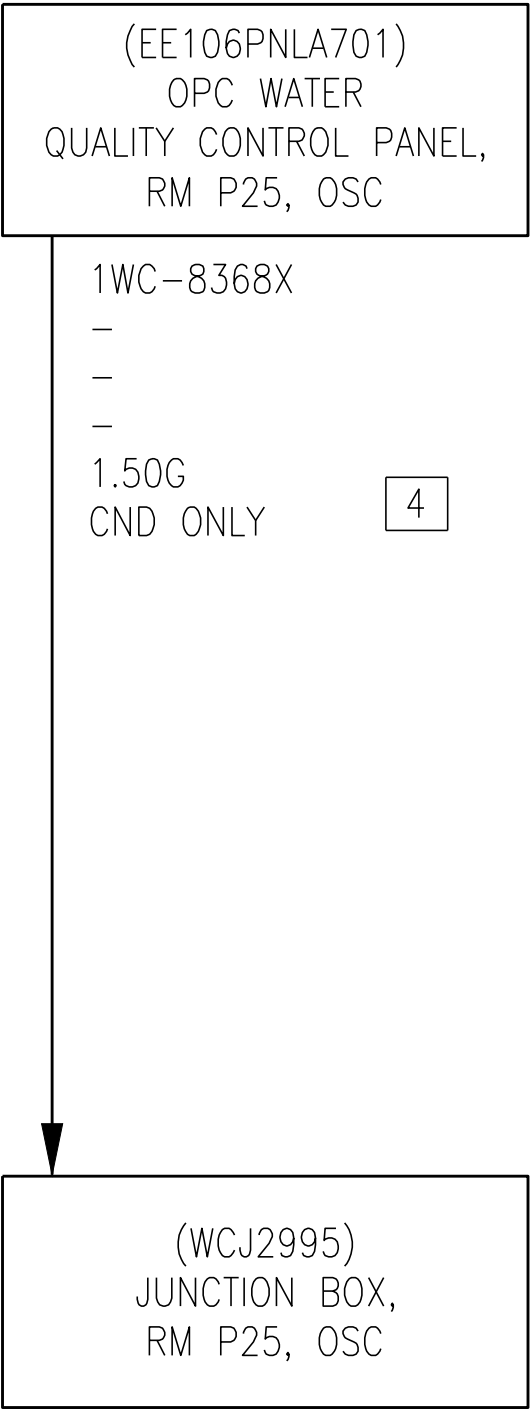

4 CONTAINS:
1FDK1042X
1FDK1043X
1FDK1044X
1FDK1045X



5 CONTAINS:
1FDK1035X
1FDK1036X
1FDK1037X
1FDK1038X
1FDK1039X
1FDK1040X
1FDK1046X

BLANK CIRCUITS- NONE
NEXT CIRCUIT- -