

G

F

E

D

C

B

A

G

F


E

D


C

B

A

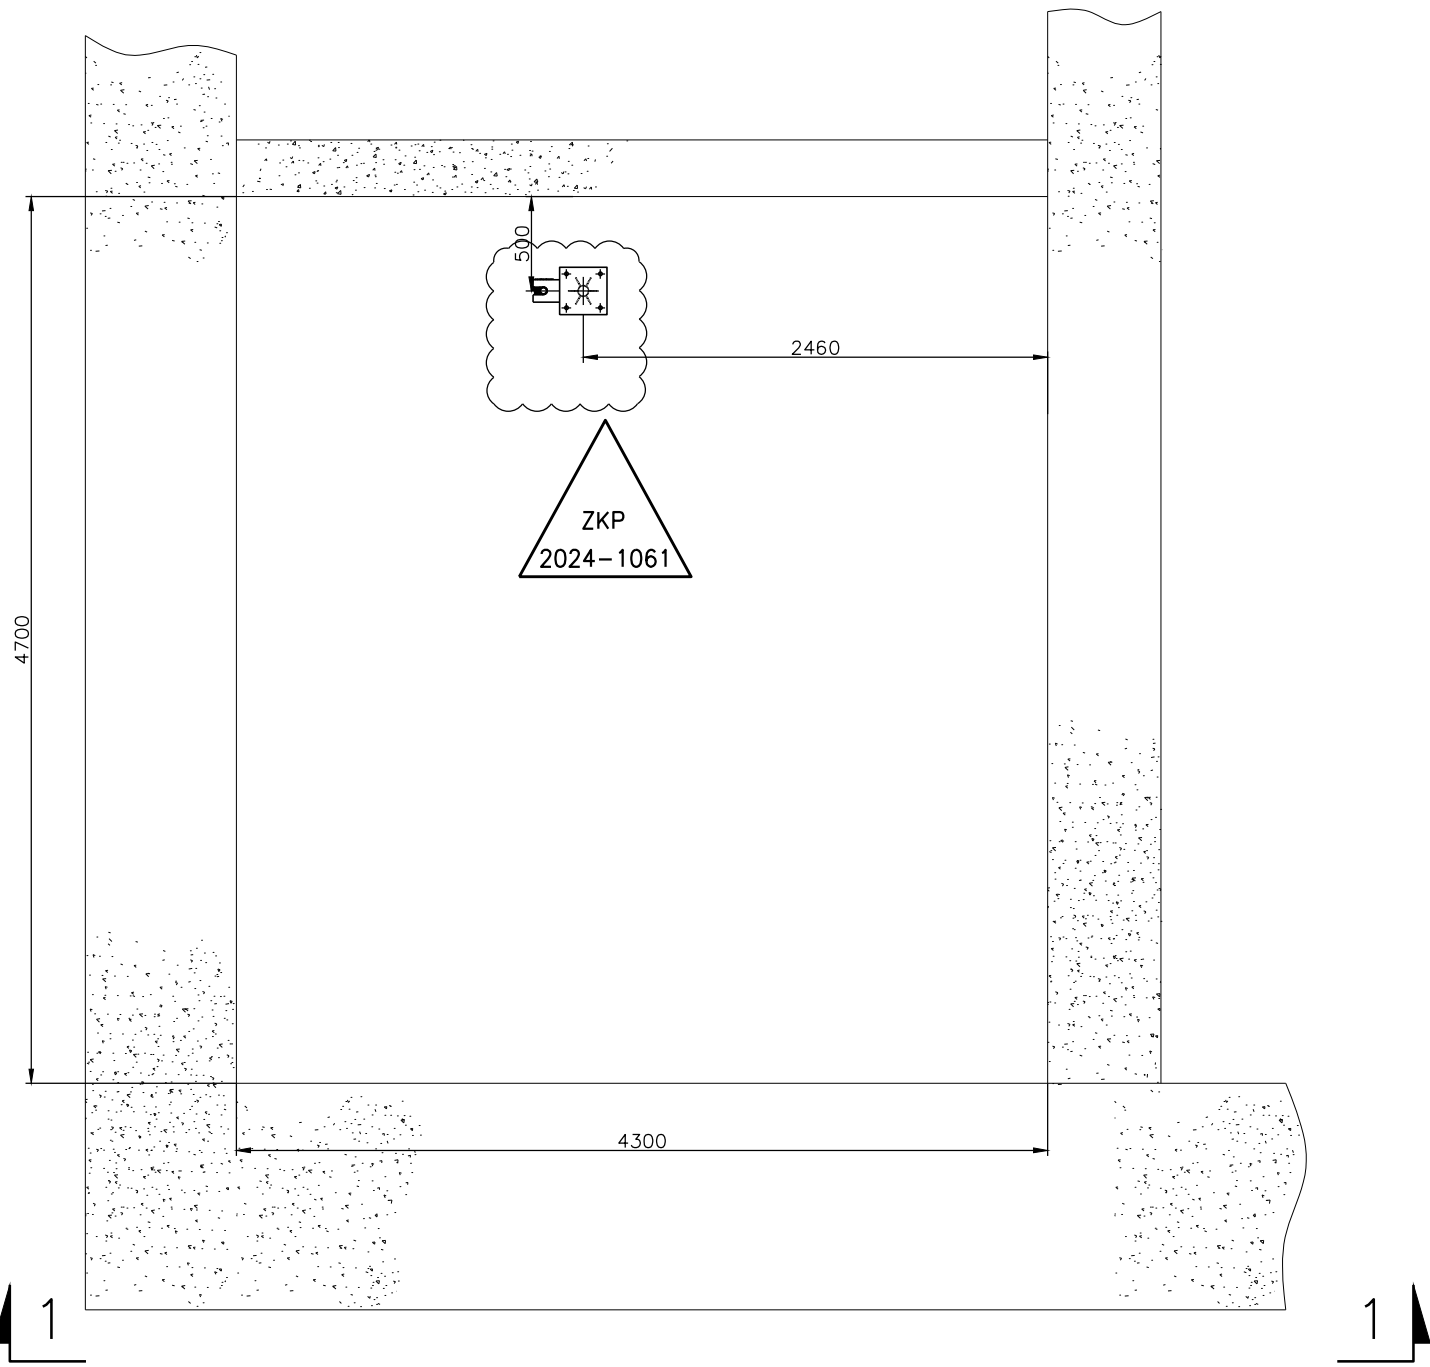


PLAN VIEW EL 101.850
(SCALE 1:40)

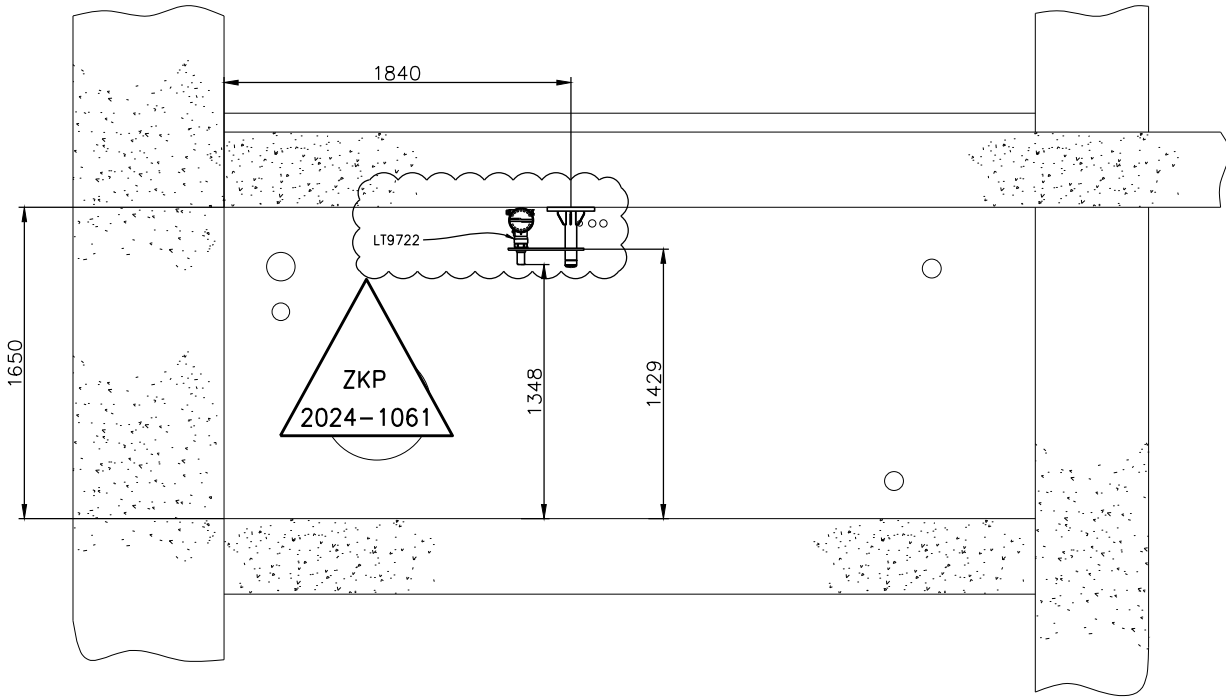

SECTION 1-1
(SCALE 1:40)

1. Interim Dwg. No.:	SIP-367-814-009-0-1A
Interim Sketch No.:	N/A
2. Design Mod. No.:	ZKP 2024-1061
3. Drawing Rev. No.:	0
4. New Drawing No.:	N/A
5. Resp. Eng.:	T. BROMŠE
6. Checker:	R. MLAKAR
Date:	18.07.2025

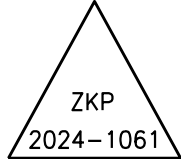

Original Design Firm: SIPRO d.o.o.
Replaced Manual Drawing: N/A
Last Revision And Date: N/A

THIS IS A CAD DRAWING AND SHOULD NOT BE REVISED OR MODIFIED MANUALLY

NO.	DATE	BY	REVISION	CKD.	BY	LE	APPR.
0	11.2021	K.Š.	ISSUED PER MOD. 1056-NA-L, FDCR 16	R.P.	R.P.		

NUKLEARNA ELEKTRARNA KRSKO NUCLEAR POWER PLANT KRSKO			
W900TNK-02, LT9722 INSTALLATION DETAIL			
DESIGN ENGINEERING			
NUCLEAR POWER PLANT KRSKO KRSKO, SLOVENIA			
MADE 1. K. ŠTERK	CHECKED 2. R. PETAN	LE APPROVAL 3. R. PLANINC	
REFERENCE DRAWINGS:			
SCALE: SIP-367-814-009			
PAPER SIZE: A2			
DRAWING NUMBER			
SYSTEM			
SH.NO.			
REV. 0			